


N
M
L
K
J
H
G
F
E
D
C
B
A

1 2 3 4 5 6 7 8 9 10 11 12 13 14

S:\P\Projects\2021\2104600\Drawings\N-E\F300-2104600.dwg

PLOT DATE: 12/14/2021 1:20 PM

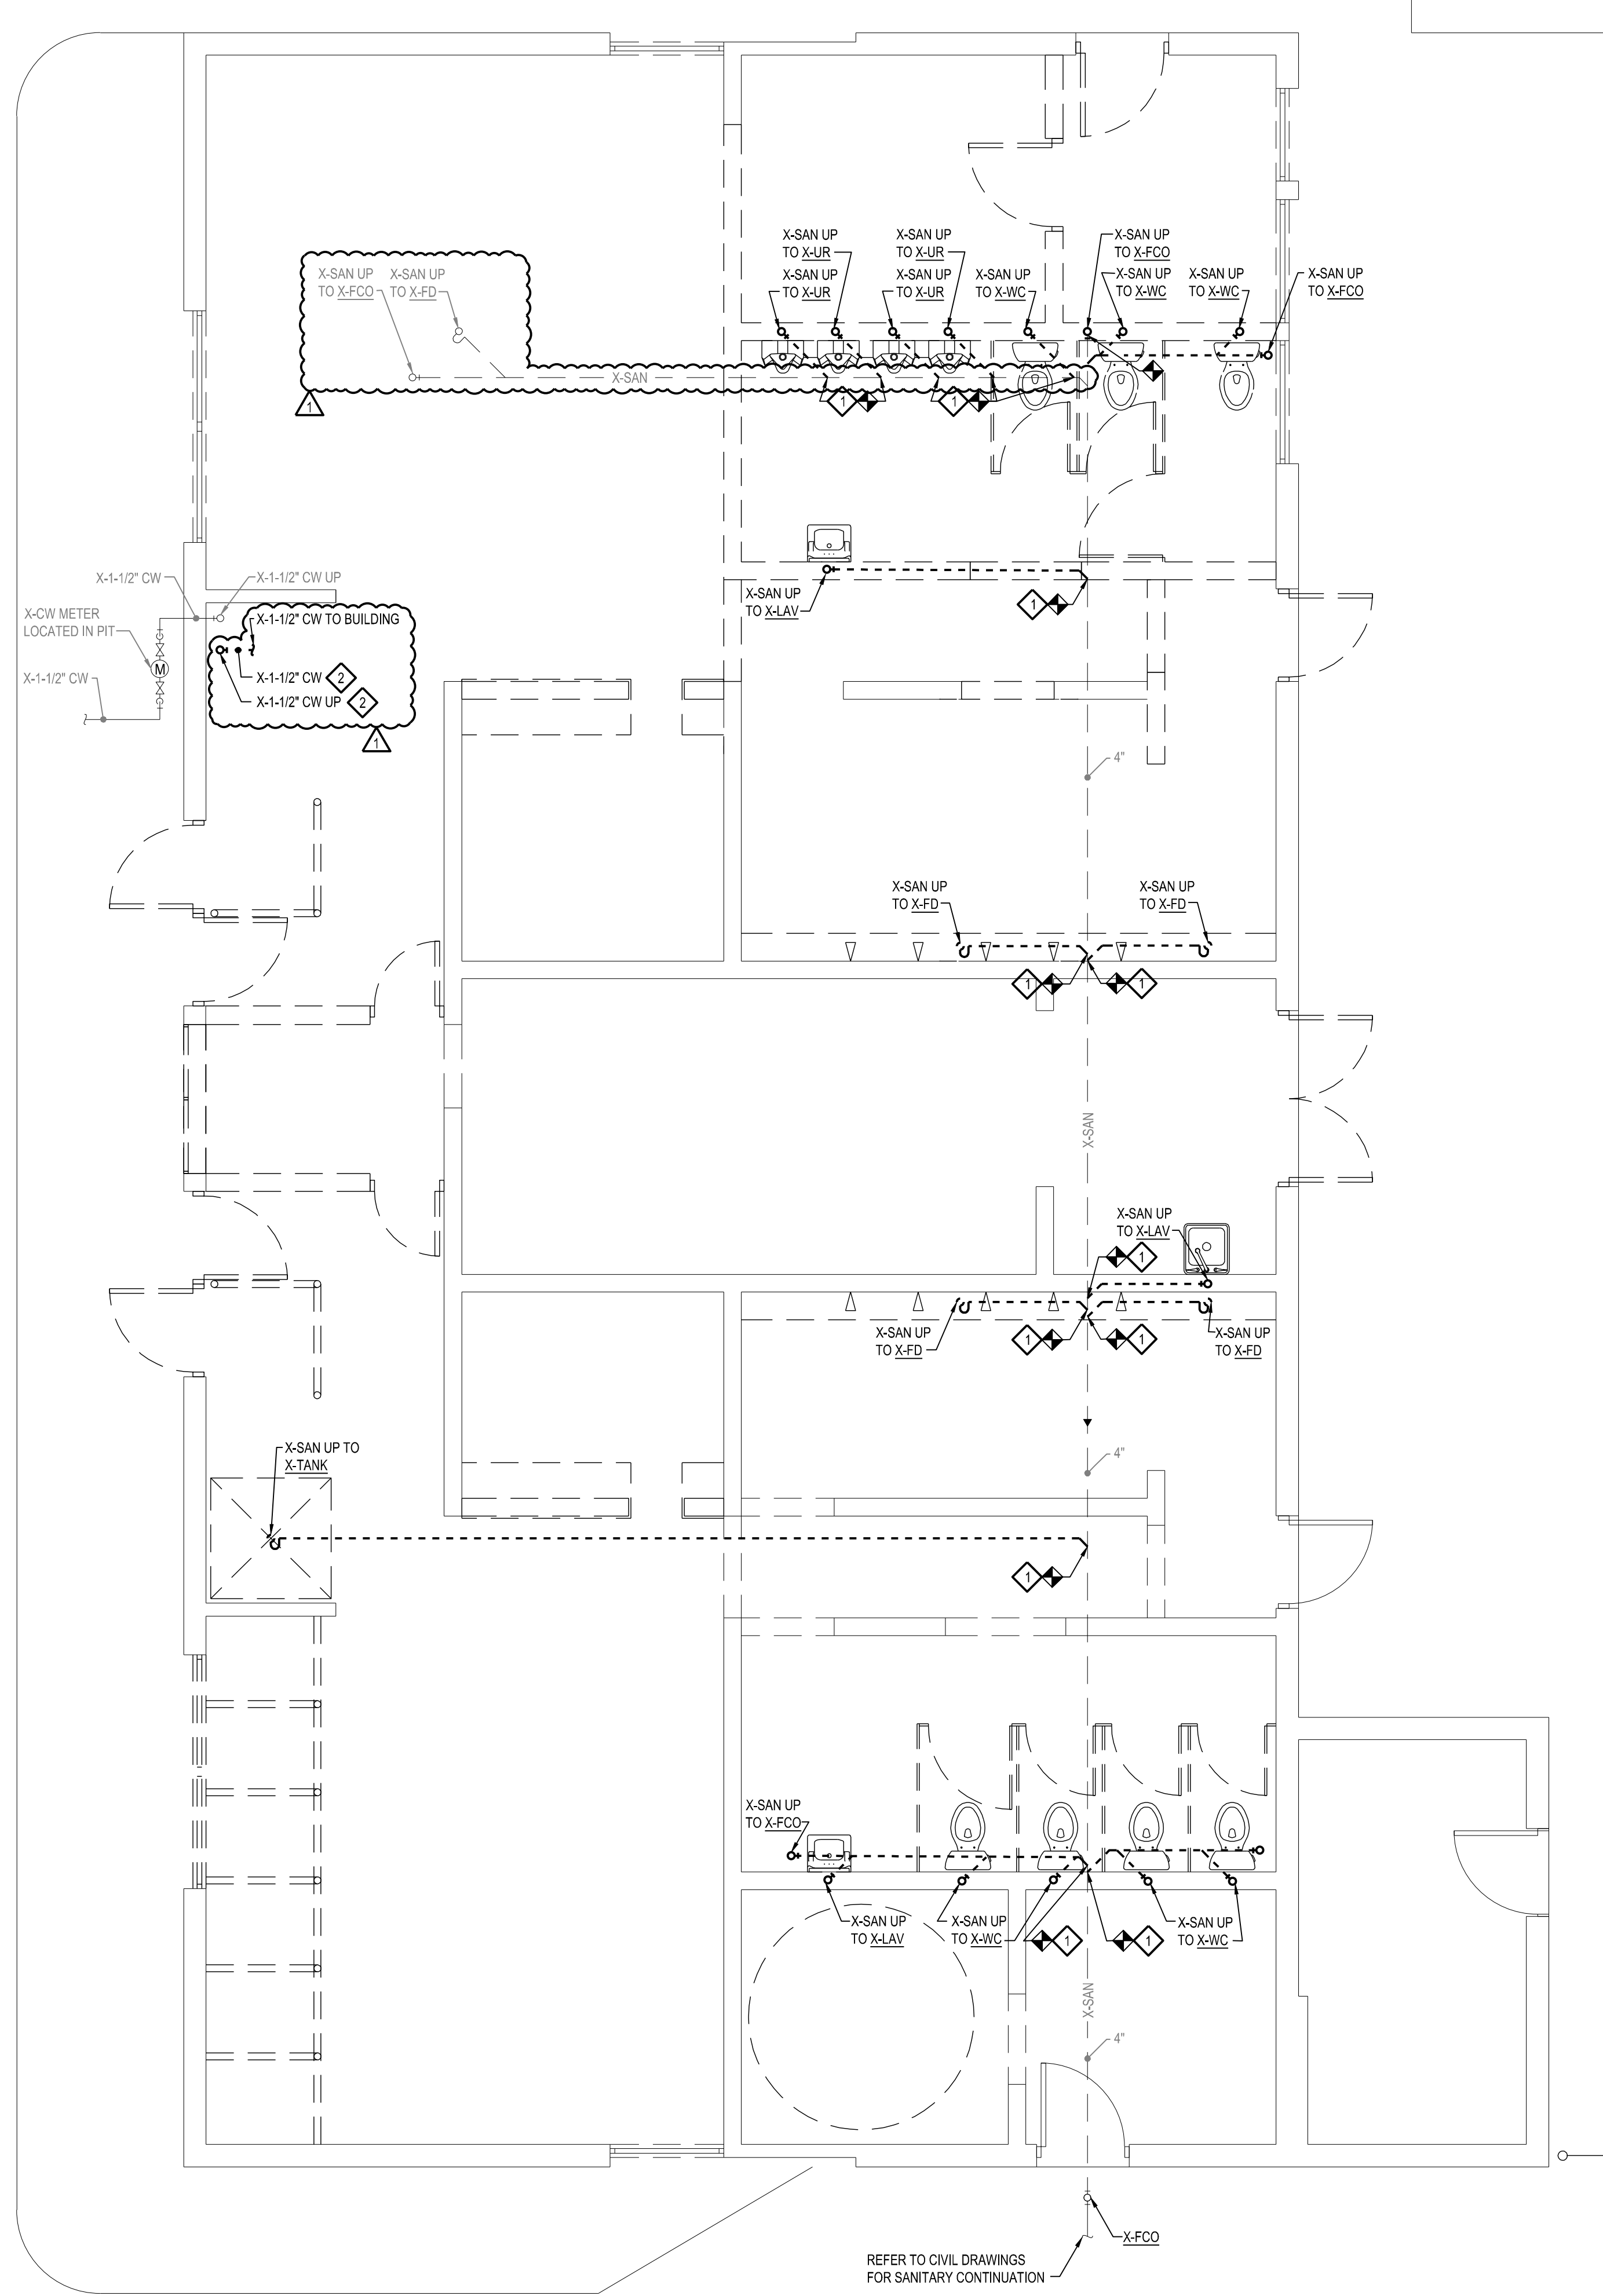

BELOW FLOOR PLAN - PLUMBING DEMOLITION
 SCALE: 1/4" = 1'-0"

GENERAL PLUMBING NOTES

- CONTRACTOR TO FIELD VERIFY ALL EXISTING UNDERGROUND UTILITIES PRIOR TO STARTING CONSTRUCTION.

DEMOLITION NOTES

- ◇ DISCONNECT, REMOVE AND DEMO EXISTING SANITARY PIPING TO EXTENTS SHOWN AND CAP.
- ◇ DISCONNECT, REMOVE, AND DEMO EXISTING COLD WATER PIPING TO EXTENTS SHOWN ON PLUMBING FLOOR PLAN.

MATRIX
 CONSULTING ENGINEERS, INC.

1601 E. CASSAUBON AVENUE
 LANSING, MI 48206
 PHONE: (517) 487-2511
 FAX: (517) 487-2544
 administrator@matrixinc.com
 Matrix Project No. 2104600

H2A
 architects

9100 Lapeer Rd. Suite B
 Davison, MI 48423
 (810) 412-5640
 www.h2aarchitects.net

NO.	DESCRIPTION	DATE
6		
5		
4		
3		
2		
1	Addendum 1	12/14/2021

CITY OF ONOSSO
WARMING CENTER RENOVATIONS
 1225 WALNUT ST.
 ONOSSO, MI 48867

DRAWING TITLE
BELOW FLOOR PLAN - PLUMBING DEMOLITION

PROJECT NO. 21-450
 DATE 12/14/2021
 DRAWN NLS
 CHECKED CAT

P300

CAD FILE NO.
 SCALE 1/4" = 1'-0" SHEET 14 OF 22

12/14/2021