


N
M
L
K
J
H
G
F
E
D
C
B
A

1 2 3 4 5 6 7 8 9 10 11 12 13 14

S:\Projects\2021\2104600\Drawings\A-E\F301-2104600.dwg

PLOT DATE: 12/14/2021 1:21 PM

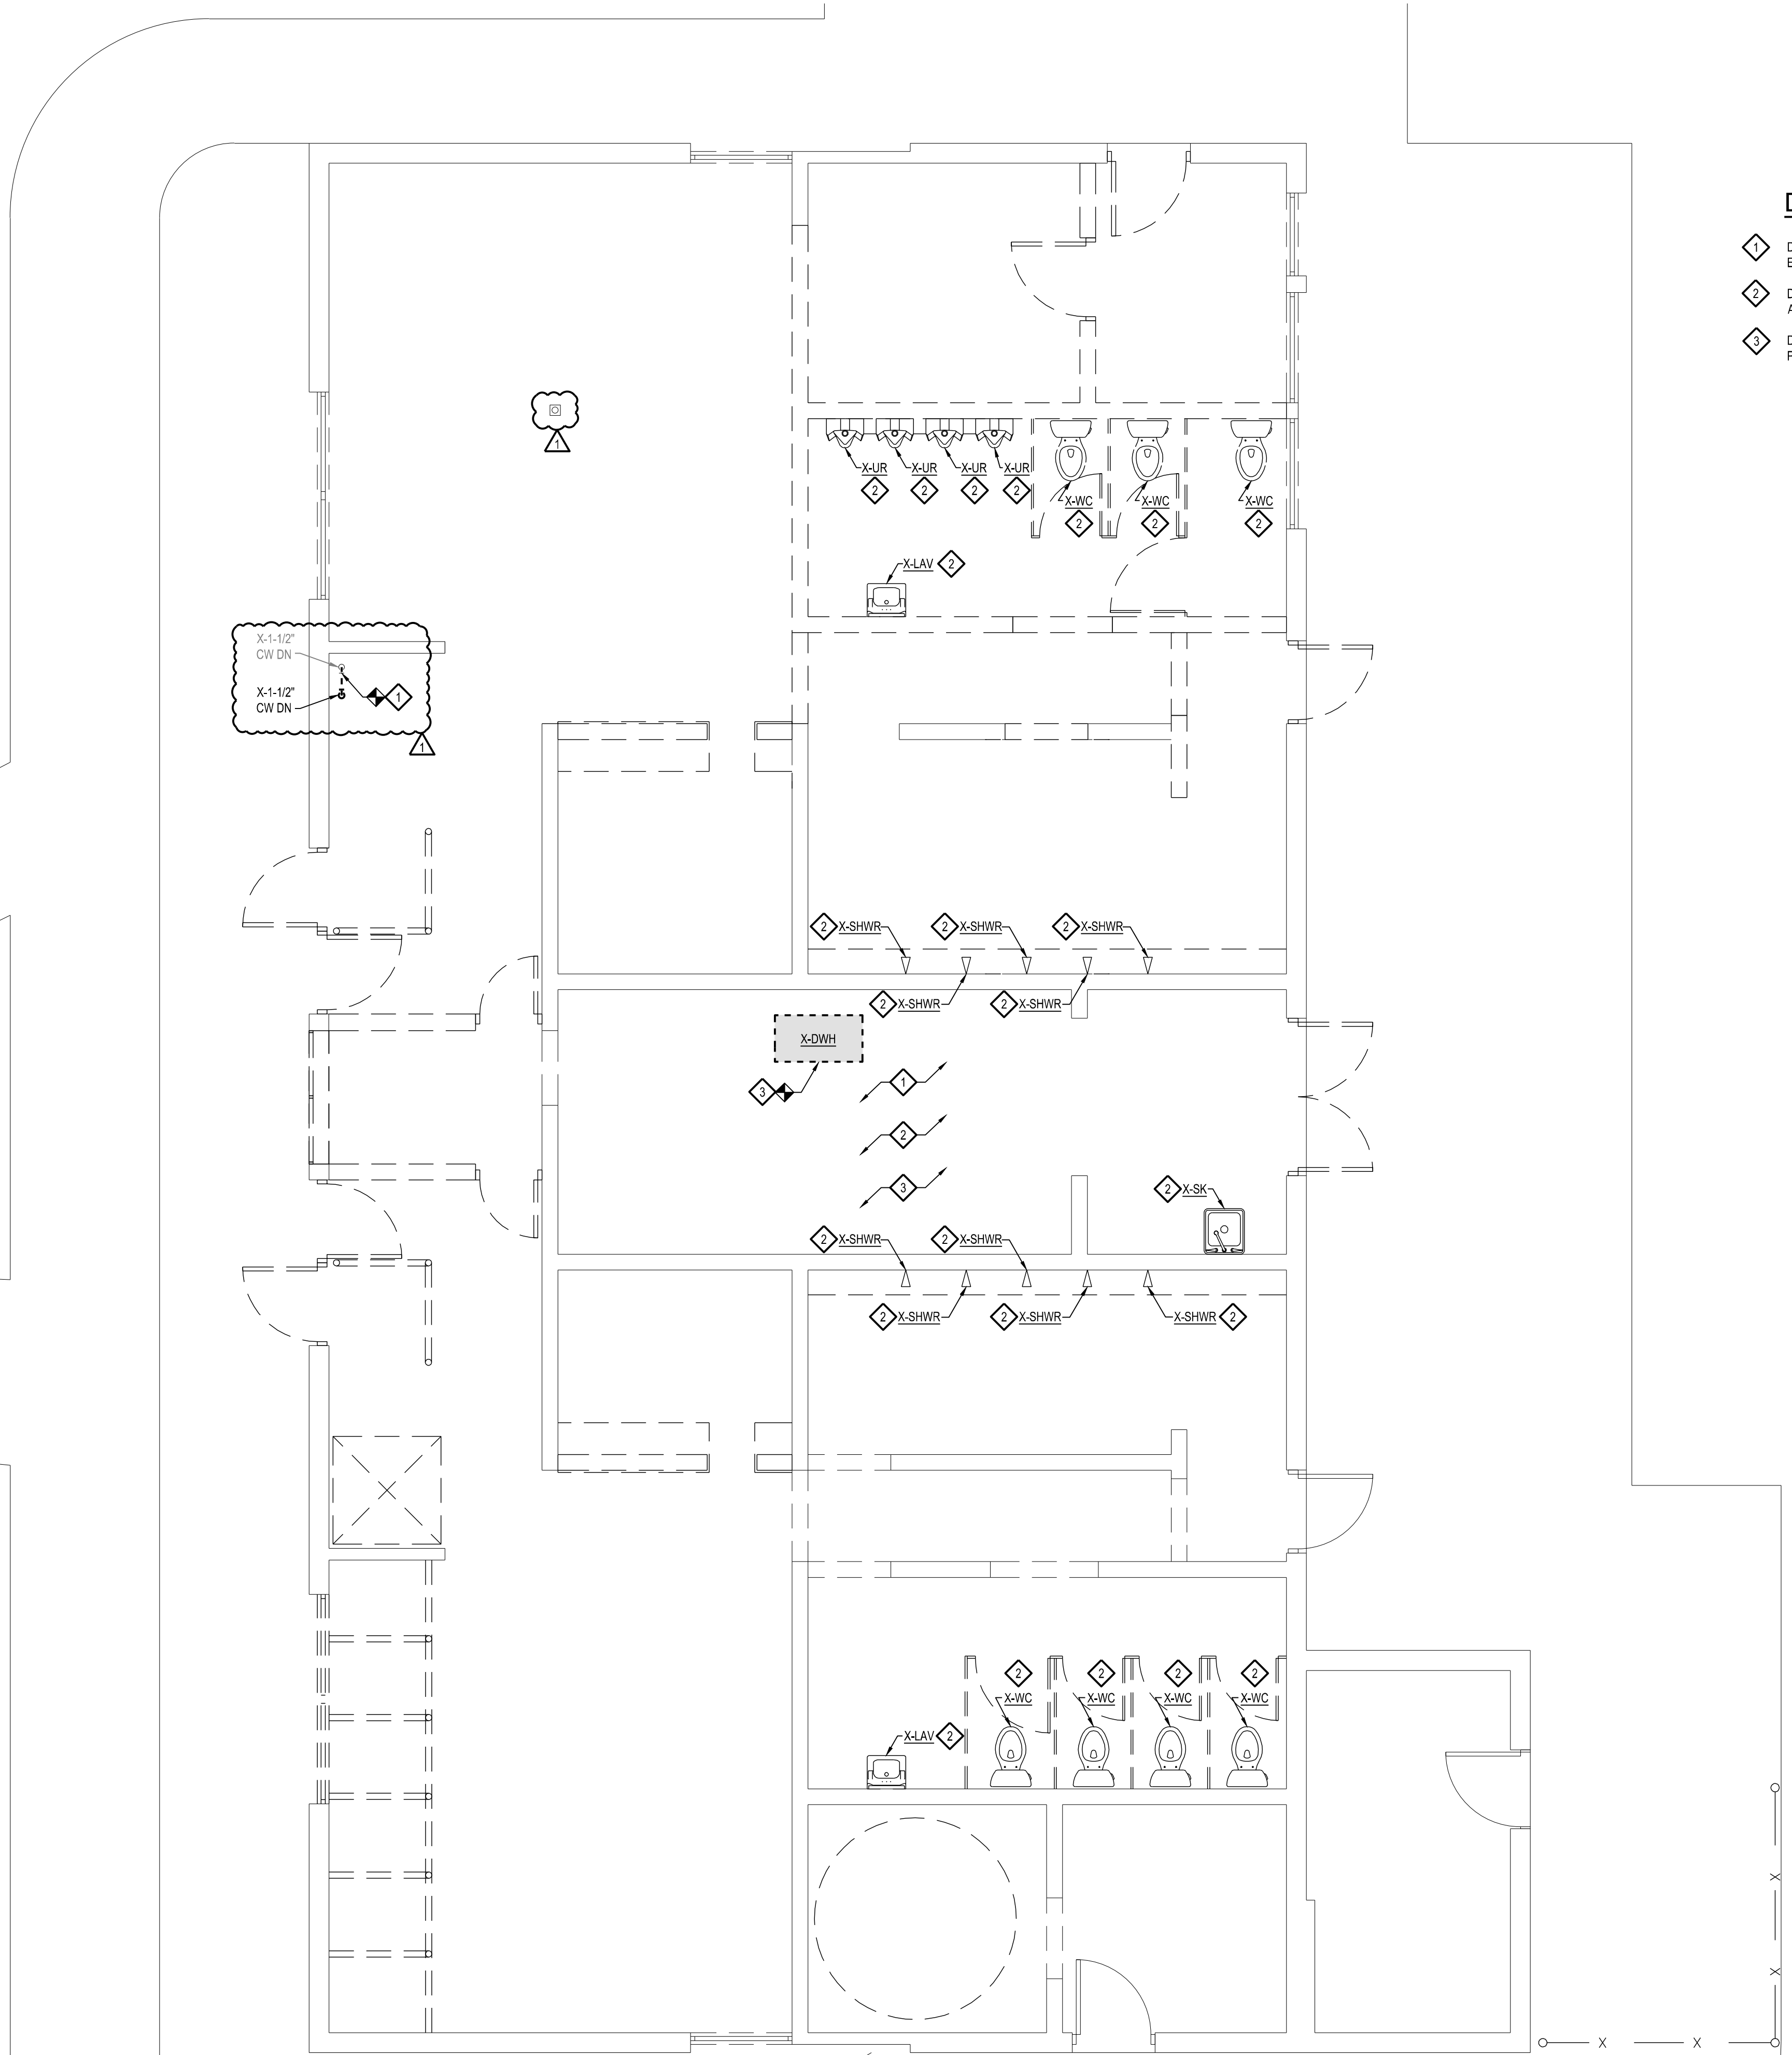

DEMOLITION NOTES

- 1 DISCONNECT, REMOVE AND DEMO ALL EXISTING COLD WATER PIPING BACK TO EXTENTS SHOWN.
- 2 DISCONNECT, REMOVE AND DEMO PLUMBING FIXTURE IN ITS ENTIRETY INCLUDING ALL PIPING.
- 3 DISCONNECT, REMOVE AND DEMO EXISTING WATER HEATER AND ALL ASSOCIATED PIPING IN ITS ENTIRETY.

FLOOR PLAN - PLUMBING DEMOLITION
SCALE: 1/4" = 1'-0"

MATRIX
CONSULTING ENGINEERS, INC.

1601 E. CESAR CHAVEZ AVE
LANSING, MI 48206
PHONE: (313) 487-2511
FAX: (313) 487-2544
administrator@matrixinc.com
Main Project No. 2104600

H2A
architects

9100 Lapeer Rd. Suite B
Davison, MI 48423
(810) 412-5640
www.h2aarchitects.net

NO.	DESCRIPTION	DATE
6		
5		
4		
3		
2		
1	Addendum 1	12/14/2021

CITY OF ONOSSO
WARMING CENTER RENOVATIONS
1225 WALNUT ST.
ONOSSO, MI 48867

DRAWING TITLE
FLOOR PLAN - PLUMBING DEMOLITION

PROJECT NO. 21-450
DATE 12/14/2021
DRAWN NLS
CHECKED CAT

P301

CAD FILE NO.
SCALE 1/4" = 1'-0" SHEET 15 OF 22

12/14/2021