
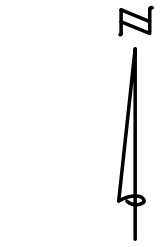



CITY OF OWOSSO
WATER TREATMENT PLANT
WASH WATER PUMP & PIPING REPLACEMENT
OWOSSO, SHIAWASSEE COUNTY, MI
DWRF #7457-01

INDEX OF SHEETS	
SHEET NO.	DESCRIPTION
G-101	COVER
G-102	GENERAL NOTES
P-001	LEGEND
P-101	HYDRAULIC PROFILE
P-102	PROCESS FLOW DIAGRAM
P-103	GENERAL DEMOLITION
P-201	BACKWASH PUMP & PIPING PLAN & SECTIONS
P-202	LOSS OF HEAD TRANSMITTERS
P-203	HIGH SERVICE PIPE PLAN
P-301	PUMP, VALVE & PIPE SCHEDULES
P-401	DETAILS
I-101	PROPOSED PIPING AND INSTRUMENTATION DIAGRAM
E-001	GENERAL ELECTRICAL INFORMATION
E-201	LOWER LEVEL AND WELL HOUSE POWER PLANS
E-202	UPPER LEVEL POWER PLAN
E-401	PROPOSED ONE-LINE DIAGRAM
E-402	ELECTRICAL DETAILS AND SCHEDULES
E-403	PUMP MOTOR AND VFD WIRING DIAGRAM
E-404	VFD WIRING DIAGRAM
E-405	CONTROL WIRING

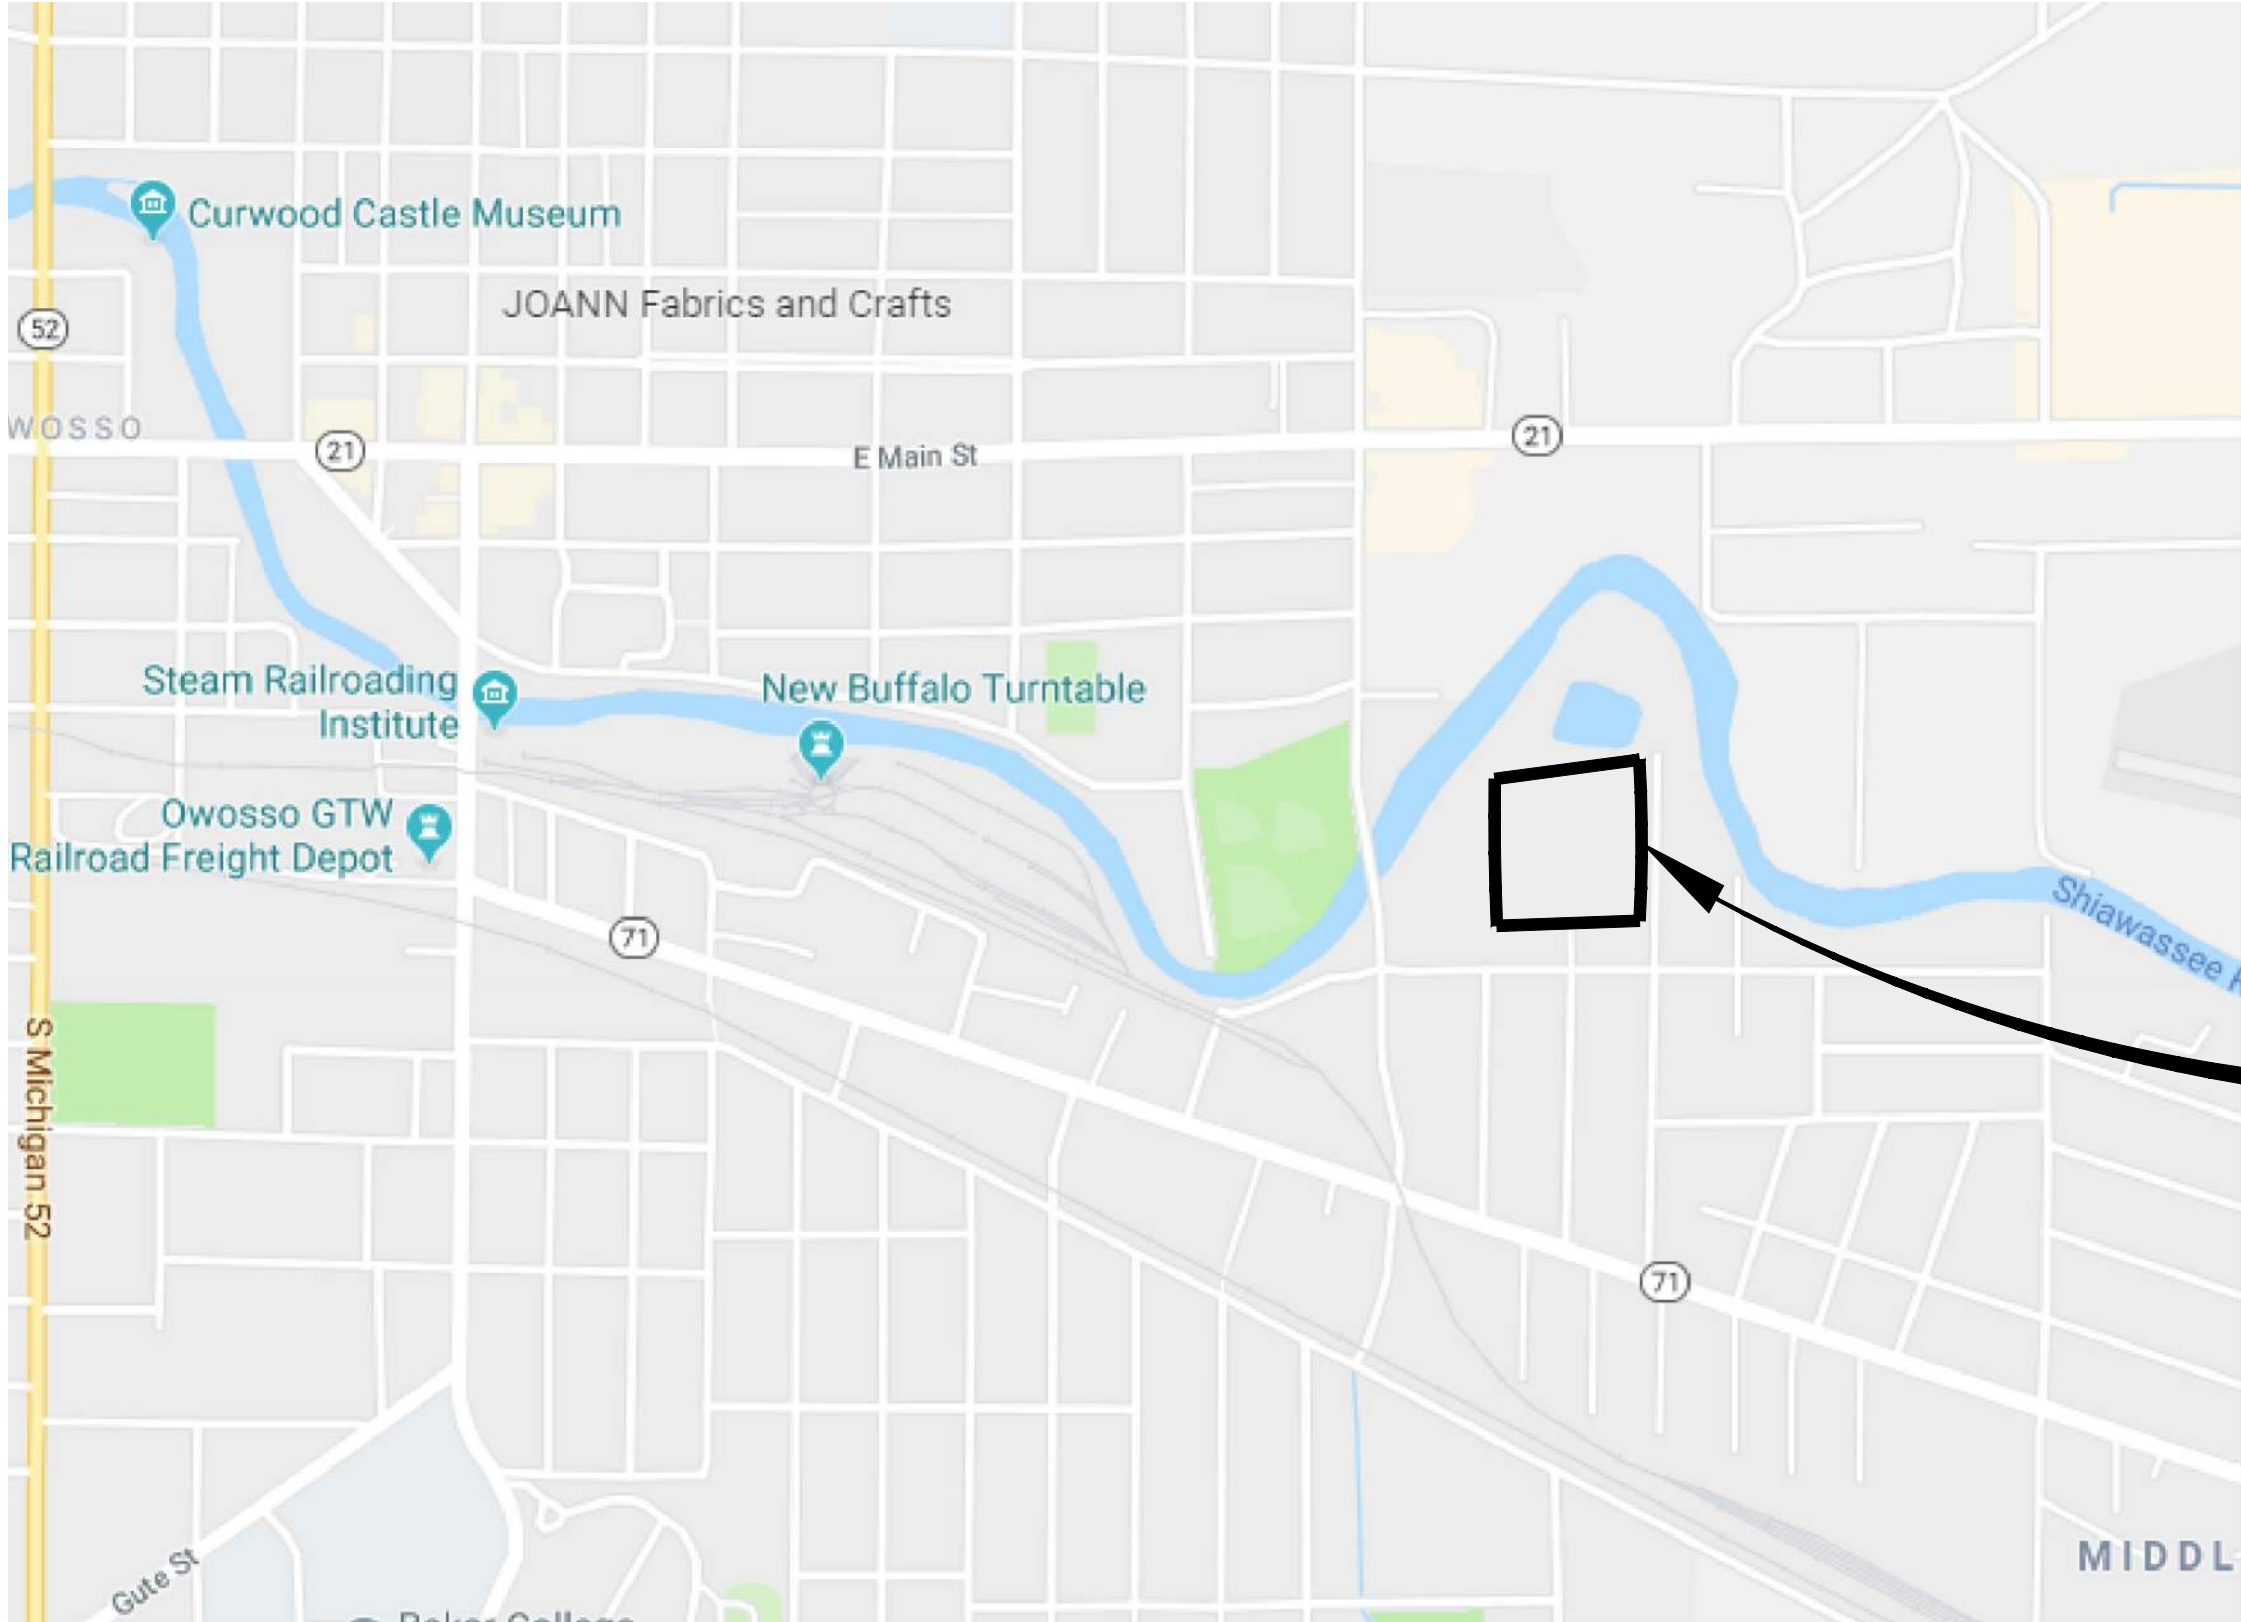

PROJECT LOCATION
1111 ALLENDALE AVE
OWOSSO, MI 48867

LOCATION MAP
N.T.S.

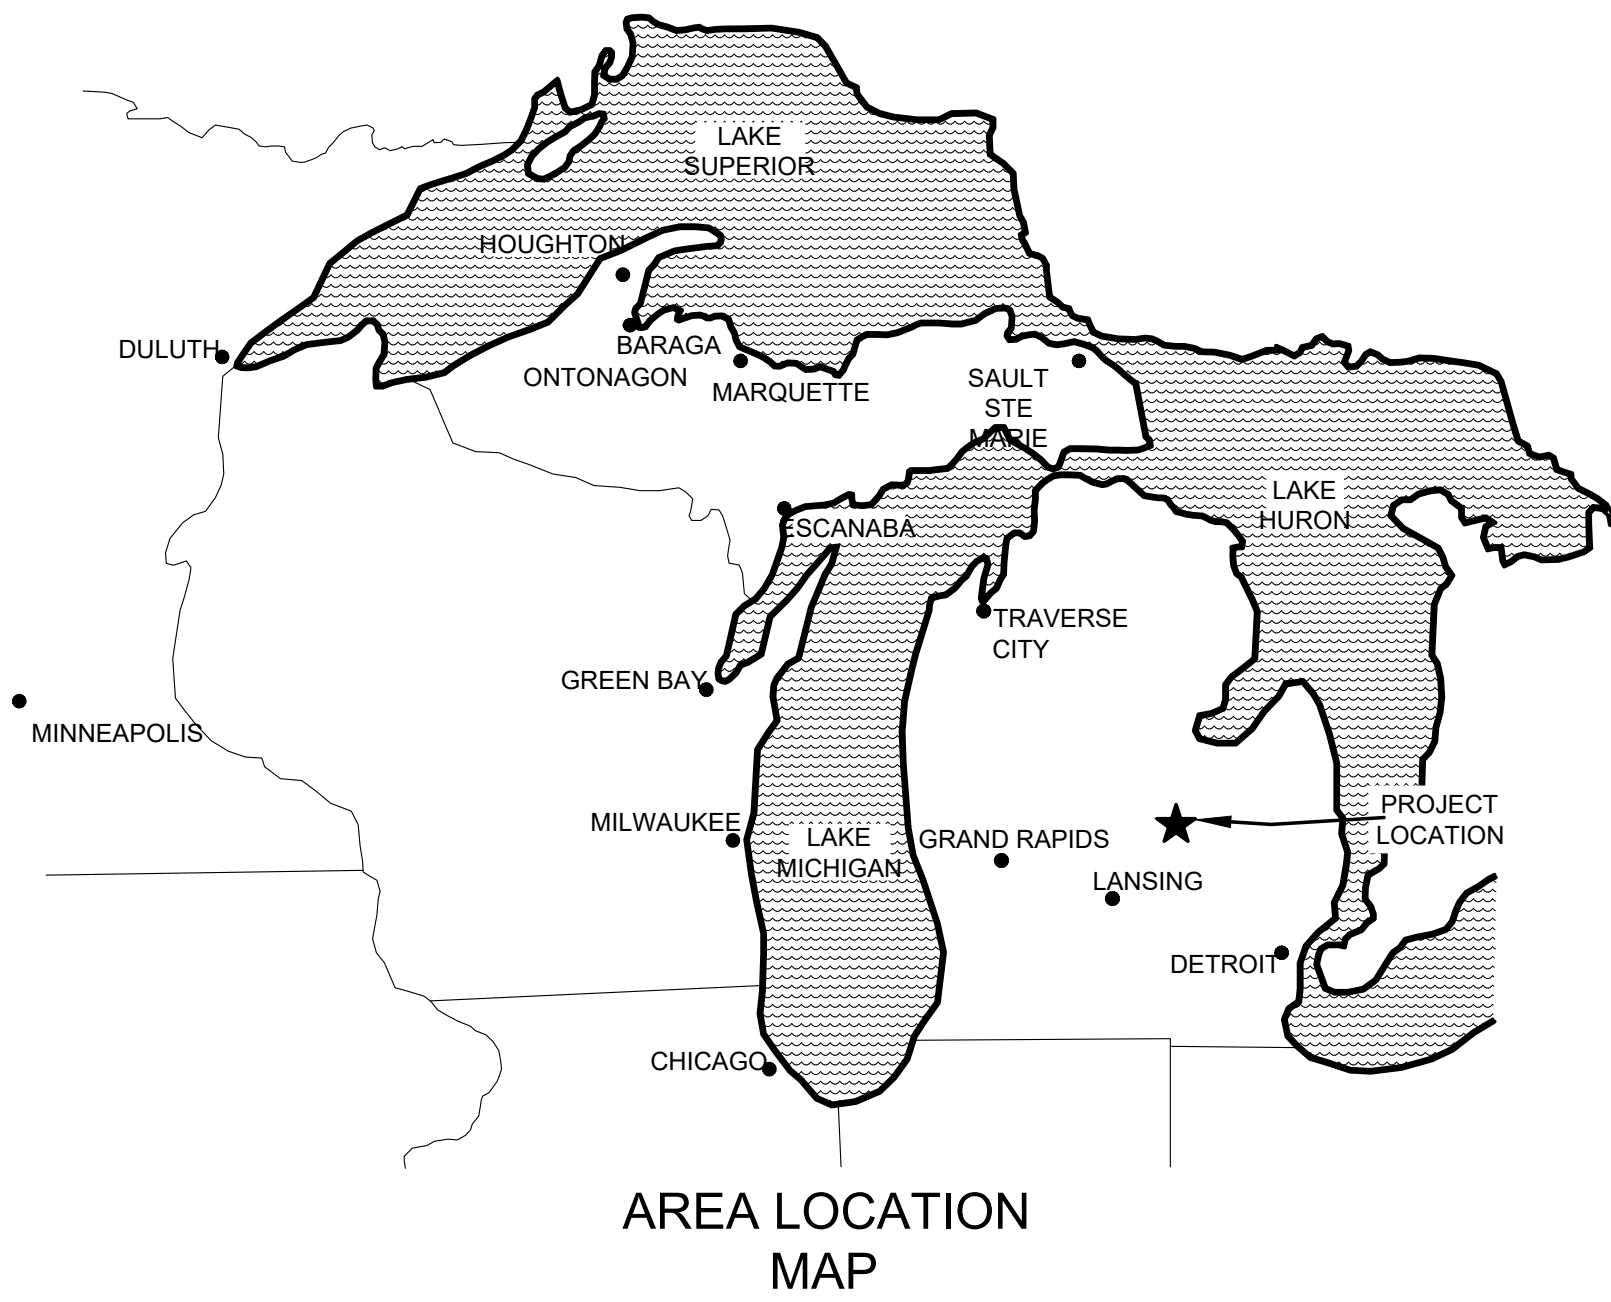

AREA LOCATION
MAP

APPROVAL DATE	PERMITS	PERMIT NUMBER
12/13/2019	EGL PART 399 PERMIT	W191067

ISSUED FOR BIDS
OHM PROJECT No. 0020-19-0040
PROJECT MANAGER: JENNIFER DRINAN, P.E.
DATE: 12/16/2019







I Certify That The Overall Plans Were Prepared Under My Direct Supervision

I Certify That The Process Plans Were Prepared Under My Direct Supervision

I Certify That The Electrical Plans Were Prepared Under My Direct Supervision

DRAWING PATH: \\ohm\dfs\corporate\Projects\0000_01000002019\040_wtp_design_services\Drawings\Utilities\Sheets\180040C-102.DWG Dec 16, 2019 - 11:48am

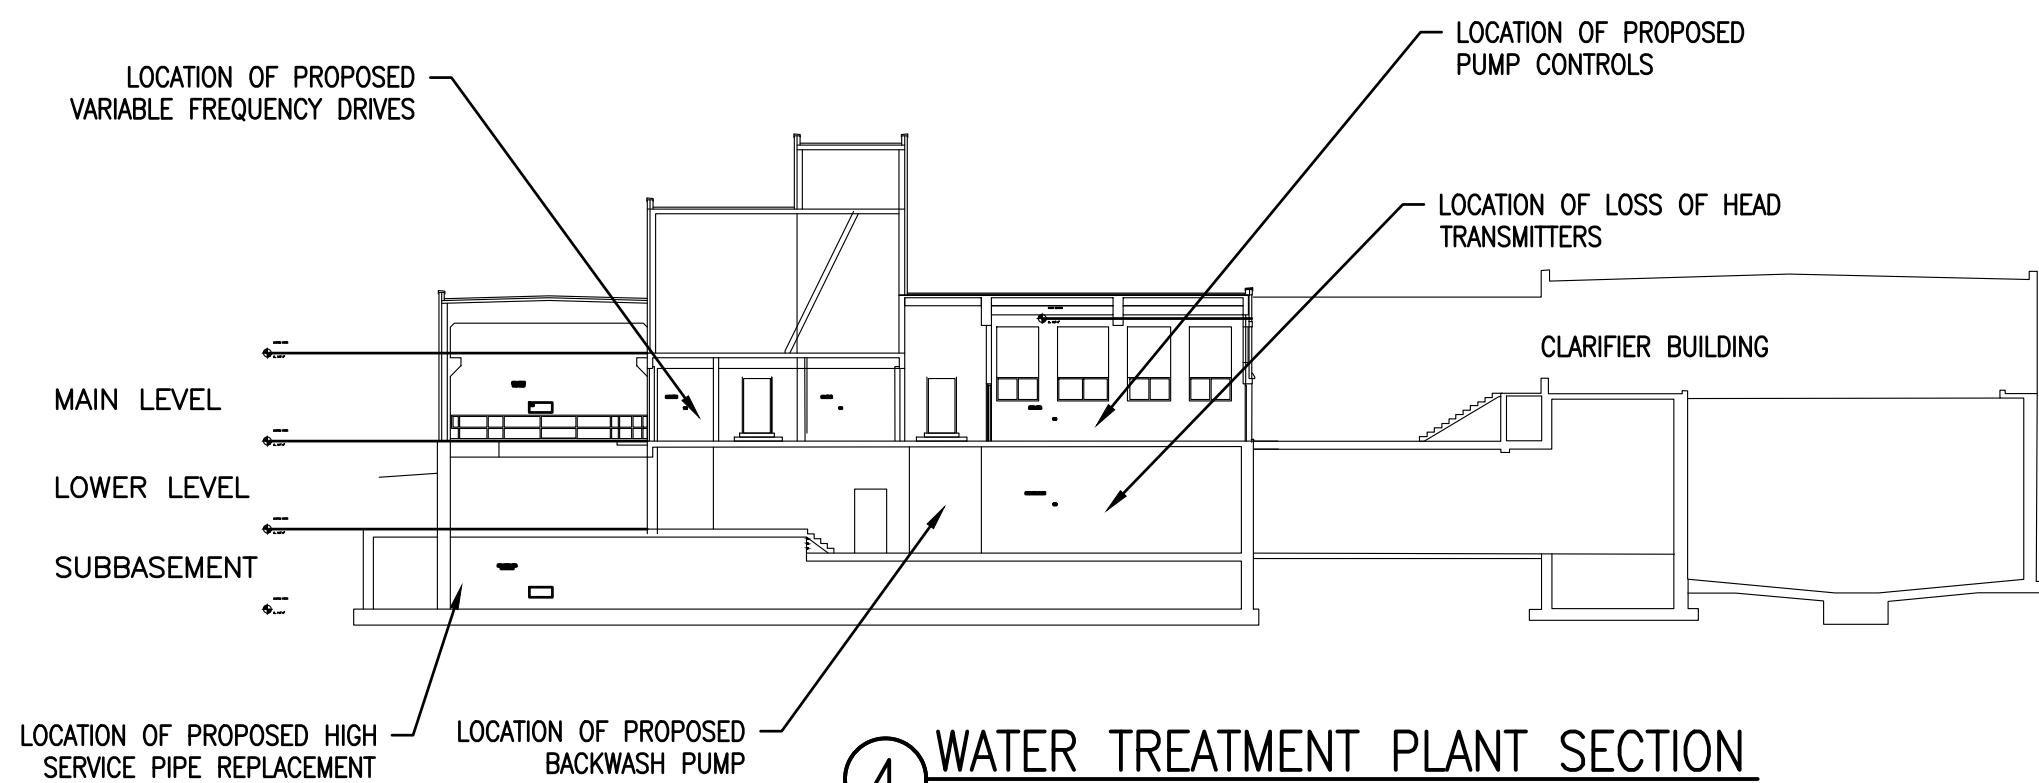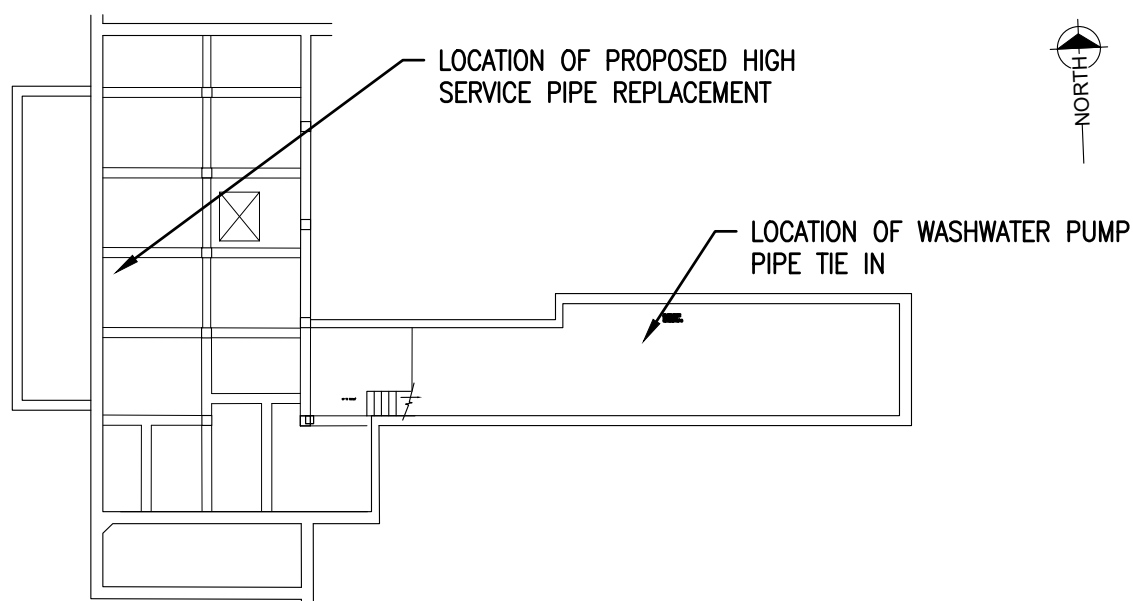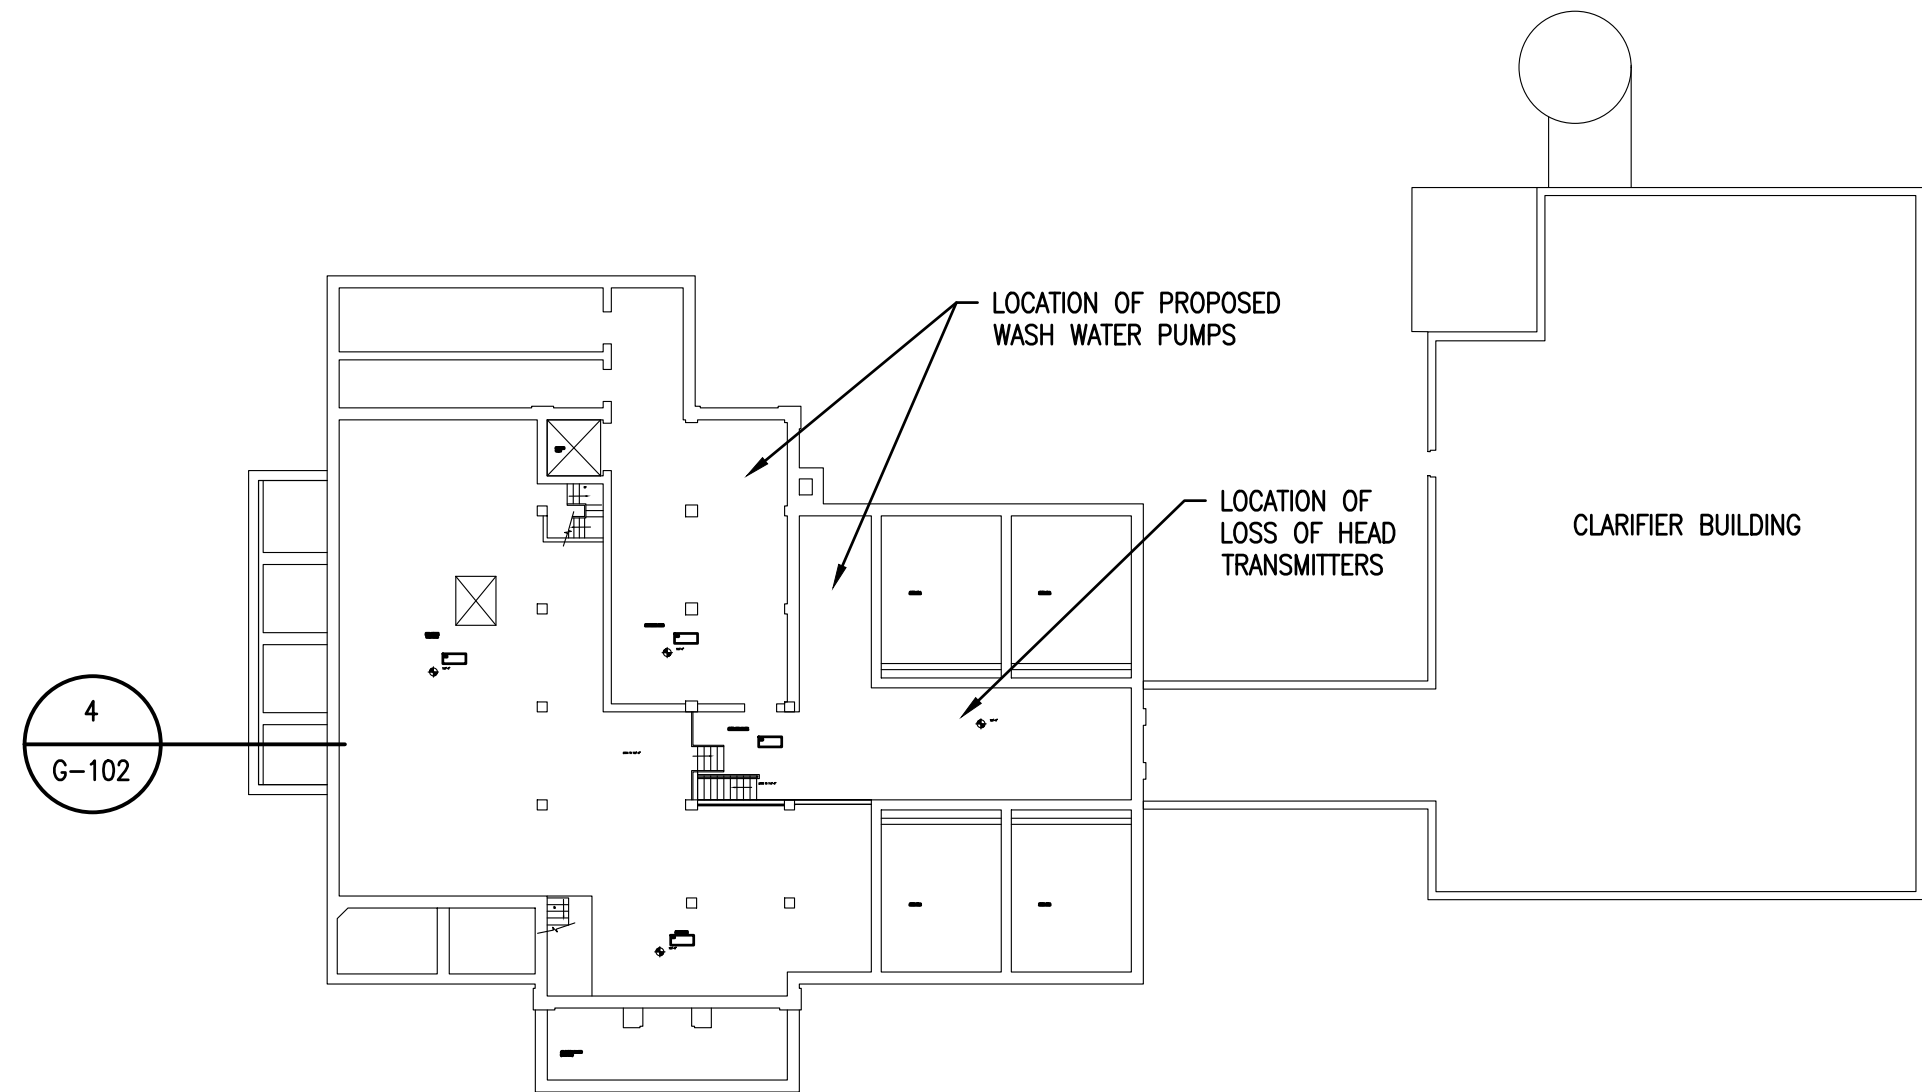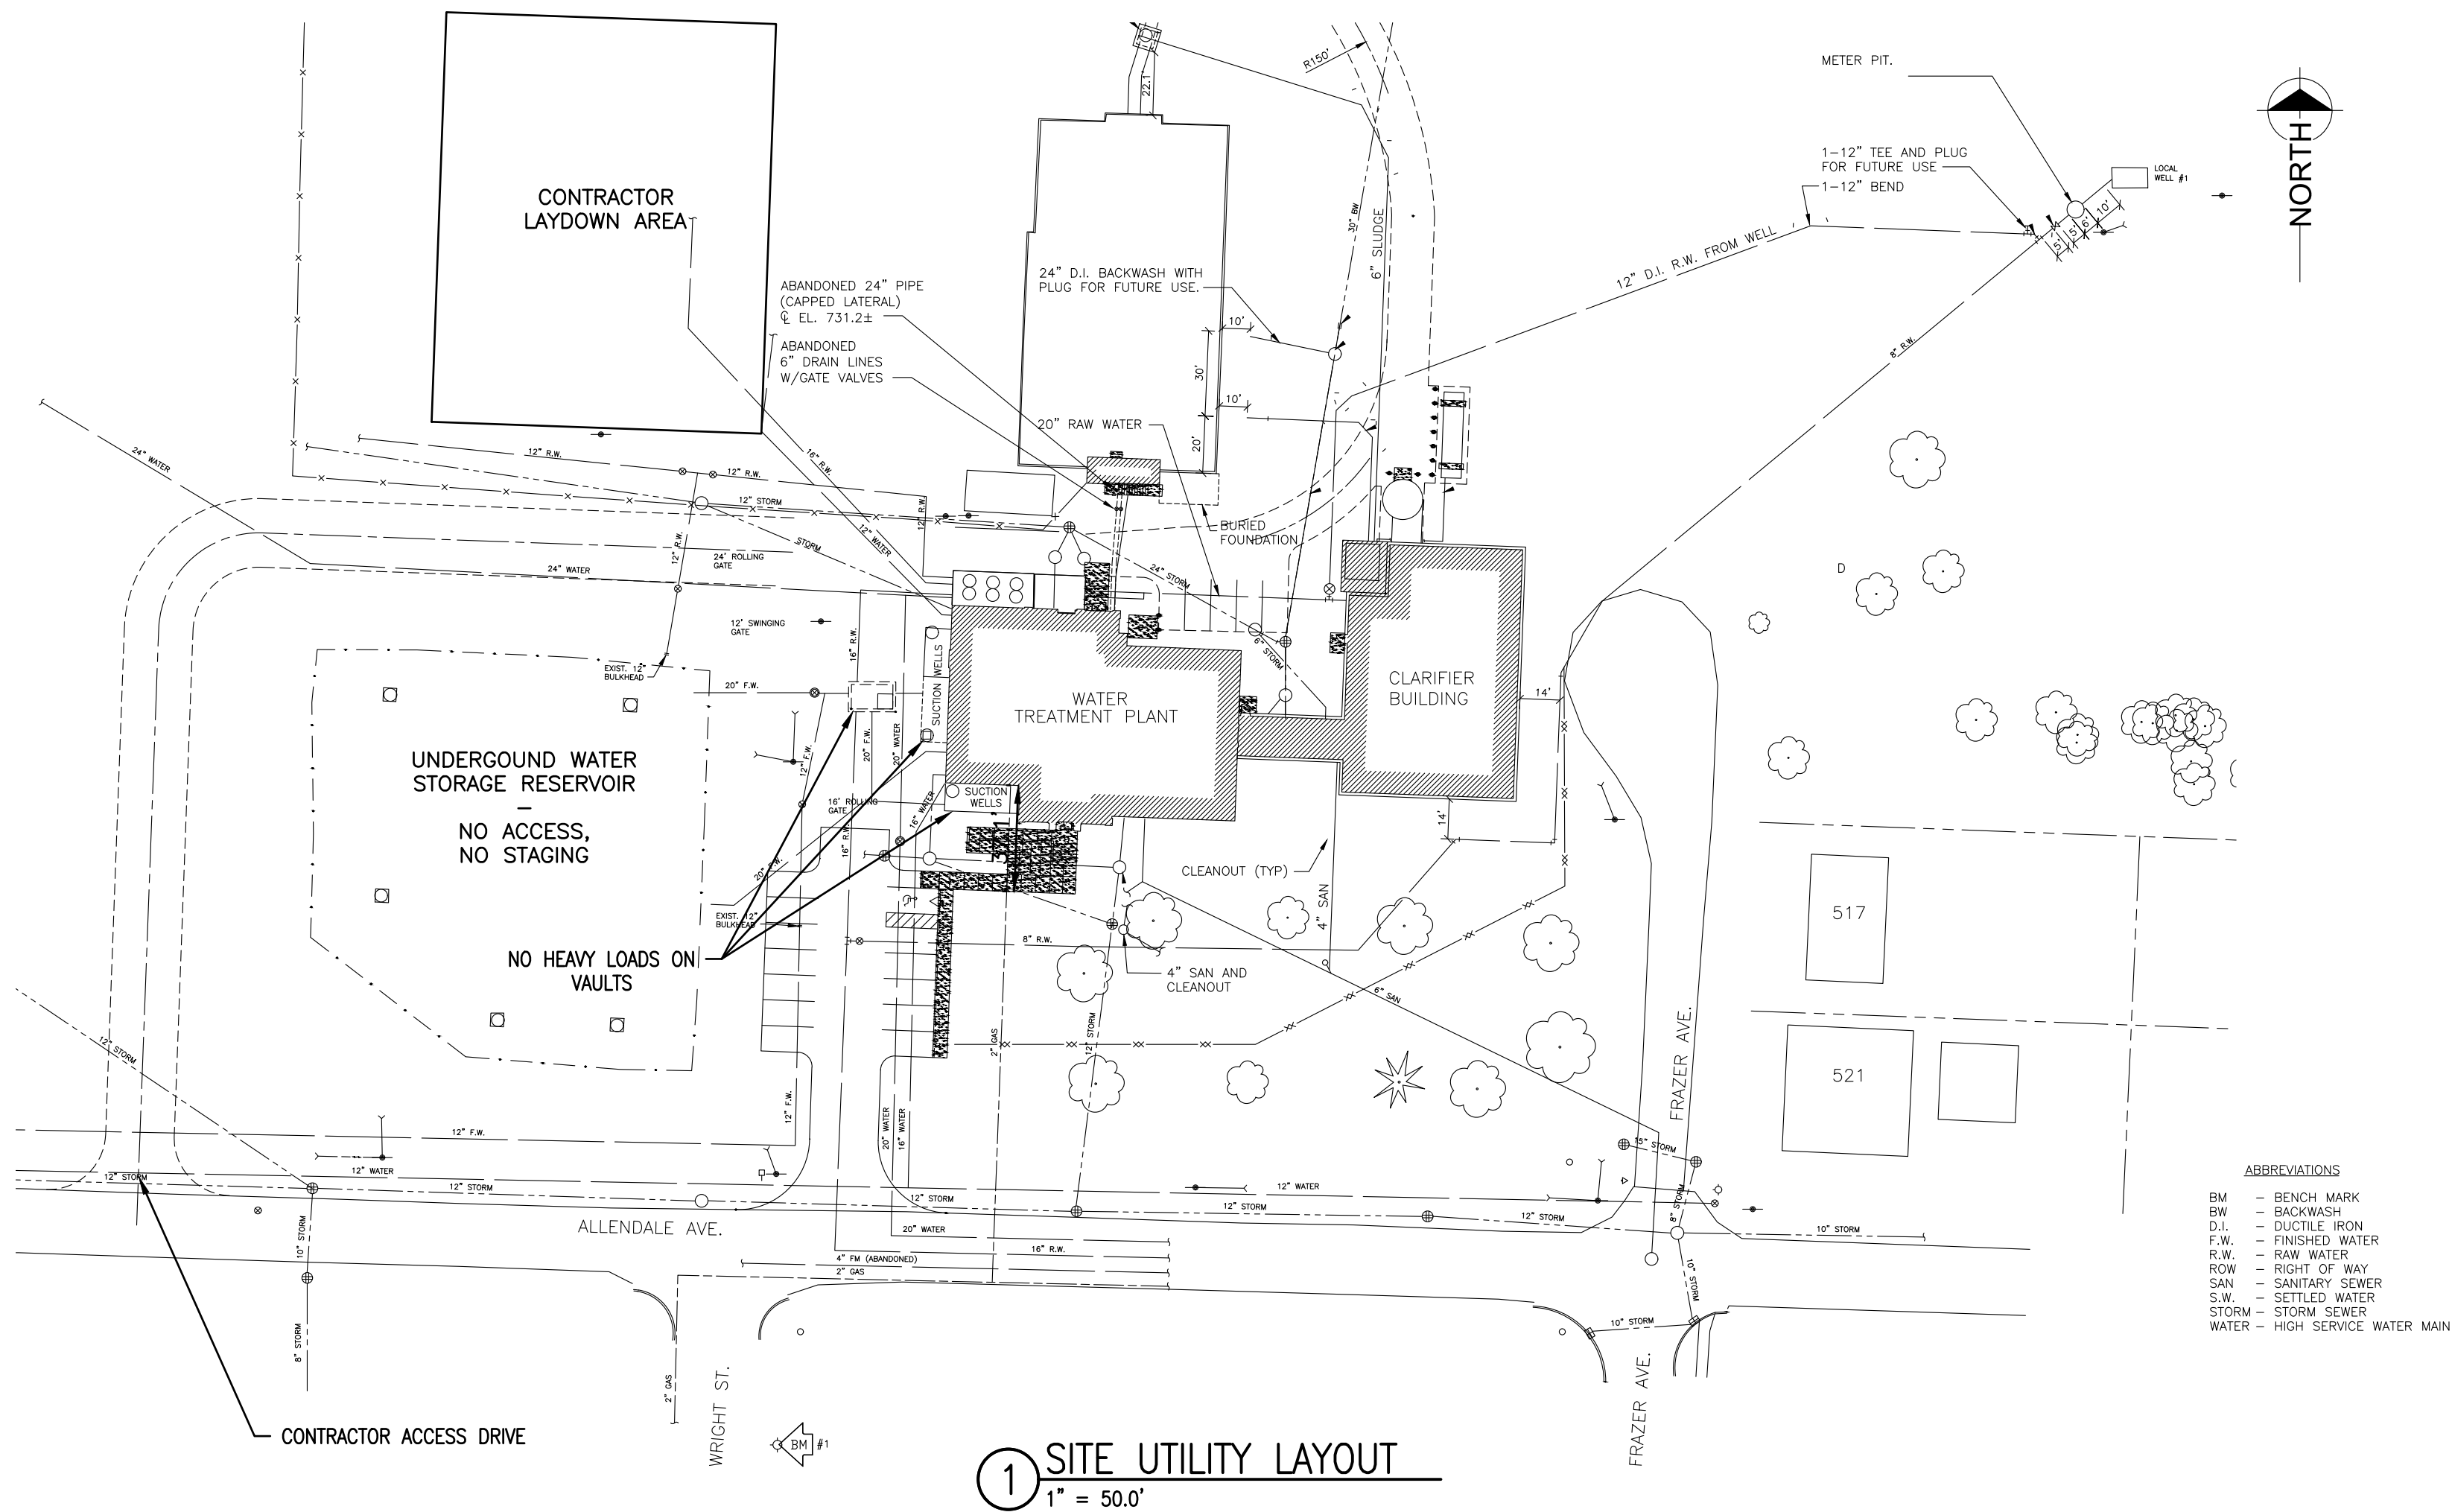


GENERAL NOTES:


- ALL NEW WORK IS SHOWN WITH HEAVY LINES AND IS INDICATED NEW UNLESS NOTED OTHERWISE.
- THE CONTRACTOR'S ATTENTION IS CALLED TO THE FACT THAT ADDITIONAL CONTRACTS MAY BE LET ADJACENT TO HIS WORK AND THAT HE SHALL COORDINATE THOSE PORTIONS OF HIS WORK AFFECTED BY OTHERS. HE SHALL COOPERATE WITH THEM IN EVERY REASONABLE WAY SO THAT THERE SHALL BE A MINIMUM PRACTICABLE INTERFERENCE WITH THEIR OPERATIONS.
- THE CONTRACTOR SHALL MAKE AN ON-SITE INSPECTION OF THE FACILITY AND RELATED CONDITIONS PRIOR TO BIDDING THIS CONTRACT.
- THE CONTRACTOR SHALL TAKE ALL NECESSARY PRECAUTIONS TO PROTECT EXISTING STRUCTURES, UTILITIES AND EQUIPMENT, AND TO MAINTAIN UNINTERRUPTED FACILITY OPERATION. THE CONTRACTOR SHALL PROVIDE ALL TEMPORARY SUPPORTS, BRACES AND SHORING AS NECESSARY TO PROTECT AND MAINTAIN ALL STRUCTURES, PIPING, EQUIPMENT AND APPURTENANCES. ANY DAMAGE RESULTING FROM THE ACTIONS, OR LACK OF ACTIONS BY THE CONTRACTOR SHALL BE REPAIRED IMMEDIATELY BY THE CONTRACTOR AT HIS EXPENSE.
- AN ASTERISK (*) AT NEW CONSTRUCTION DENOTES LOCATIONS, ELEVATIONS, DIMENSIONS AND OTHER INFORMATION DEPENDENT ON THE CONTRACTOR'S SUBMITTALS. THE CONTRACTOR SHALL DEVELOP AND SHOW THE INFORMATION MARKED WITH AN ASTERISK (*) ON HIS SUBMITTALS AND SHALL DEVELOP AND PROVIDE SUCH INFORMATION FOR ALL ASTERISKS (*) WITHIN OR INTERFACING WITH ANY SUBMITTALS AND BETWEEN SUBMITTALS. THIS REQUIREMENT ALSO EXTENDS TO CONDITIONS OR SITUATIONS WHERE A LOCATION, DIMENSION, ELEVATION OR OTHER ITEM IS INDICATED TO BE DETERMINED AFTER FINAL SELECTION OF EQUIPMENT AND/OR APPURTENANCES. ALL INFORMATION FOR ASTERISK (*) AND EQUIPMENT/APURTENANCES SITUATIONS DESCRIBED HEREIN ARE THE RESPONSIBILITY OF THE CONTRACTOR TO DEVELOP AND ASSURE COMPATIBLE INTERFACING FOR A COMPLETE, COORDINATED AND TROUBLE-FREE OPERATING INSTALLATION. ALL REQUIREMENTS HEREIN SHALL BE BASED ON FINAL PROCESSING AND/OR REVIEW OF THE CONTRACTOR'S SUBMITTALS OR SELECTIONS.
- LOCATIONS, ELEVATIONS AND DIMENSIONS OF EXISTING PIPING, EQUIPMENT, STRUCTURES AND OTHER EXISTING WORK ARE BASED ON INFORMATION FURNISHED BY EXISTING RECORD DRAWINGS AND CONTRACT DOCUMENTS AND IN SOME INSTANCES FIELD MEASUREMENTS BUT DO NOT PURPORT TO BE ABSOLUTELY CORRECT. LOCATIONS, ELEVATIONS AND DIMENSIONS OF NEW WORK CONNECTING OR ADJACENT TO OR INTERFACING WITH EXISTING WORK HAVE BEEN DEVELOPED AND ARRANGED BASED ON THE FOREGOING INFORMATION AND FIELD MEASUREMENTS. THE CONTRACTOR IS RESPONSIBLE TO FIELD CHECK AND MEASURE LOCATIONS, ELEVATIONS AND DIMENSIONS AND TO FIT AND OTHERWISE INSTALL THE NEW WORK TO ACTUAL EXISTING LOCATIONS, ELEVATIONS AND DIMENSIONS FOR A COMPLETE AND TROUBLE-FREE OPERATING FACILITY.
- THE CONTRACTOR IS RESPONSIBLE TO MAKE ALL MEASUREMENTS NECESSARY TO LOCATE, FABRICATE, ERECT, CONSTRUCT AND OTHERWISE INSTALL ALL NEW WORK IN EXISTING AND NEW LOCATIONS AND RELOCATE AND REWORK EXISTING WORK ALL TO THE ARRANGEMENTS, GUIDANCE AND INSTRUCTIONS SHOWN AND REQUIRED FOR A COMPLETE TROUBLE-FREE OPERATING INSTALLATION.
- THE CONTRACTOR SHALL PAINT EXISTING FACILITIES AND WORK IF EXISTING PAINT OR COATINGS ARE DAMAGED BY THE CONTRACTOR'S OPERATIONS. ALL EXISTING WORK INCORPORATED WITHIN OR AS PART OF NEW WORK SHALL BE PAINTED IN ACCORDANCE WITH THE CONTRACT DOCUMENTS.
- THE CONTRACTOR SHALL SUBMIT STRUCTURAL LOAD CALCULATIONS AND WORKING DRAWINGS PREPARED BY A REGISTERED PROFESSIONAL ENGINEER IN THE STATE OF MICHIGAN FOR PRIOR APPROVAL SHOWING ALL CONSTRUCTION LOADS ON EXISTING STRUCTURES AND FACILITIES AND SHALL DEMONSTRATE TO THE SATISFACTION OF THE ENGINEER THAT THE CAPACITY OF EXISTING STRUCTURES AND FACILITIES WILL NOT BE EXCEEDED BY ANY LOAD DEVELOPED DURING CONSTRUCTION.
- ALL SHOP AND WORKING DRAWING SUBMITTALS SHALL BE PREPARED BY THE CONTRACTOR TO INCORPORATE ALL REQUIREMENTS AND RESPONSIBILITIES OF THESE GENERAL NOTES.
- EXISTING FACILITIES OR WORK TO BE USED, IMPACTED OR OTHERWISE AFFECTED BY THE CONTRACTOR SHALL BE INSPECTED PRIOR TO STARTING WORK. IT SHALL BE THE RESPONSIBILITY OF THE CONTRACTOR TO REPAIR, MODIFY, UPGRADE, PROTECT, SUPPLEMENT OR SUPPORT EXISTING FACILITIES OR WORK TO OBTAIN THE DEGREE OF SERVICE REQUIRED BY THE CONTRACTOR TO PERFORM NEW WORK. THE CONTRACTOR SHALL RETURN EXISTING FACILITIES OR WORK TO ITS FUNCTIONAL EQUIVALENCY FOUND PRIOR TO THE START OF THE CONTRACTOR'S WORK TO THE SATISFACTION OF THE OWNER AND ENGINEER.
- NEW PIPING TO BE SUPPORTED IN ACCORDANCE WITH SPECIFICATION SECTIONS 40 05 24 AND 40 05 17. AS THIS IS AN EXISTING FACILITY ALL NEW PIPING AND ASSOCIATED SUPPORTS WILL BE NEED TO BE ADJUSTED TO AVOID CONFLICTS WITH EXISTING EQUIPMENT AND APPURTENANCES INCLUDING BUT NOT LIMITED TO PIPING, PIPING SUPPORTS, CONDUITS, LIGHTING. CONTRACTOR SHALL PROVIDE ADDITIONAL SUPPORTS AS NEEDED TO ADEQUATELY SUPPORT PIPING WHILE AVOIDING EXISTING CONFLICTS. EXISTING ITEMS MAY BE RELOCATED BY THE CONTRACTOR IF REQUIRED AND APPROVED BY ENGINEER AND COORDINATED WITH THE OWNER. COSTS FOR ALL SUPPORTS AND RELOCATIONS SHALL BE INCLUDED IN THE CONTRACTORS BASE BID.
- ALL COSTS ASSOCIATED WITH COMPLIANCE WITH THESE GENERAL NOTES SHALL BE INCLUDED IN THE VARIOUS CONTRACT ITEMS AND NO SEPARATE PAYMENT WILL BE MADE THEREFORE.
- ALL MATERIALS IN CONTACT WITH POTABLE WATER SHALL BE CERTIFIED ACCORDING TO NSF 61 AND NSF 372, INCLUDING BUT NOT LIMITED TO PROTECTIVE BARRIER MATERIALS (CEMENTS, PAINTS, COATINGS), JOINING AND SEALING MATERIALS (GASKETS, ADHESIVES, LUBRICANTS), MECHANICAL DEVICES (WATER METERS, VALVES, FILTERS), PIPES AND RELATED PRODUCTS (PIPE, HOSE, FITTINGS), PLUMBING DEVICES (FAUCETS, DRINKING FOUNTAINS), PROCESS MEDIA (FILTER MEDIA, ION EXCHANGE RESINS), AND NON-METALLIC POTABLE WATER MATERIALS.
- CONTRACTOR MAY CHOOSE TO UTILIZE A CRANE TO LOAD PUMPS AND OTHER MATERIALS INTO THE BUILDING THROUGH A FRONT WINDOW OF THE HIGH-SERVICE PUMP AREAS. CONTRACTOR IS RESPONSIBLE FOR REMOVAL AND REINSTALLATION OF WINDOW. CONTRACTOR SHALL RESTORE WINDOW AND LANDSCAPING TO ORIGINAL CONDITION. CONTRACTOR TO VERIFY ALL DISTANCES. DISTANCE FROM WALK TO FACE OF BUILDING IS APPROXIMATELY 37 FEET.

DRAWING PATH: \\ohm\dfs\corporate\Projects\0000_01000002019\040_wtr_design_services\Drawings\facilities\90040P-001.dwg Dec. 16, 2019 - 11:50am


MISCELLANEOUS SYMBOLS

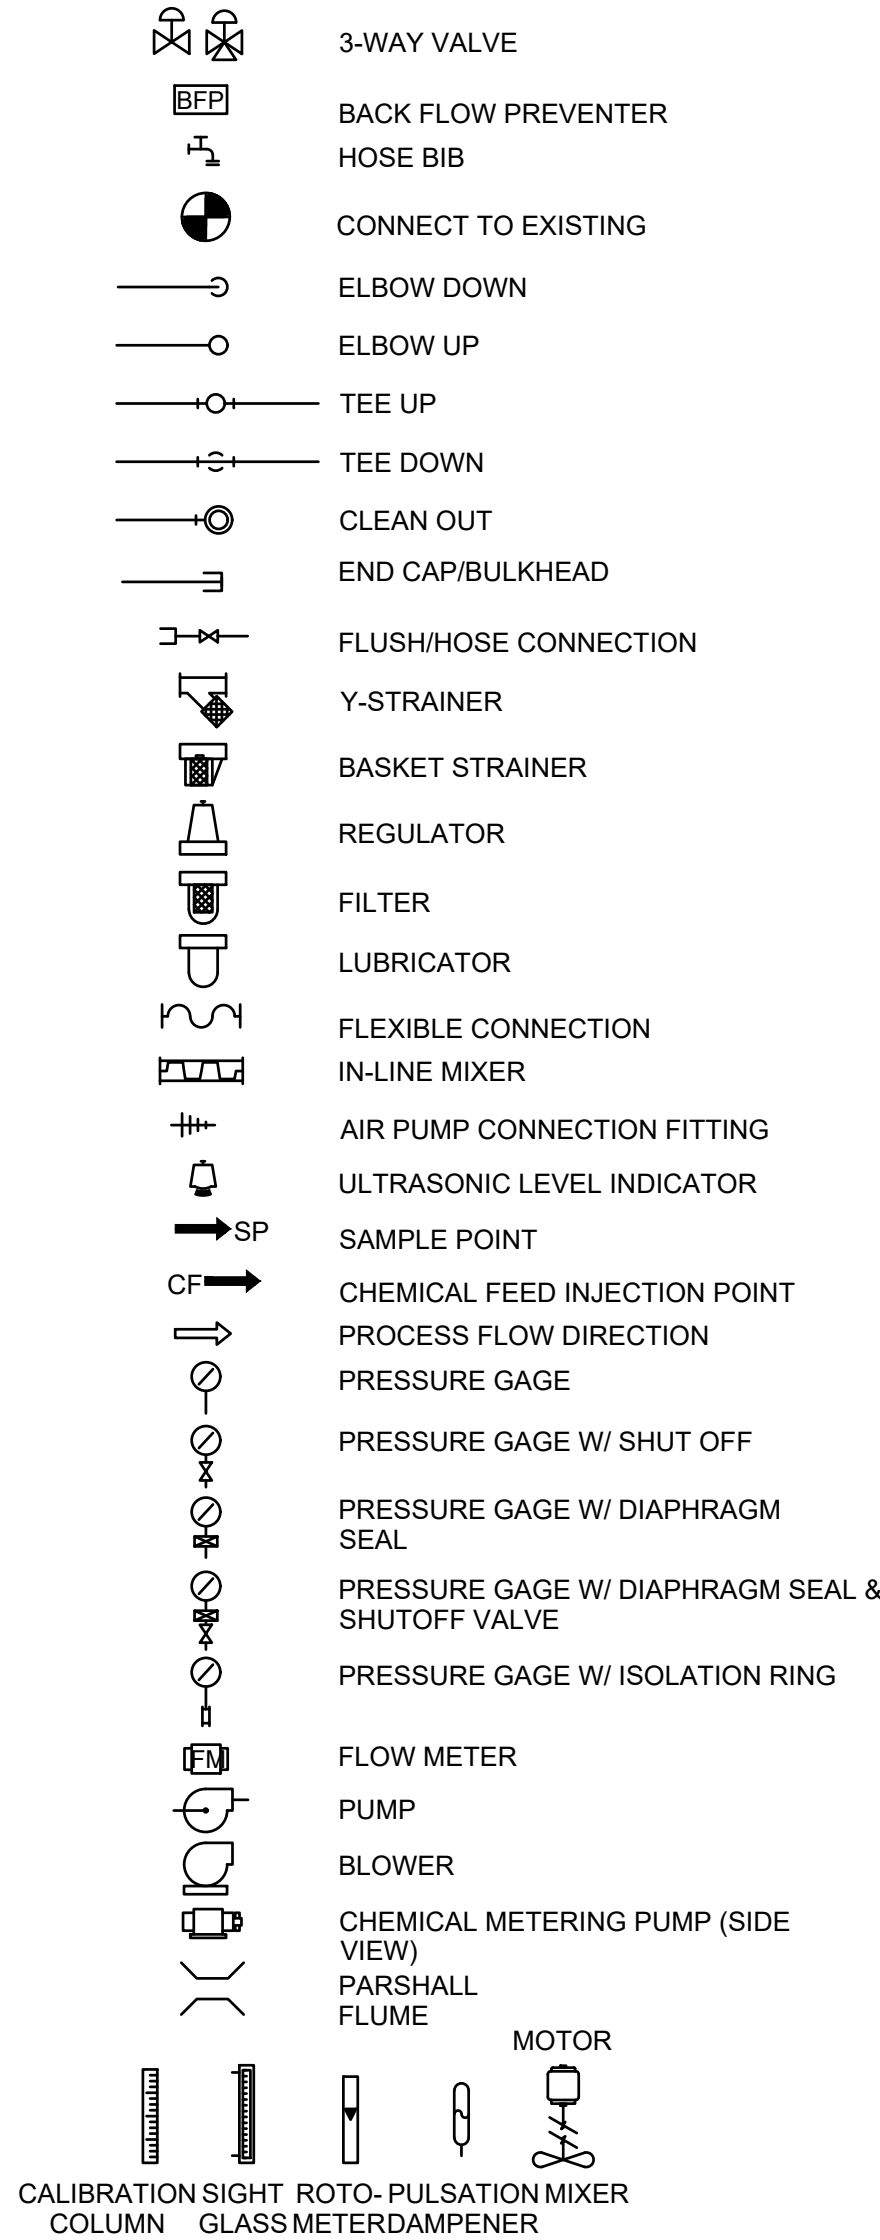


PIPE SERVICE TYPE (SCHEMATIC ONLY)

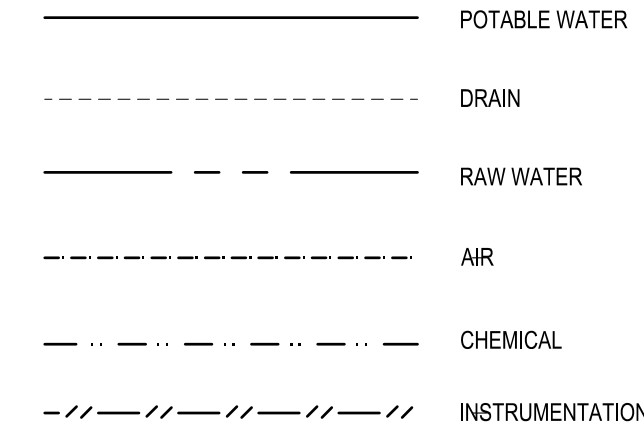


VALVE AND GATE TAG

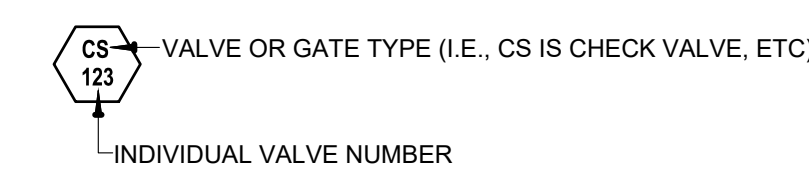


PIPE IDENTIFICATION

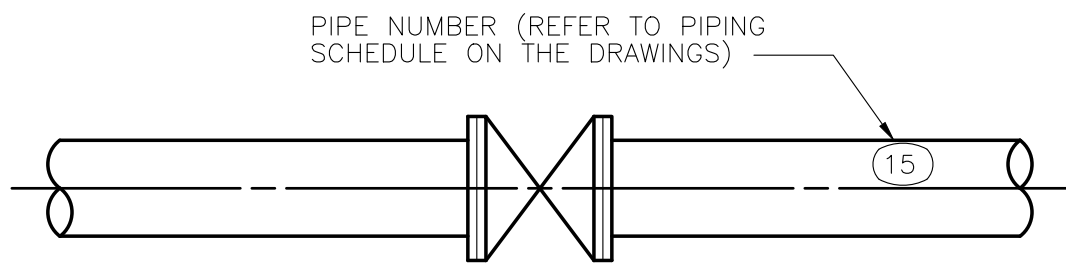


VALVE DESIGNATIONS

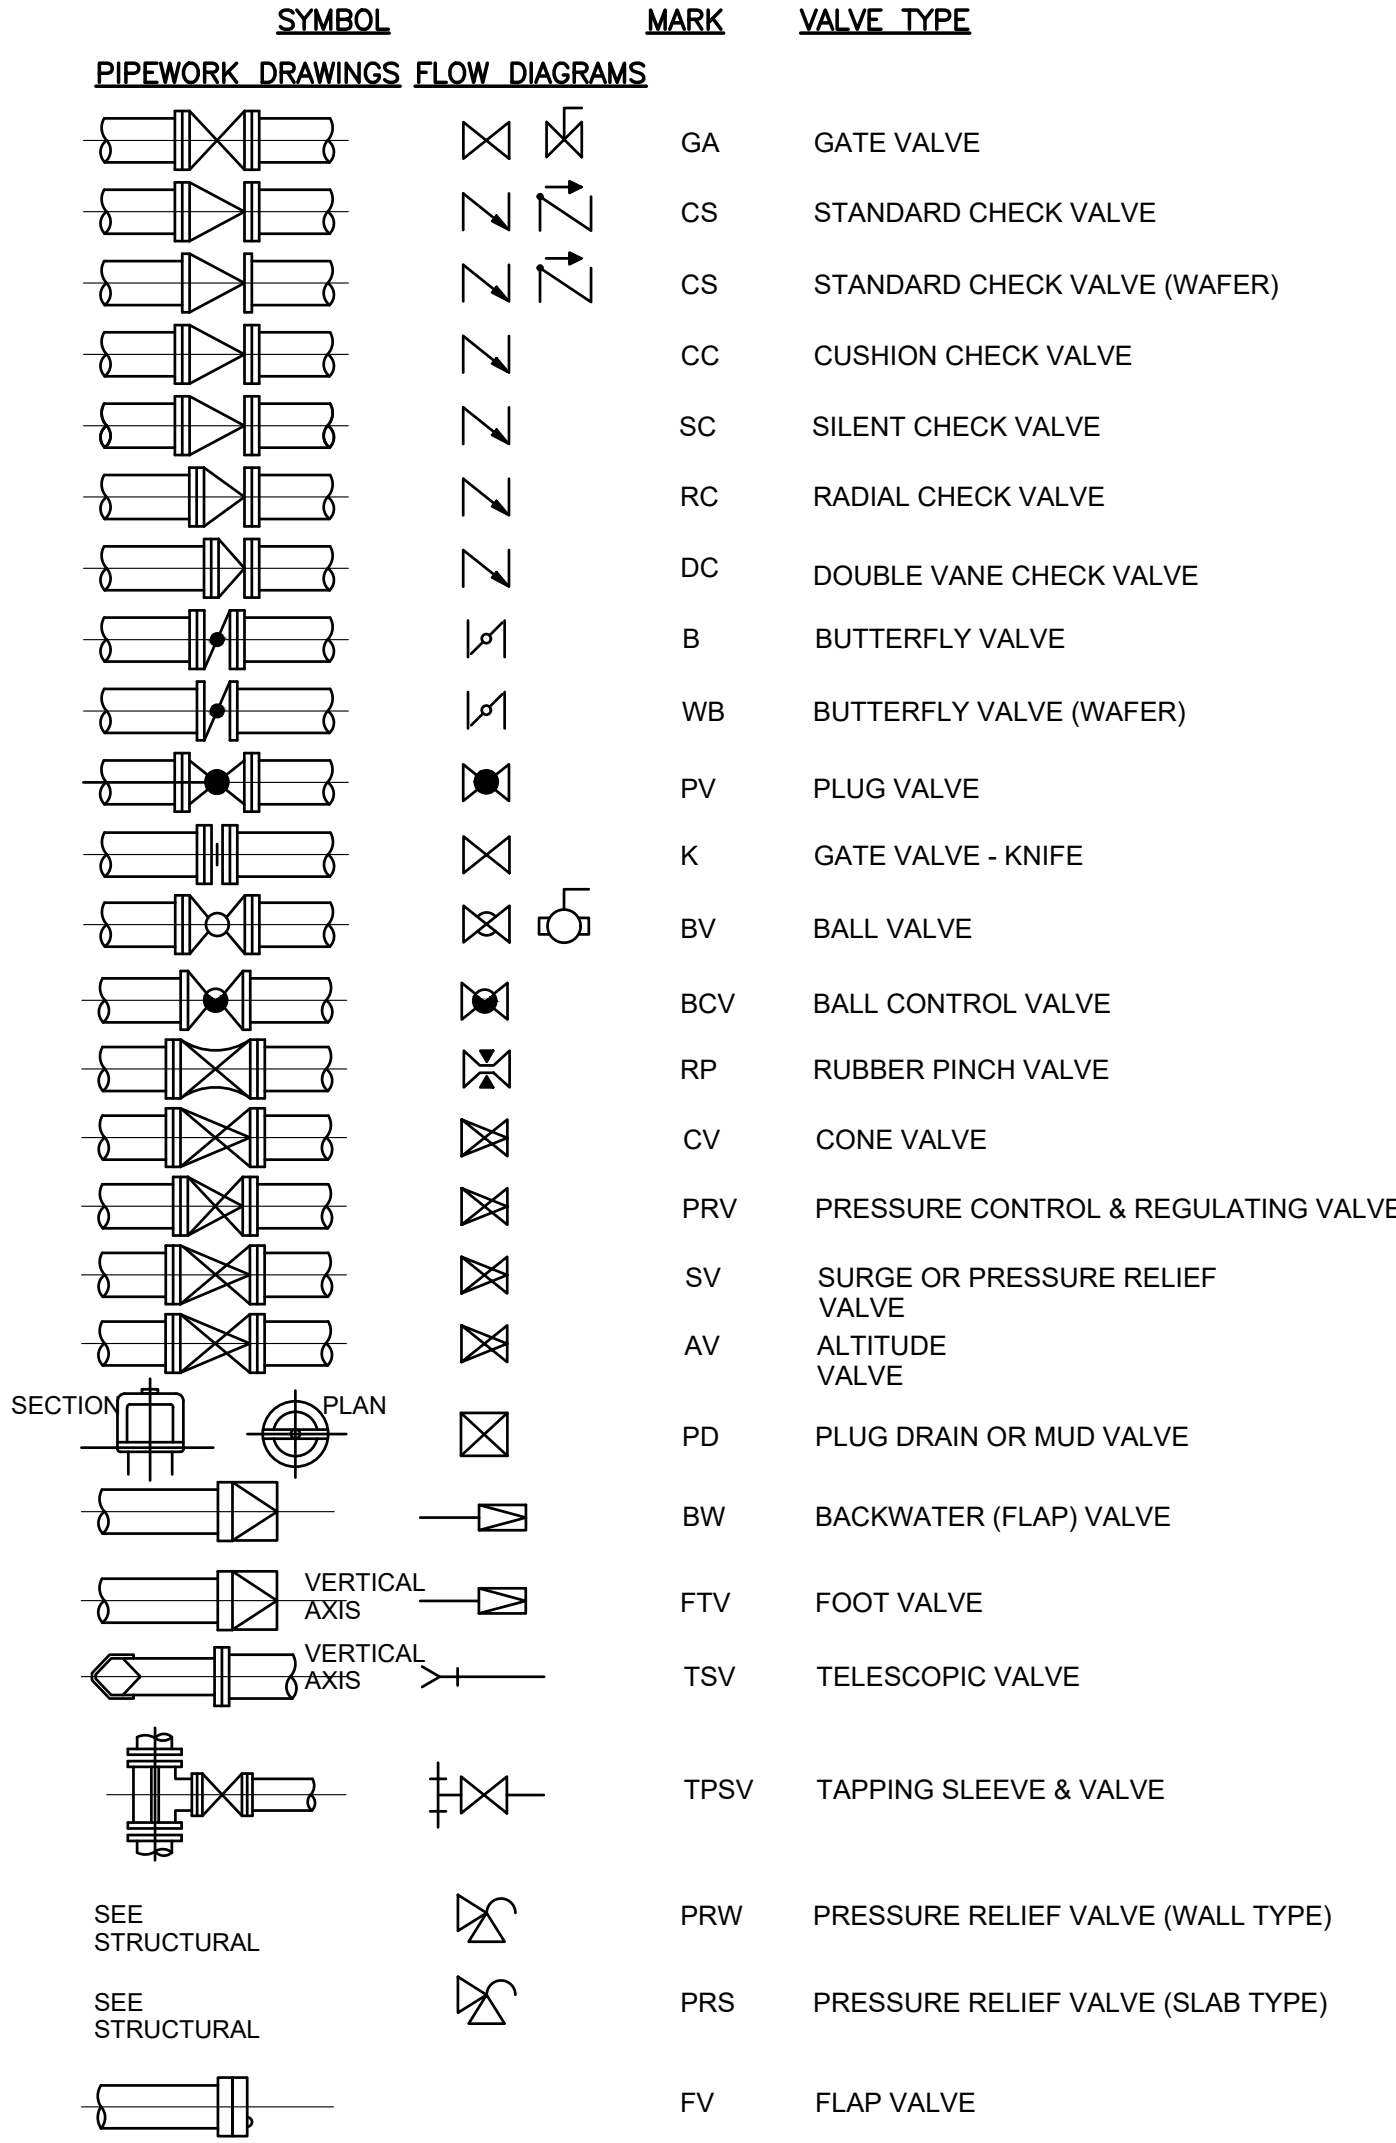


PIPE JOINT DESIGNATIONS

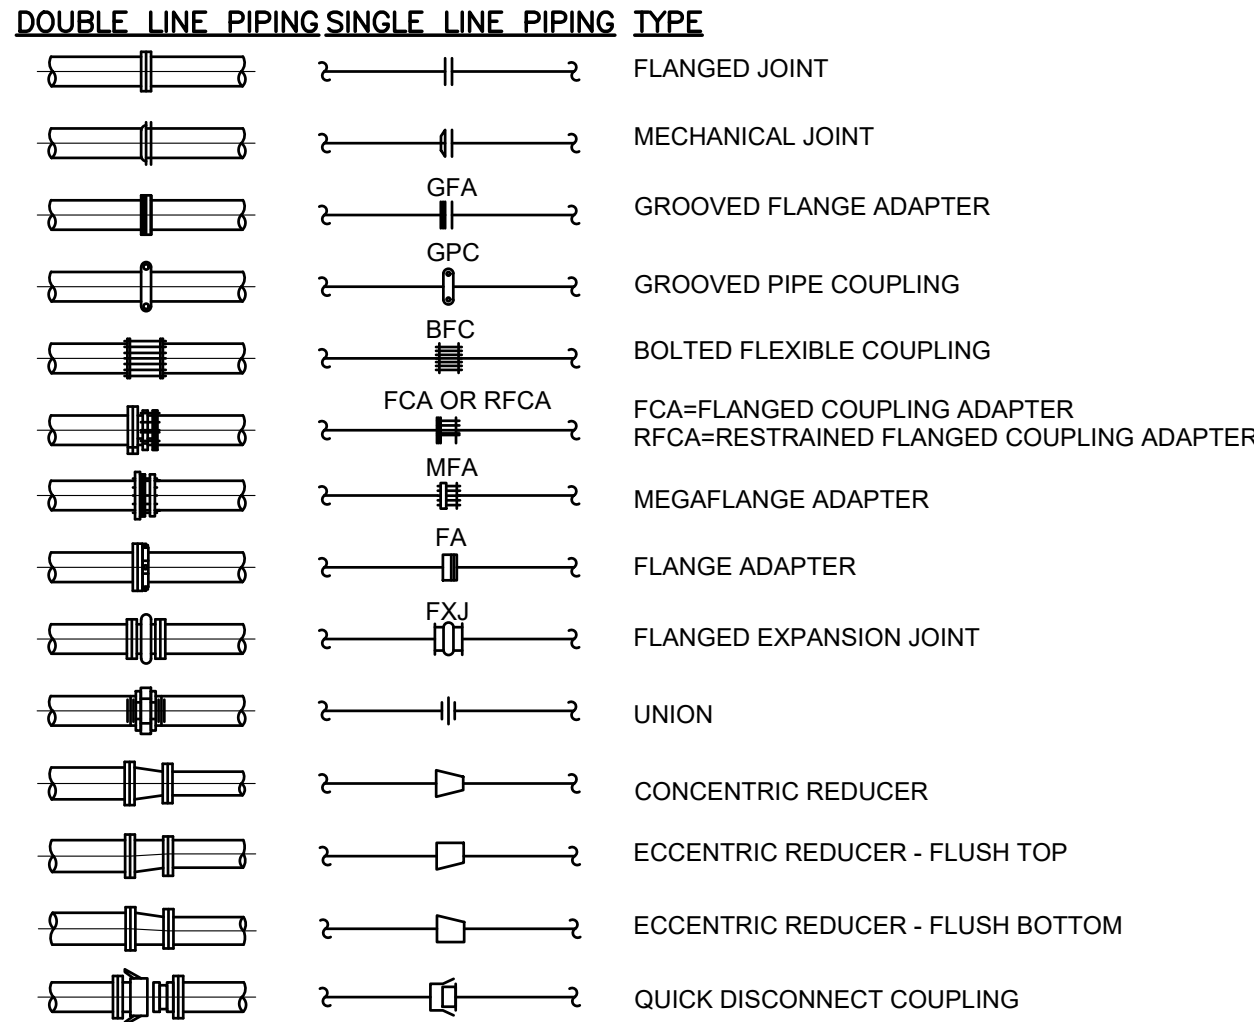

EQUIPMENT TAG

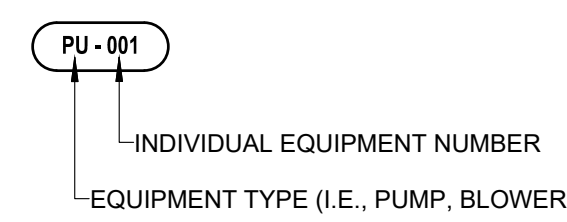

DRAWING PATH: \\ohm\dfs\corporate\Projects\0000_01\001\002\0190040_wfp_design_services\Drawings\Facilities\Sheet\190040P-01.dwg Dec 16, 2019 - 11:59am

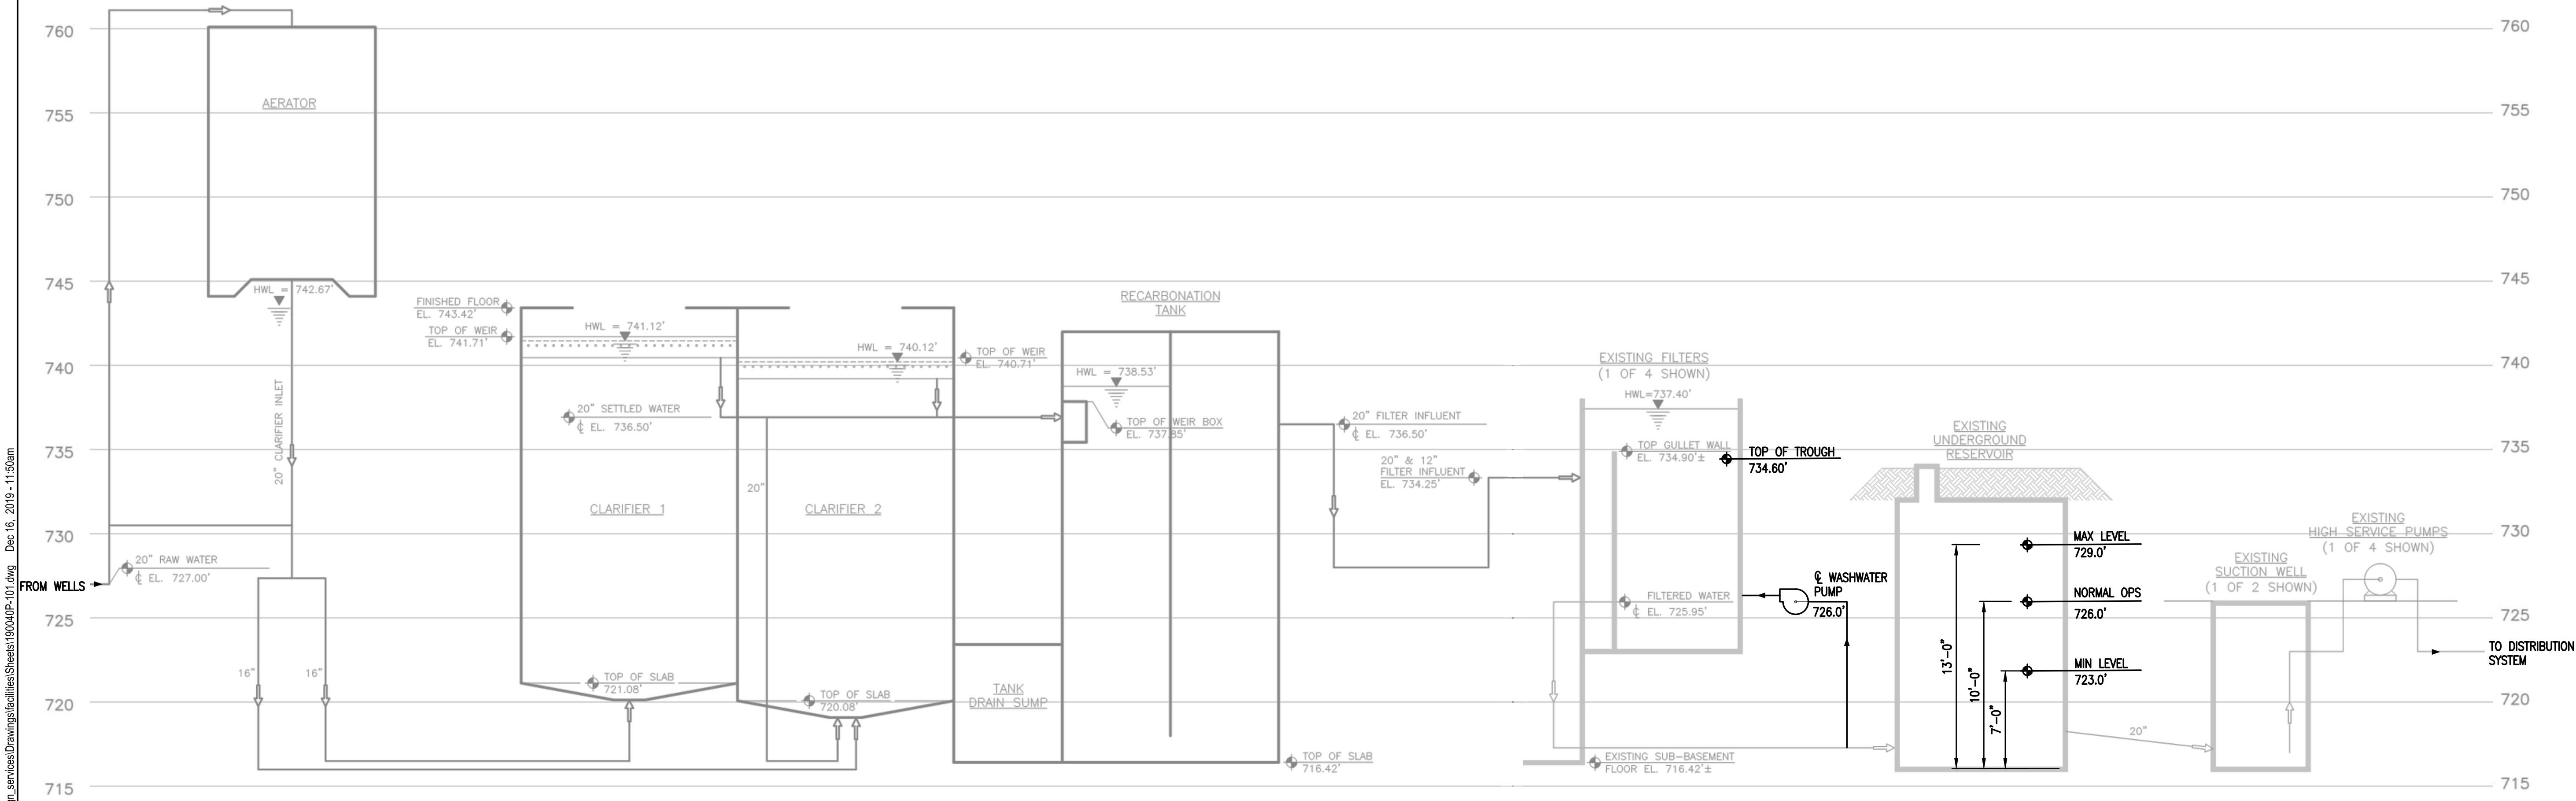

HYDRAULIC PROFILE
VERTICAL: 1" = 5'-0"
HORIZONTAL: NO SCALE

NOTE:
1. HIGH WATER LEVELS (HWL) CALCULATED AT 6 MGD WITH PARALLEL FLOW THROUGH CLARIFIERS AND ONE FILTER IN BACKWASH.
2. THIS DRAWING WAS ORIGINALLY PRODUCED BY FTH&C FOR OWOSSO UNDER CONTRACT 01299CD EXISTING INFORMATION (LIGHT LINE WORK) HAS NOT BEEN VERIFIED.



ARCHITECTS ENGINEERS PLANNERS

34000 Plymouth Road
Livonia, MI 48150
P (734) 522-6711 | F (734) 522-6427

OHM-ADVISORS.COM

REVISIONS:

ISSUED FOR BIDS	12/16/2019

DATE	PROJ NUMBER	ENG	PROJ MGR	JD	CADD	COUNTY	CITY/VILAGE/TOWNSHIP	SCALE	H	NTS	V	NTS	HORIZ DATUM	VERT DATUM
	002019-0040	MK			LM	SHAWASSEE	OWOSSO						N/A	N/A

CITY OF OWOSSO

WASH WATER PUMP & PIPING REPLACEMENT


HYDRAULIC PROFILE

SHEET

P-101

COPYRIGHT 2016 OHM ALL DRAWINGS AND WRITTEN MATERIALS APPEARING HEREIN CONSTITUTE THE ORIGINAL AND UNPUBLISHED WORK OF OHM AND THE SAME MAY NOT BE DUPLICATED, DISTRIBUTED, OR DISCLOSED WITHOUT PRIOR WRITTEN CONSENT OF OHM

DRAWING PATH: \\omh\corporate\Projects\0000_0100\0020190400_wfp_design_services\Drawings\Facilities\0004UP-01.dwg Dec 16, 2019 - 11:50am

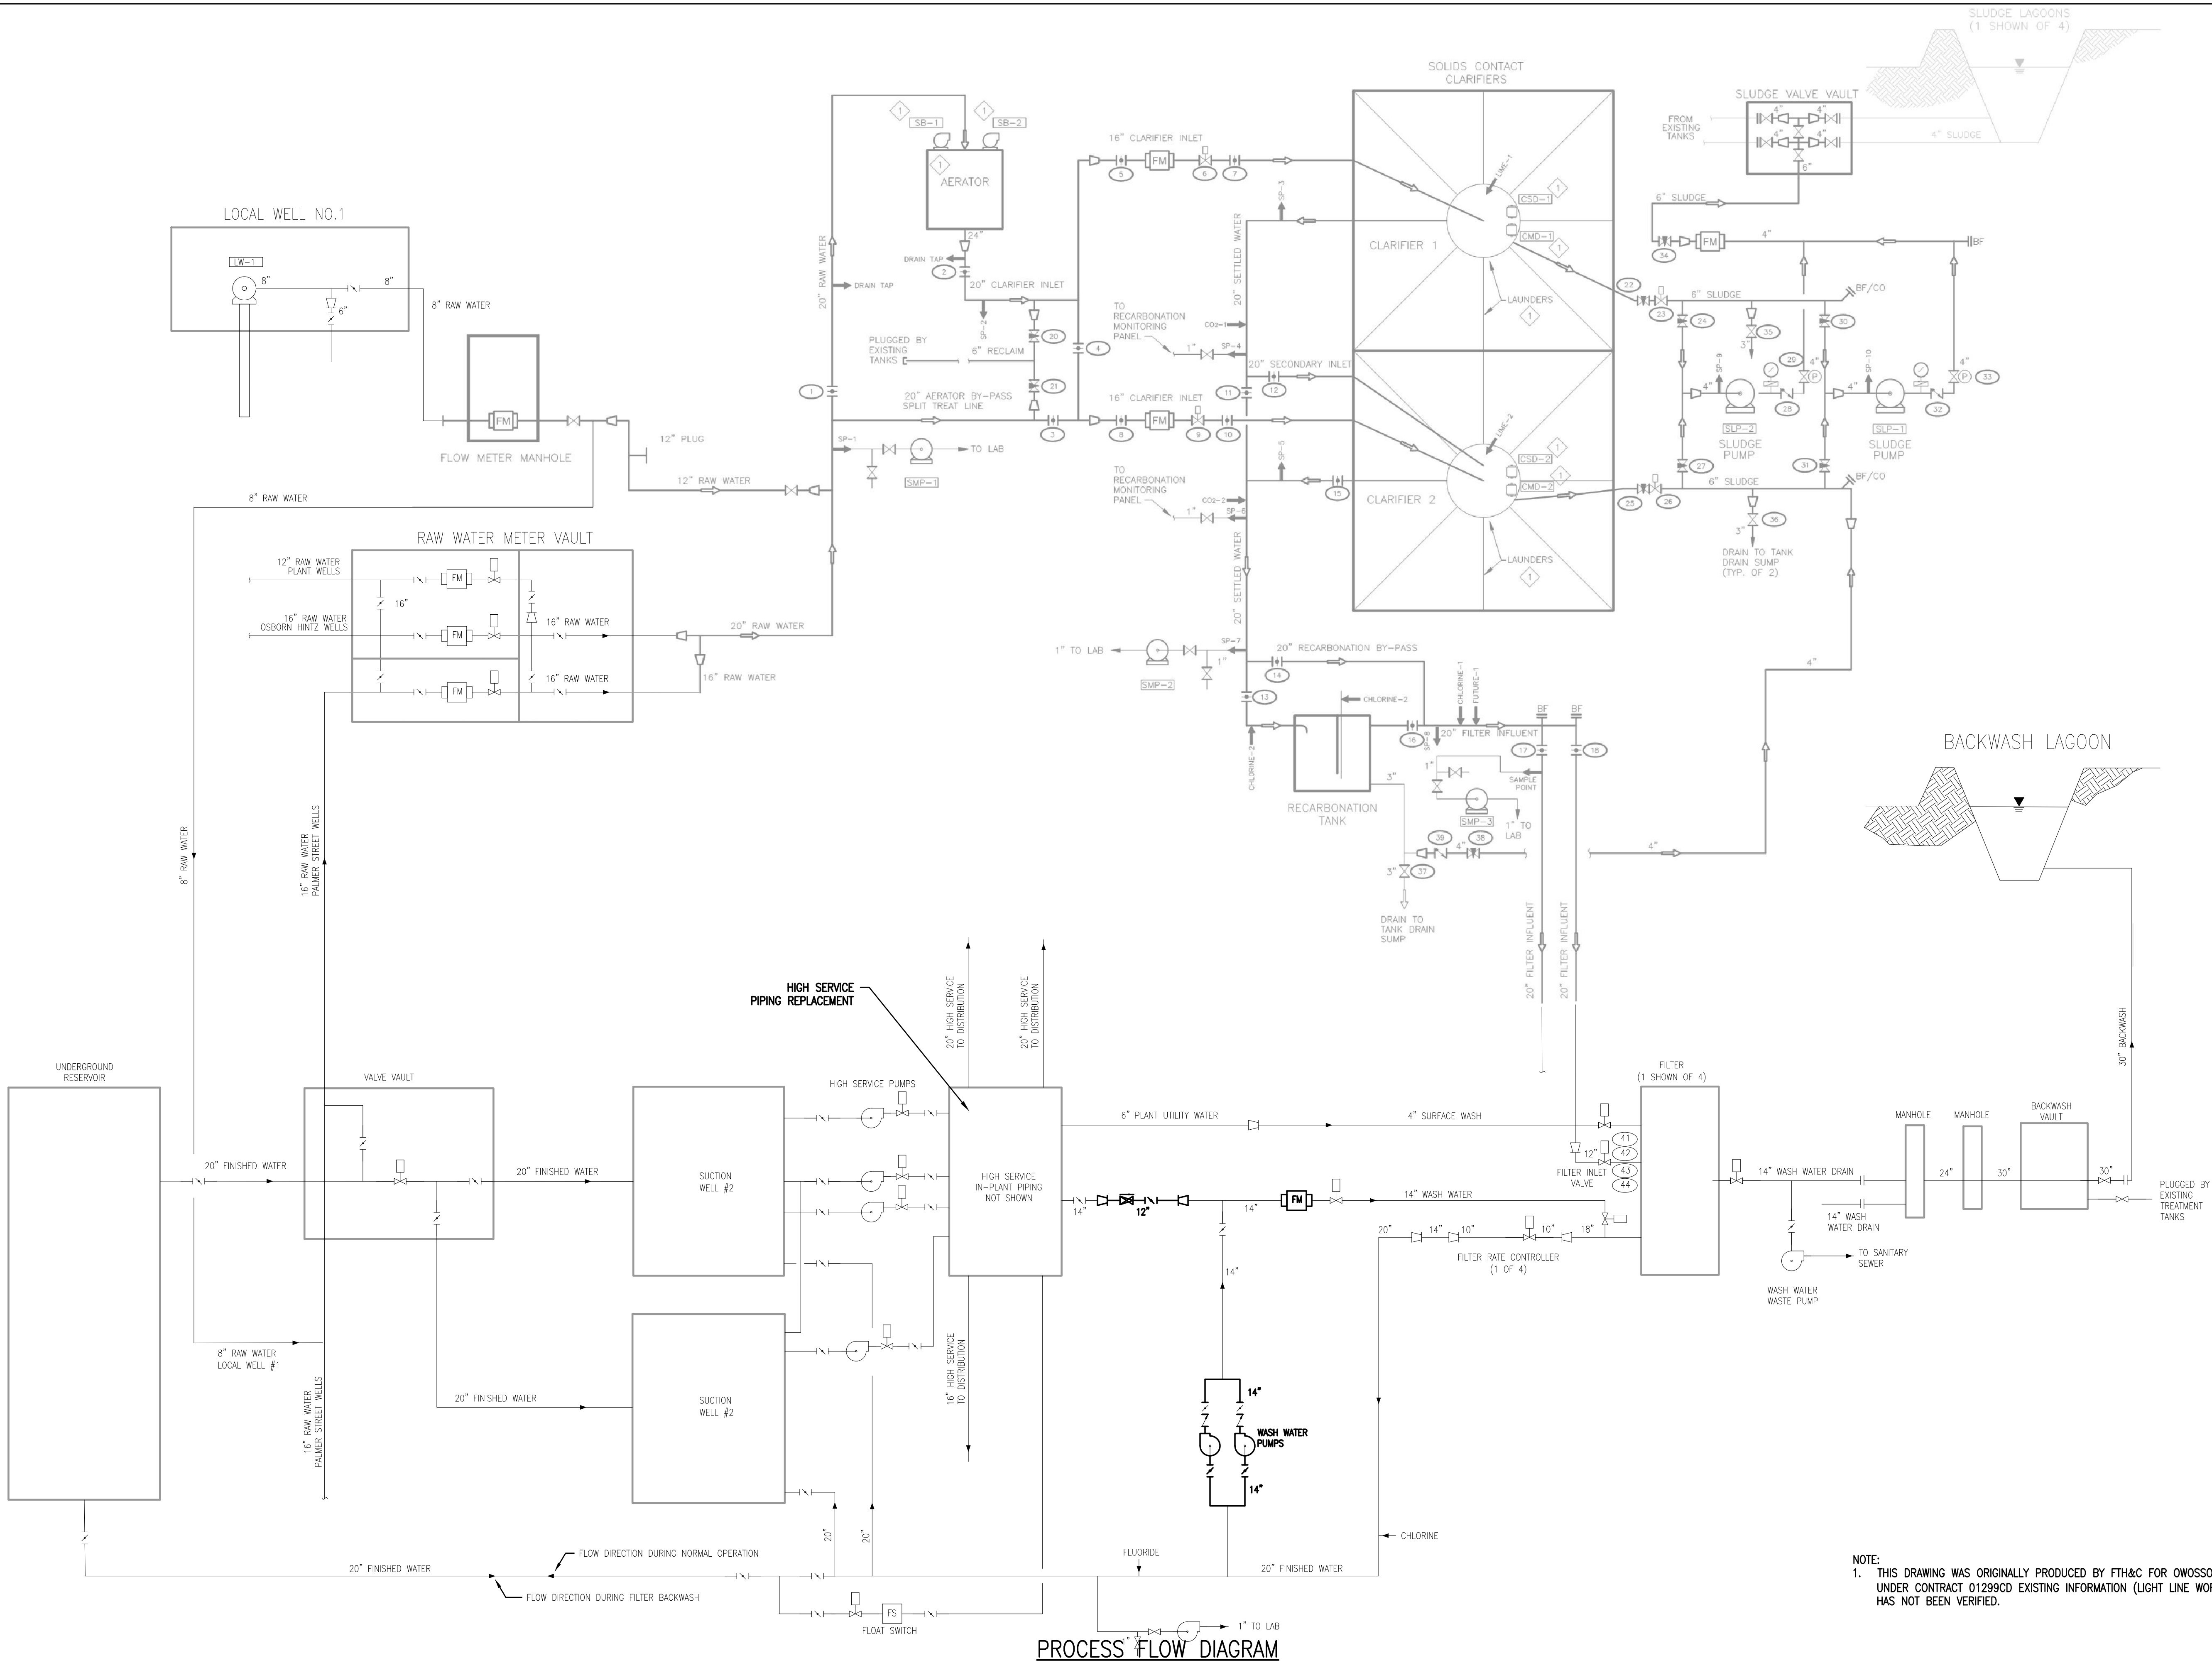


NOTE:
1. THIS DRAWING WAS ORIGINALLY PRODUCED BY FTH&C FOR OWOSSO UNDER CONTRACT 01299CD EXISTING INFORMATION (LIGHT LINE WORK) HAS NOT BEEN VERIFIED.


REVISIONS:	12/16/2019
ISSUED FOR BIDS	12/16/2019

DATE	PROJ NUMBER	ENG	PROJ MGR	CADD	COUNTY	CITY/VILLAGE/TOWNSHIP	SCALE	H	V	NTS	VERT DATUM	NO
02/23/2020	0023-19-0400	MK	JD	LM	SHAWANSEE	OWOSSO	1" = 10'	1"	1"	1"	1"	1"


CITY OF OWOSSO
WASH WATER PUMP & PIPING REPLACEMENT
PROCESS FLOW DIAGRAM

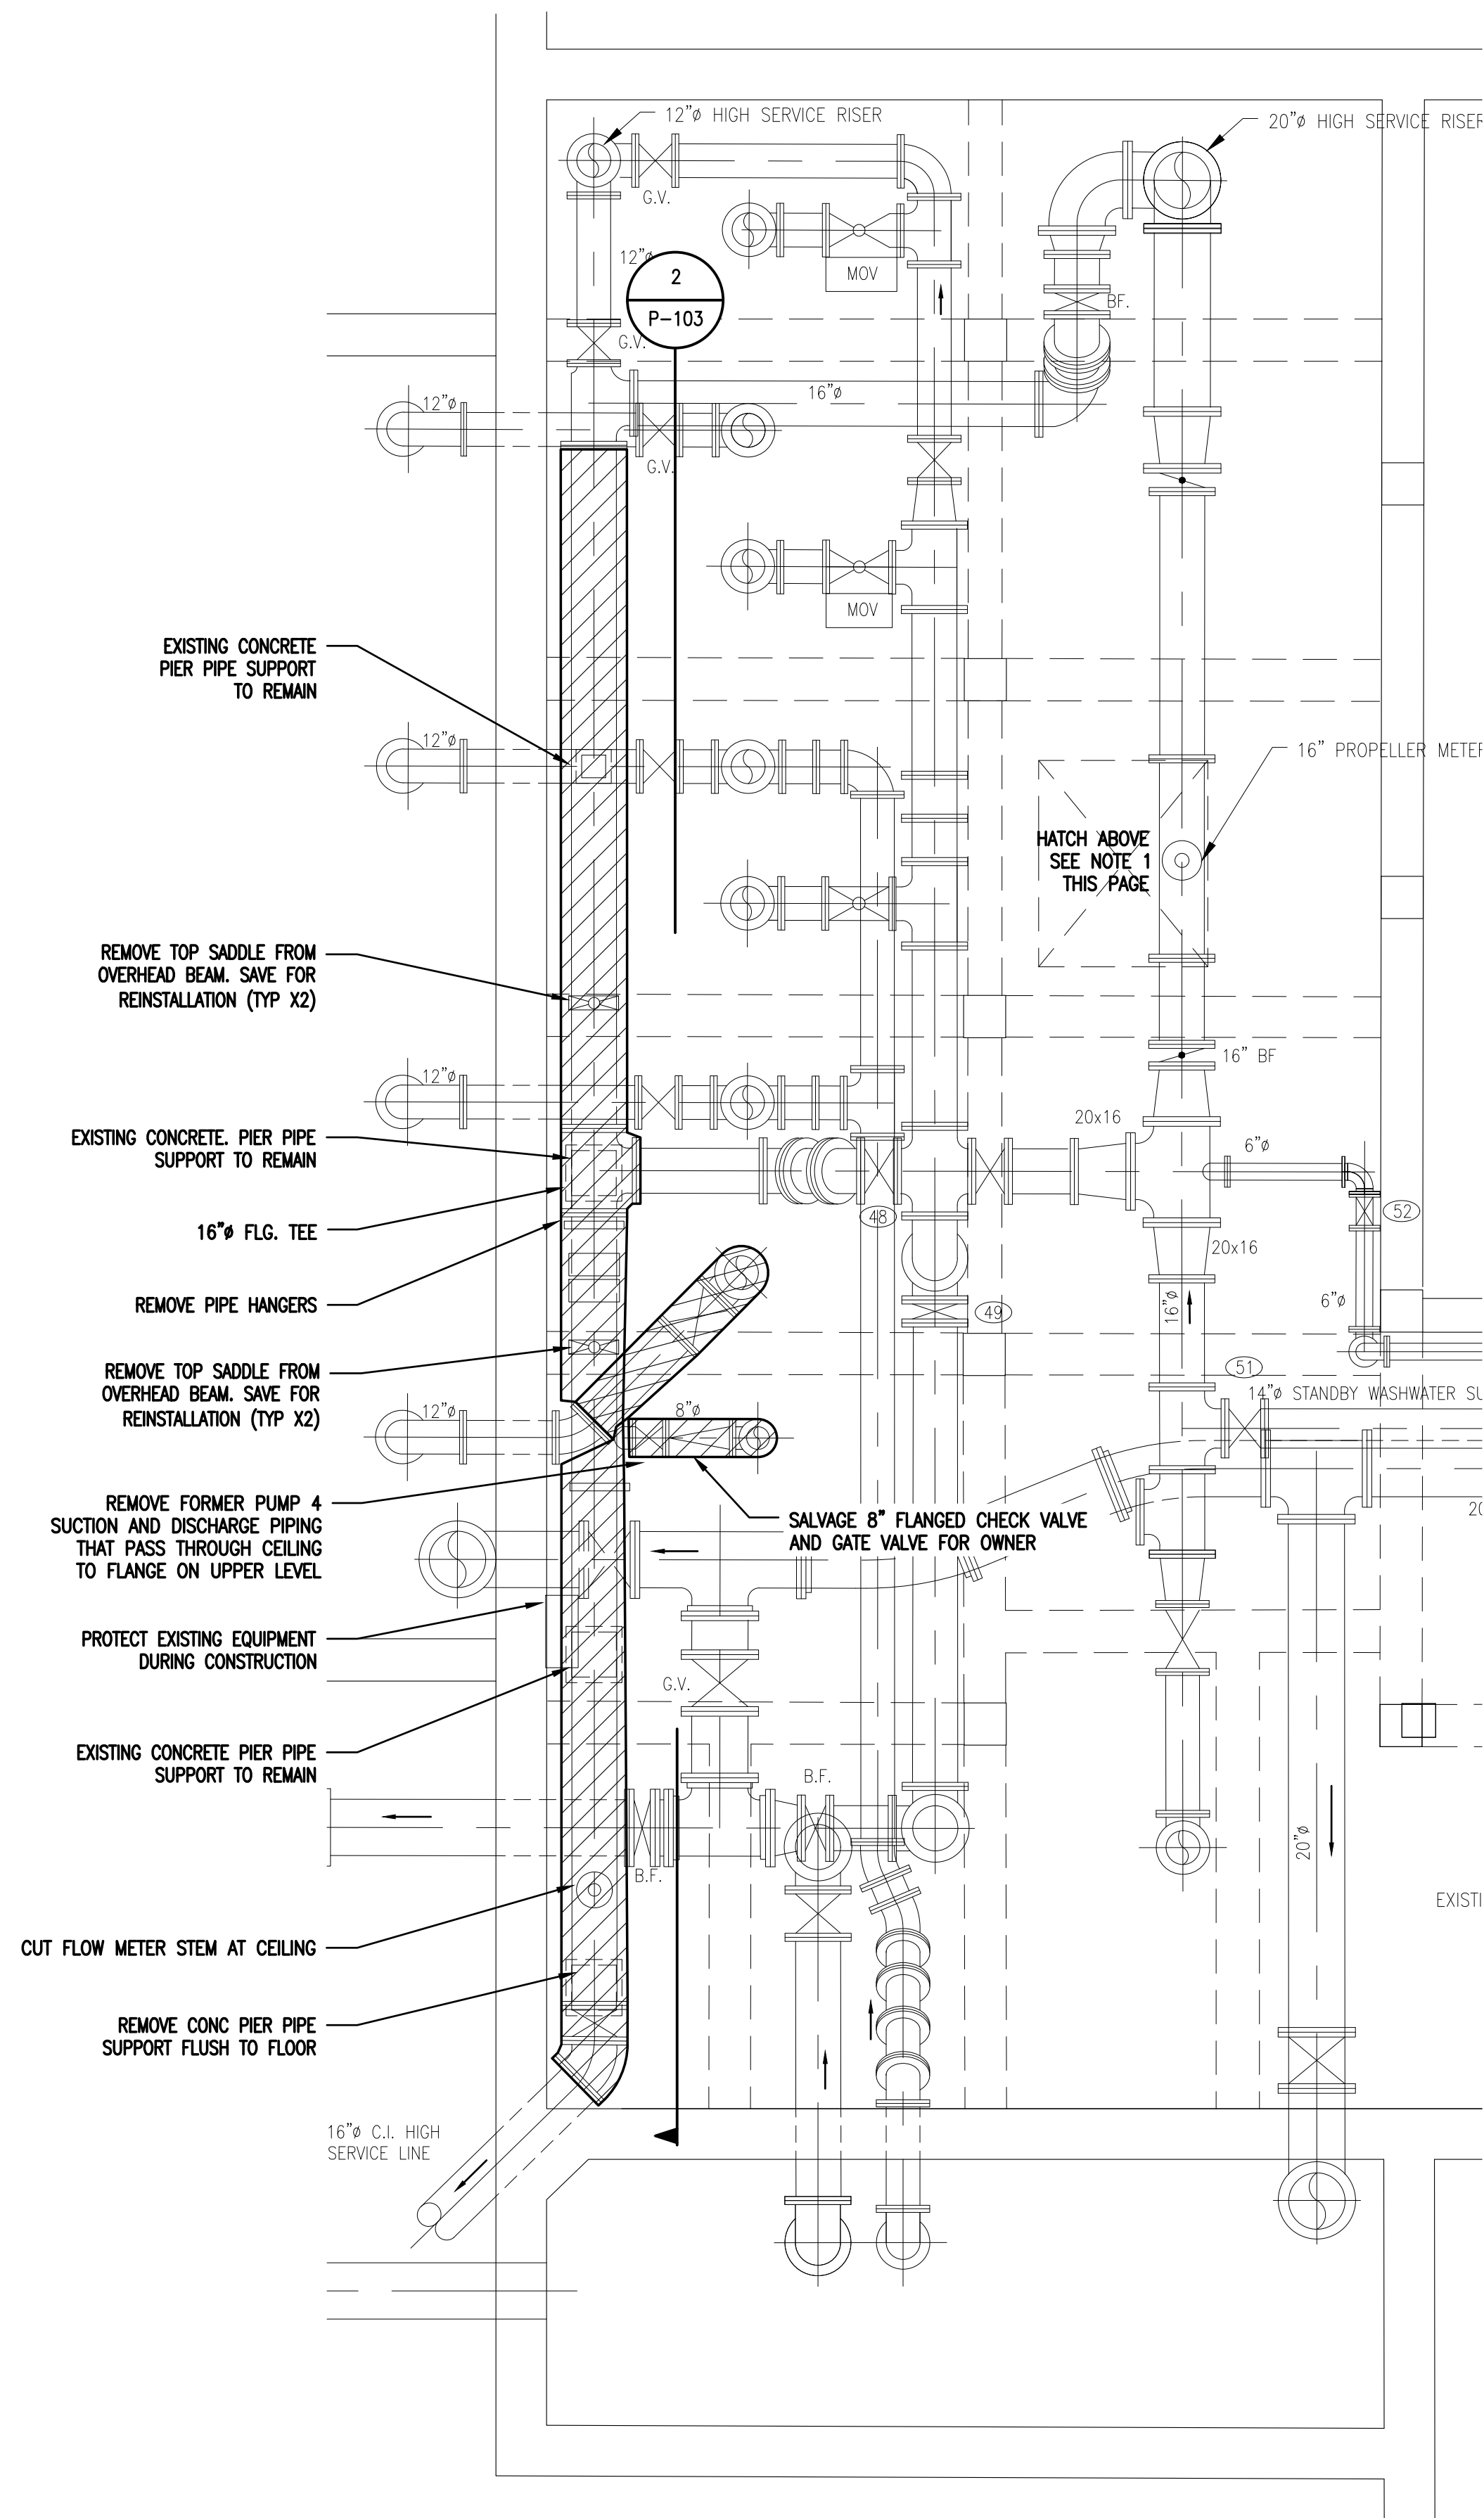


1 HIGH SERVICE PIPE PLAN - DEMOLITION

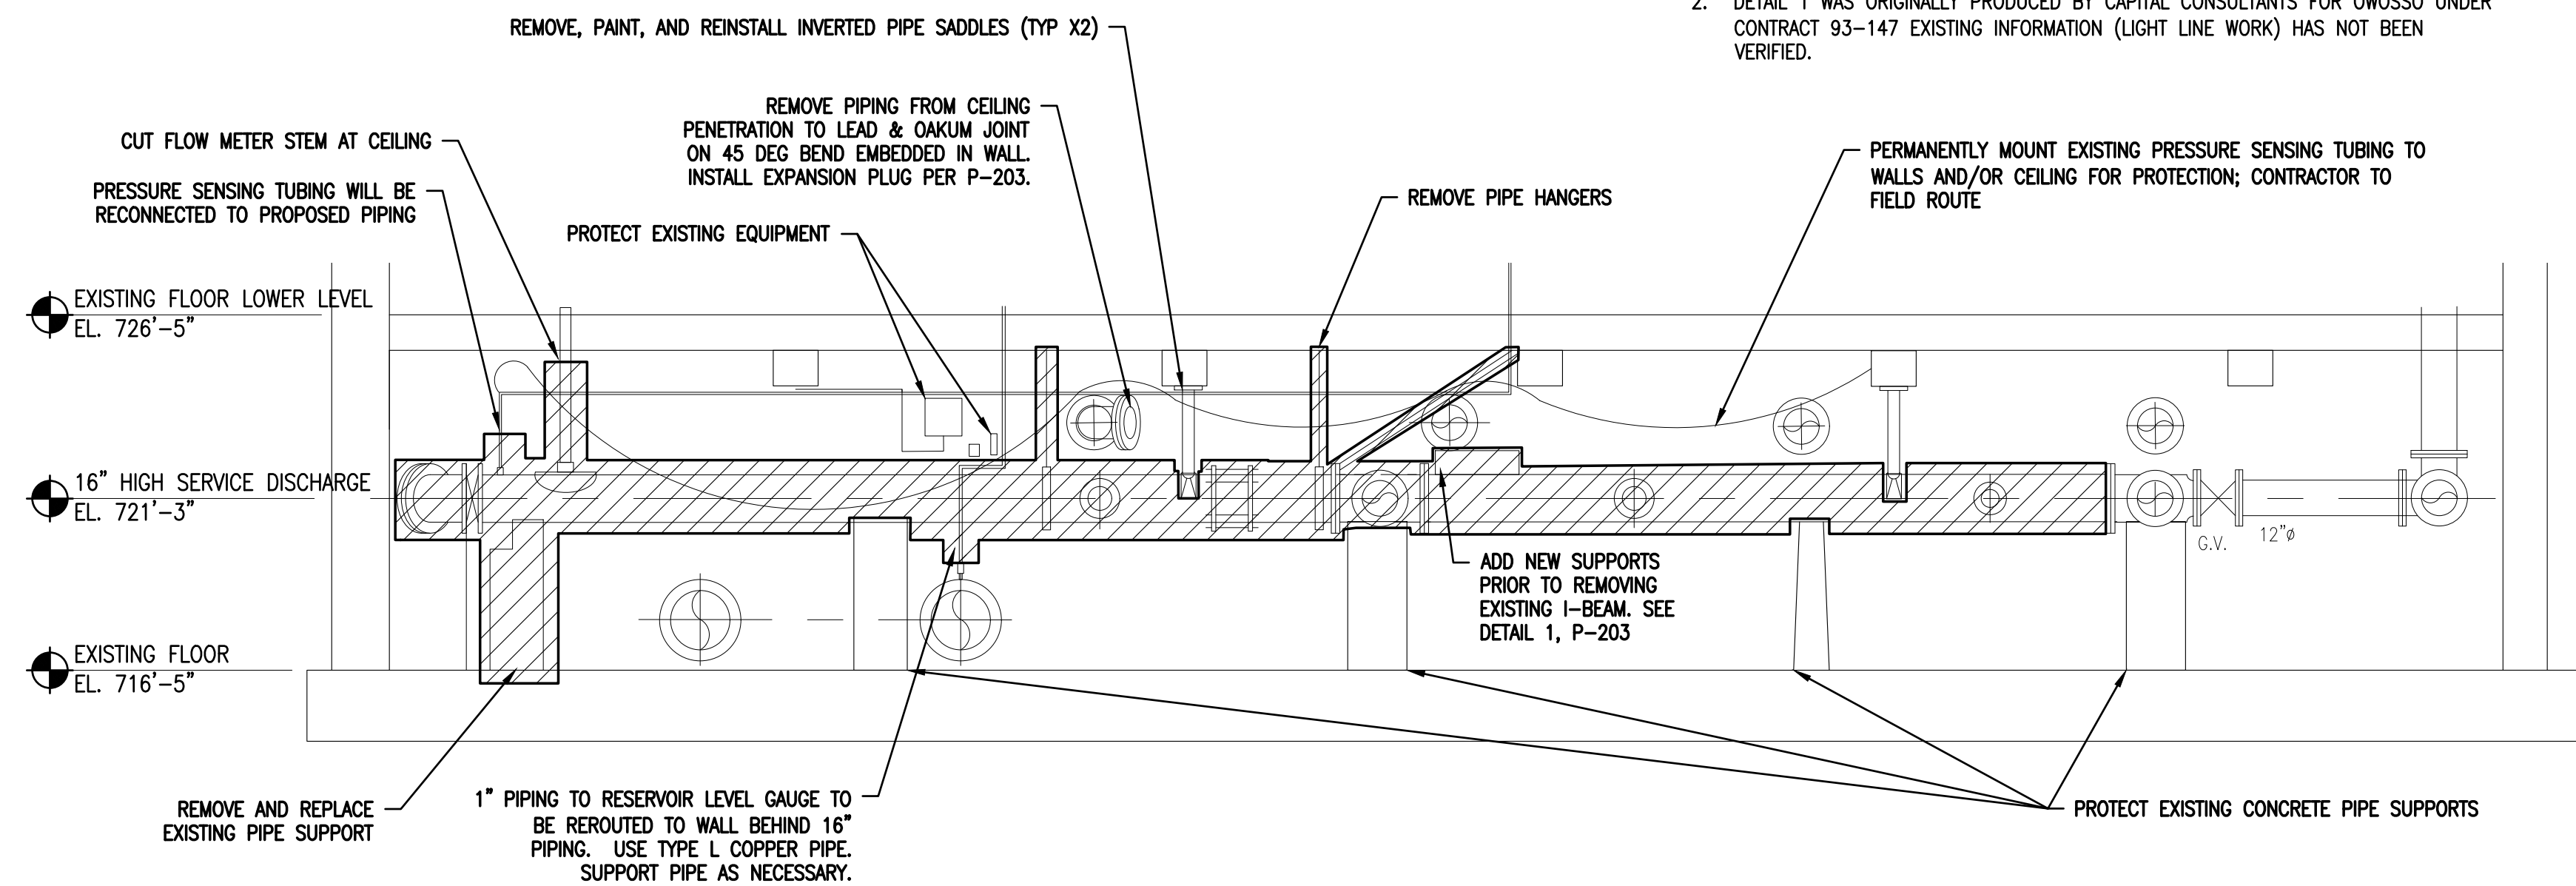

② HIGH SERVICE PIPE SECTION - DEMOLITION
1/4" = 1'-0"







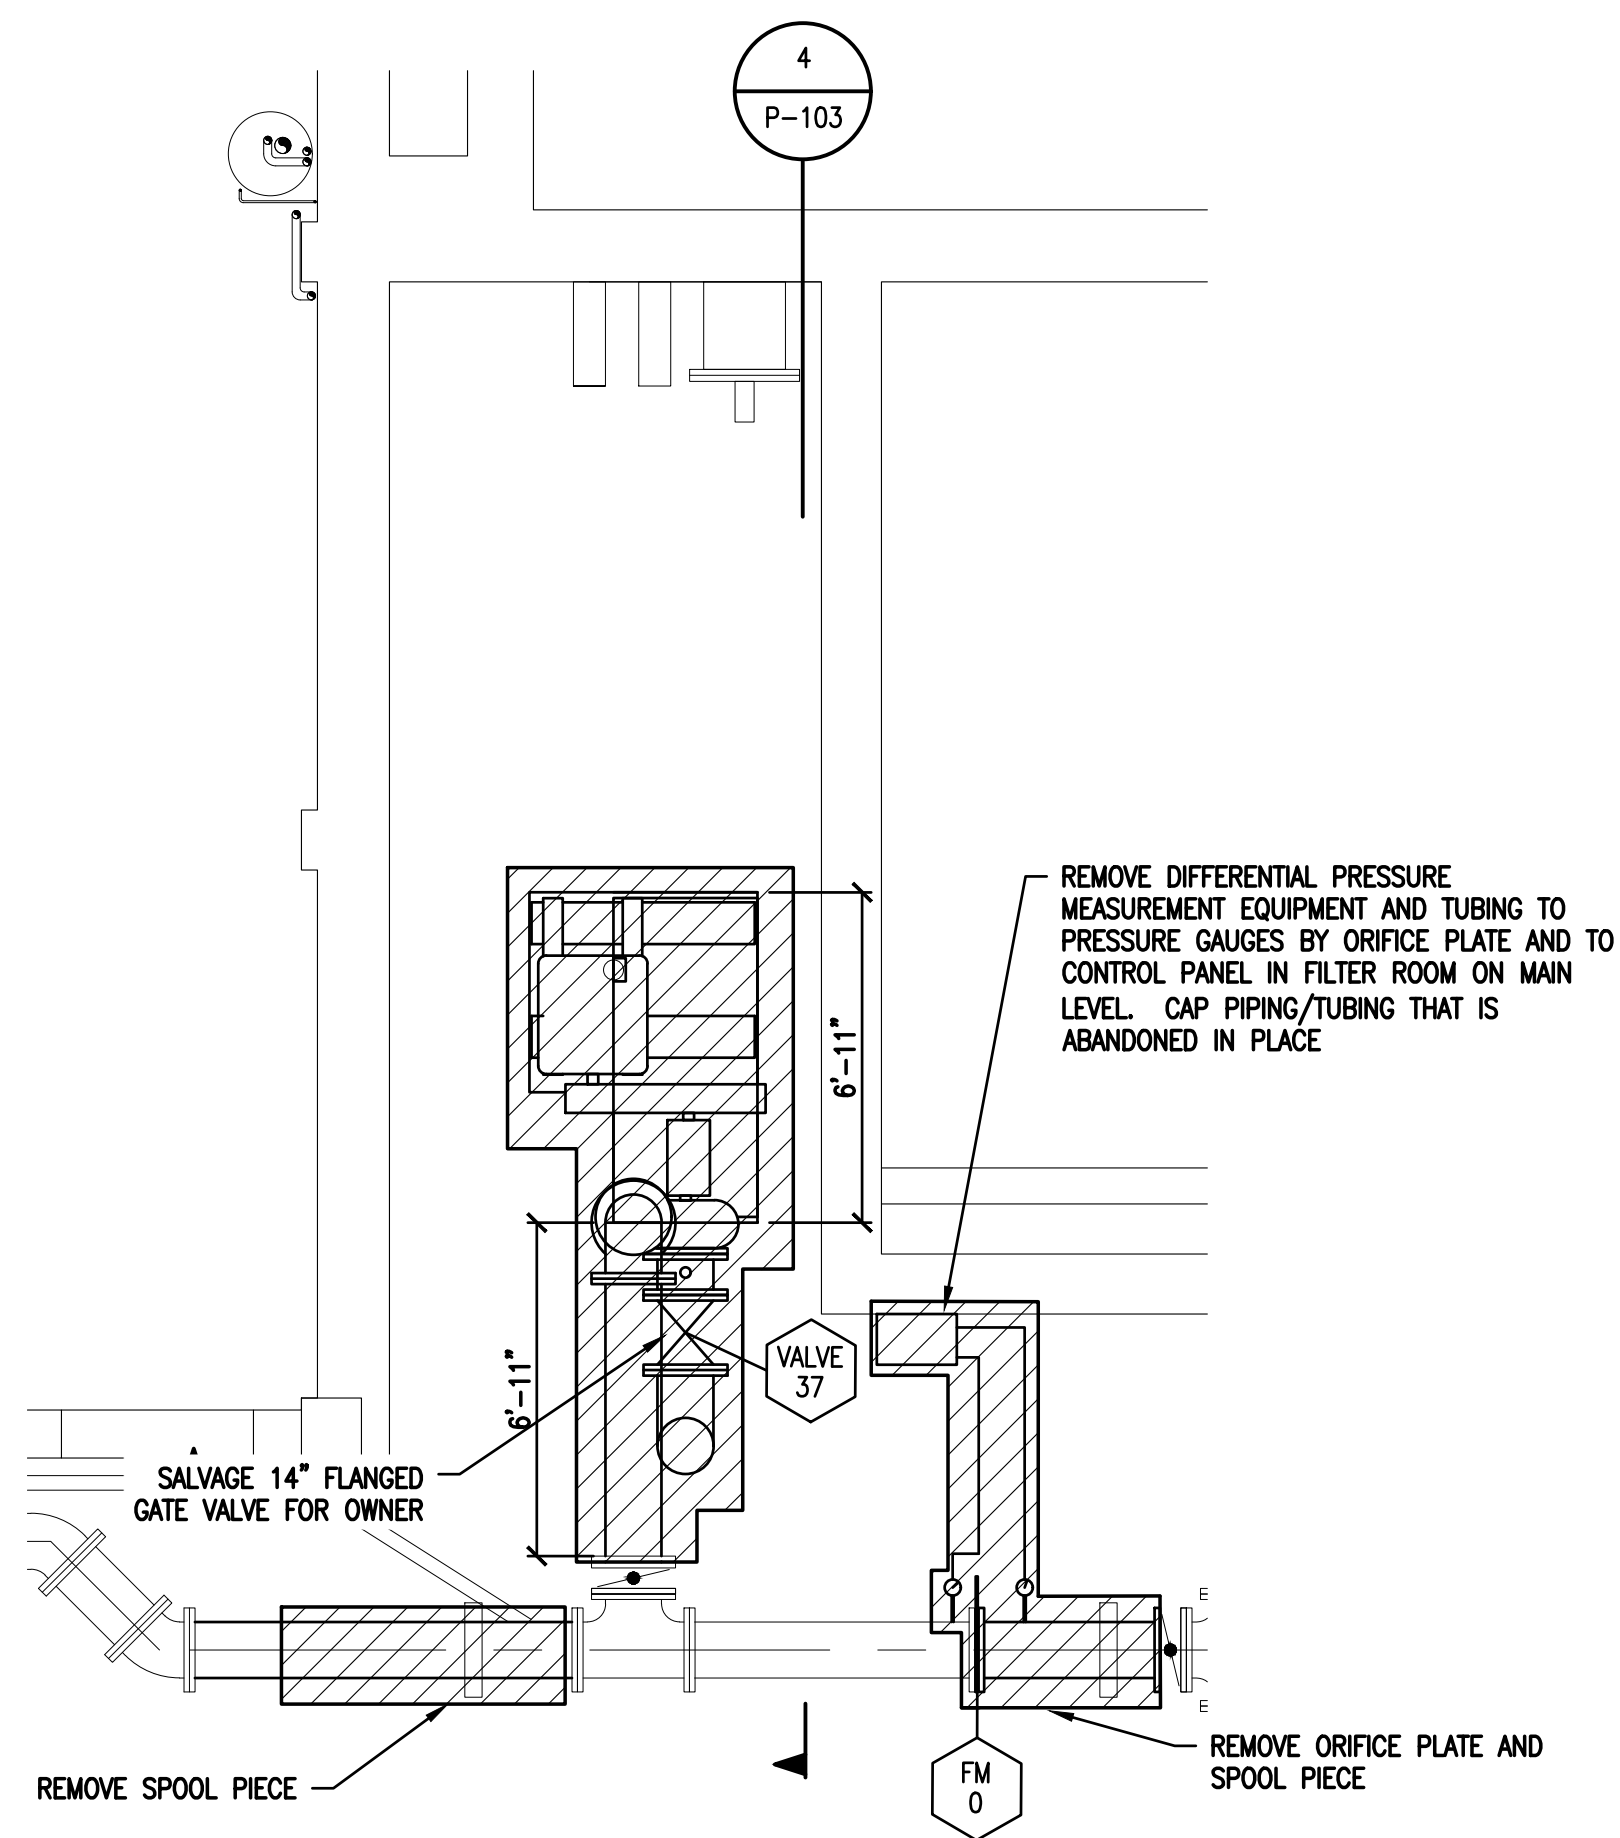


3 EXISTING PUMP DEMO PLANVIEW
1/4" = 1'-0"

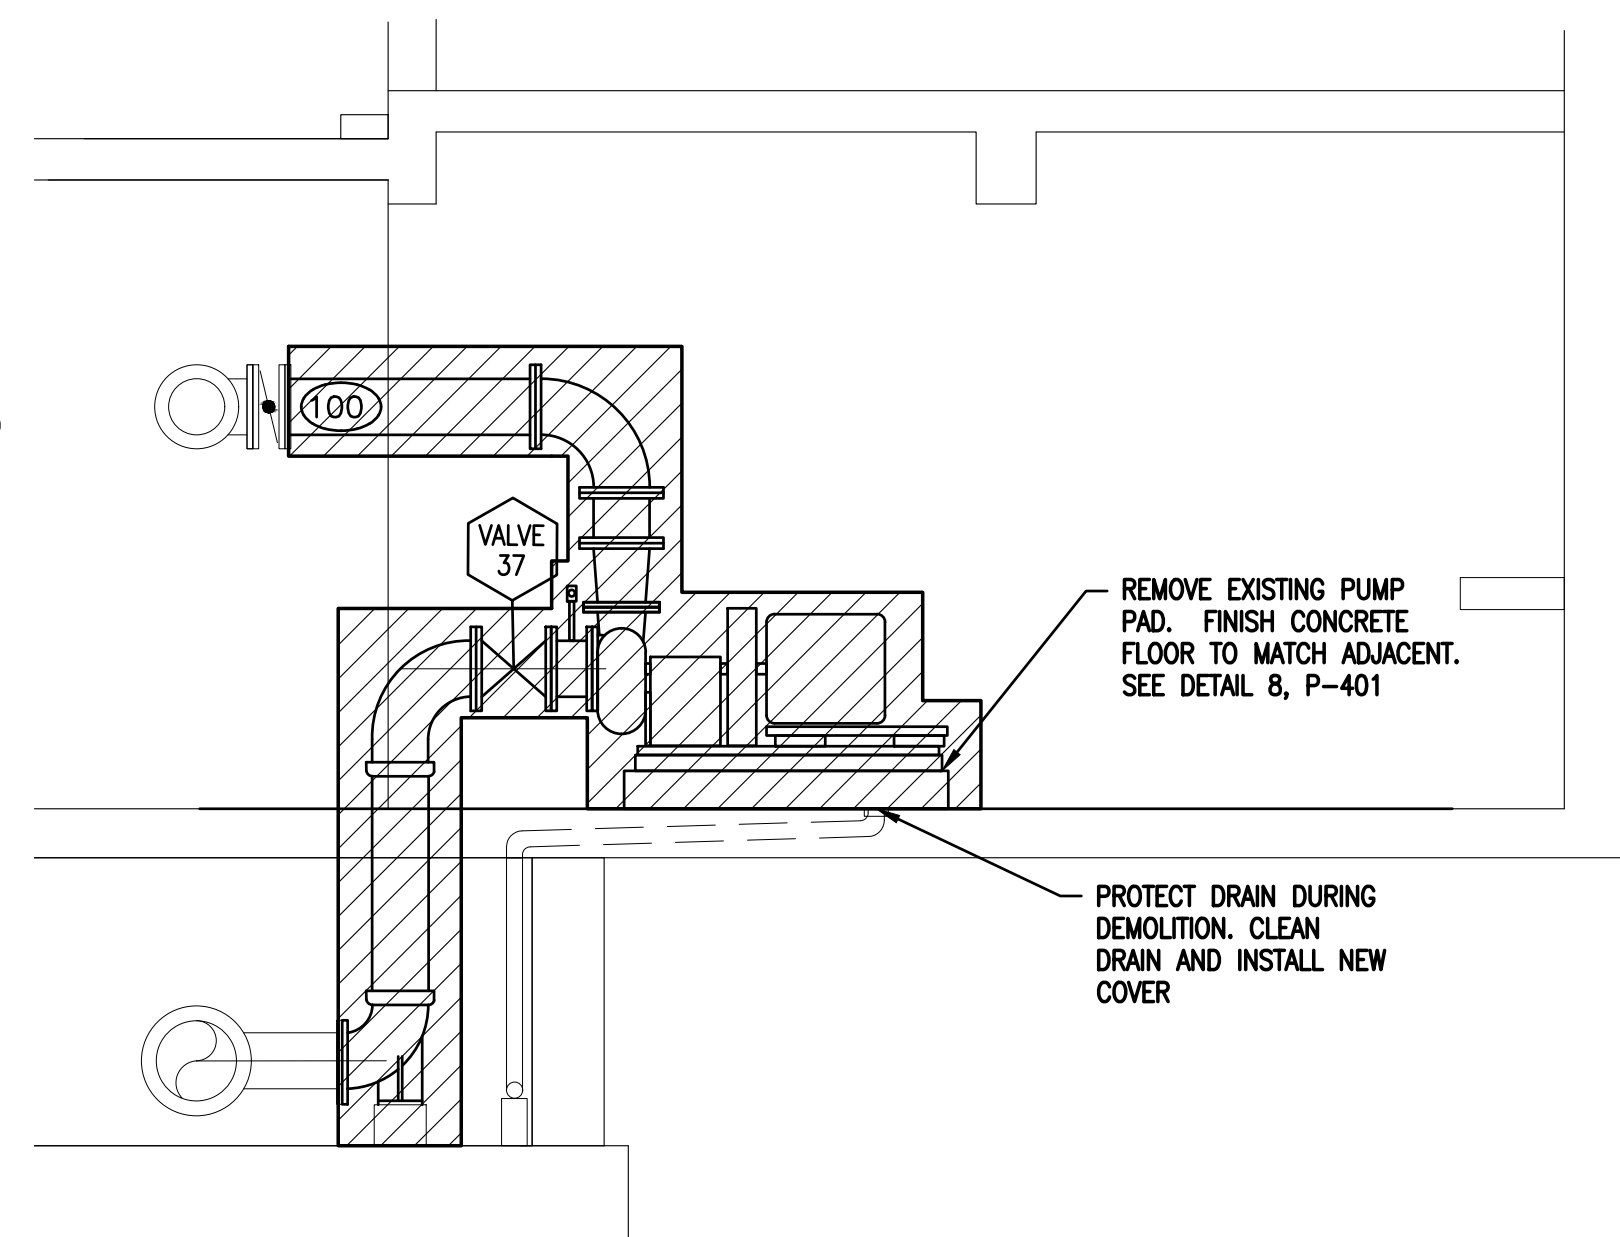





4 EXISTING PUMP DEMO ELEVATION
1/4" = 1'-0"

- NOTES:
1. CONTRACTOR SHALL COORDINATE WITH WTP SUPERINTENDENT TO SHUTDOWN AND REMOVE PROPELLER METER TO FACILITATE ACCESS TO SUBBASMENT. THIS LINE MAY ONLY BE TAKEN OUT OF SERVICE WHILE ALL OTHER SUBBASEMENT PIPING IS IN SERVICE
 2. DETAIL 1 WAS ORIGINALLY PRODUCED BY CAPITAL CONSULTANTS FOR OWOSSO UNDER CONTRACT 93-147 EXISTING INFORMATION (LIGHT LINE WORK) HAS NOT BEEN VERIFIED.

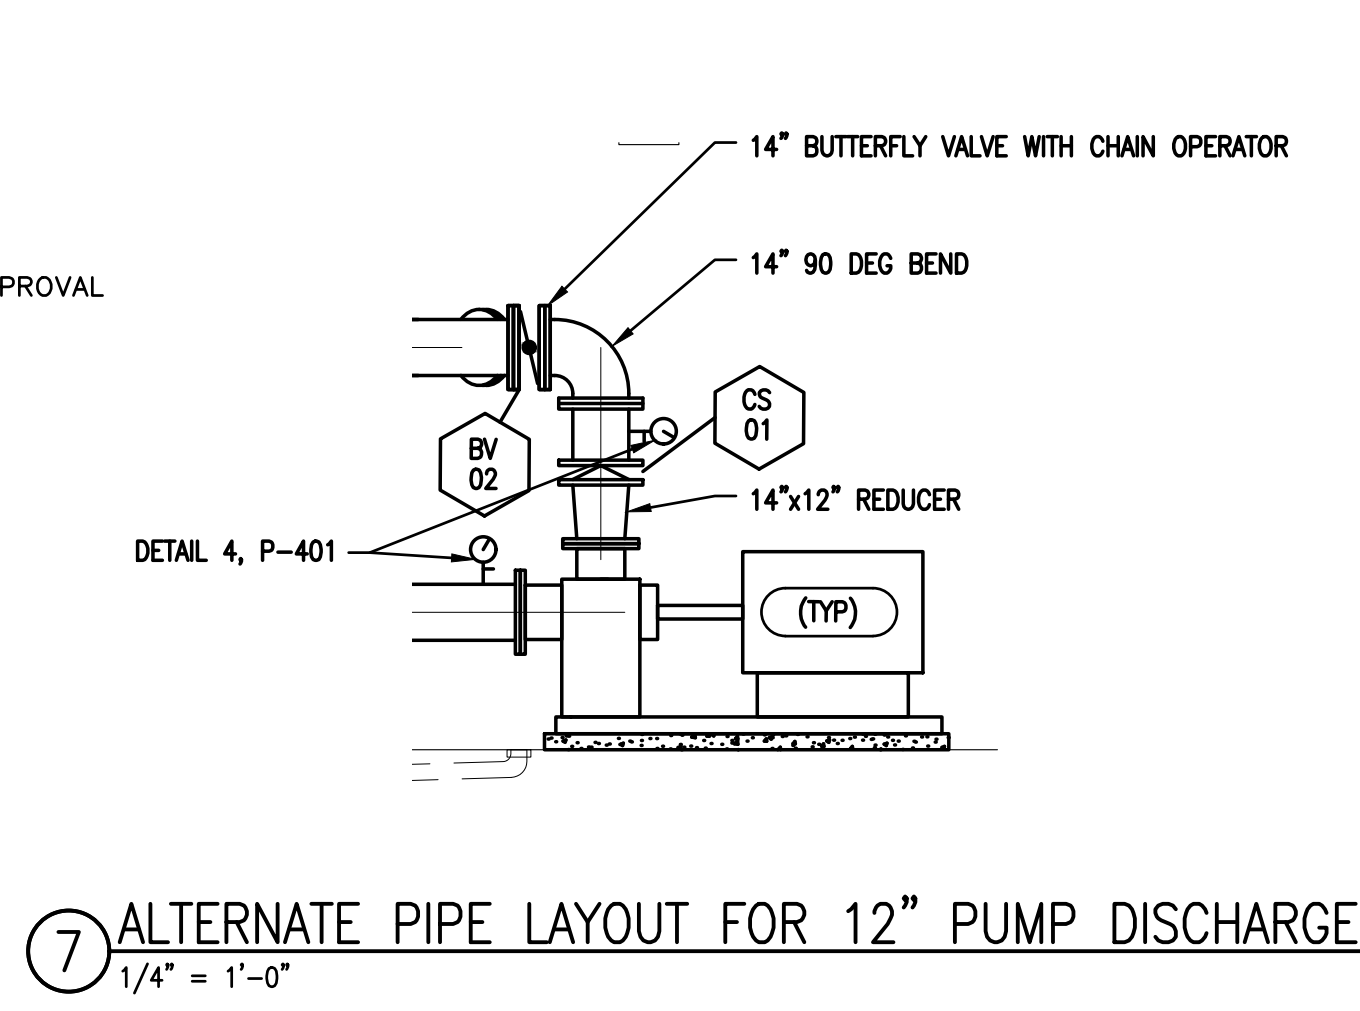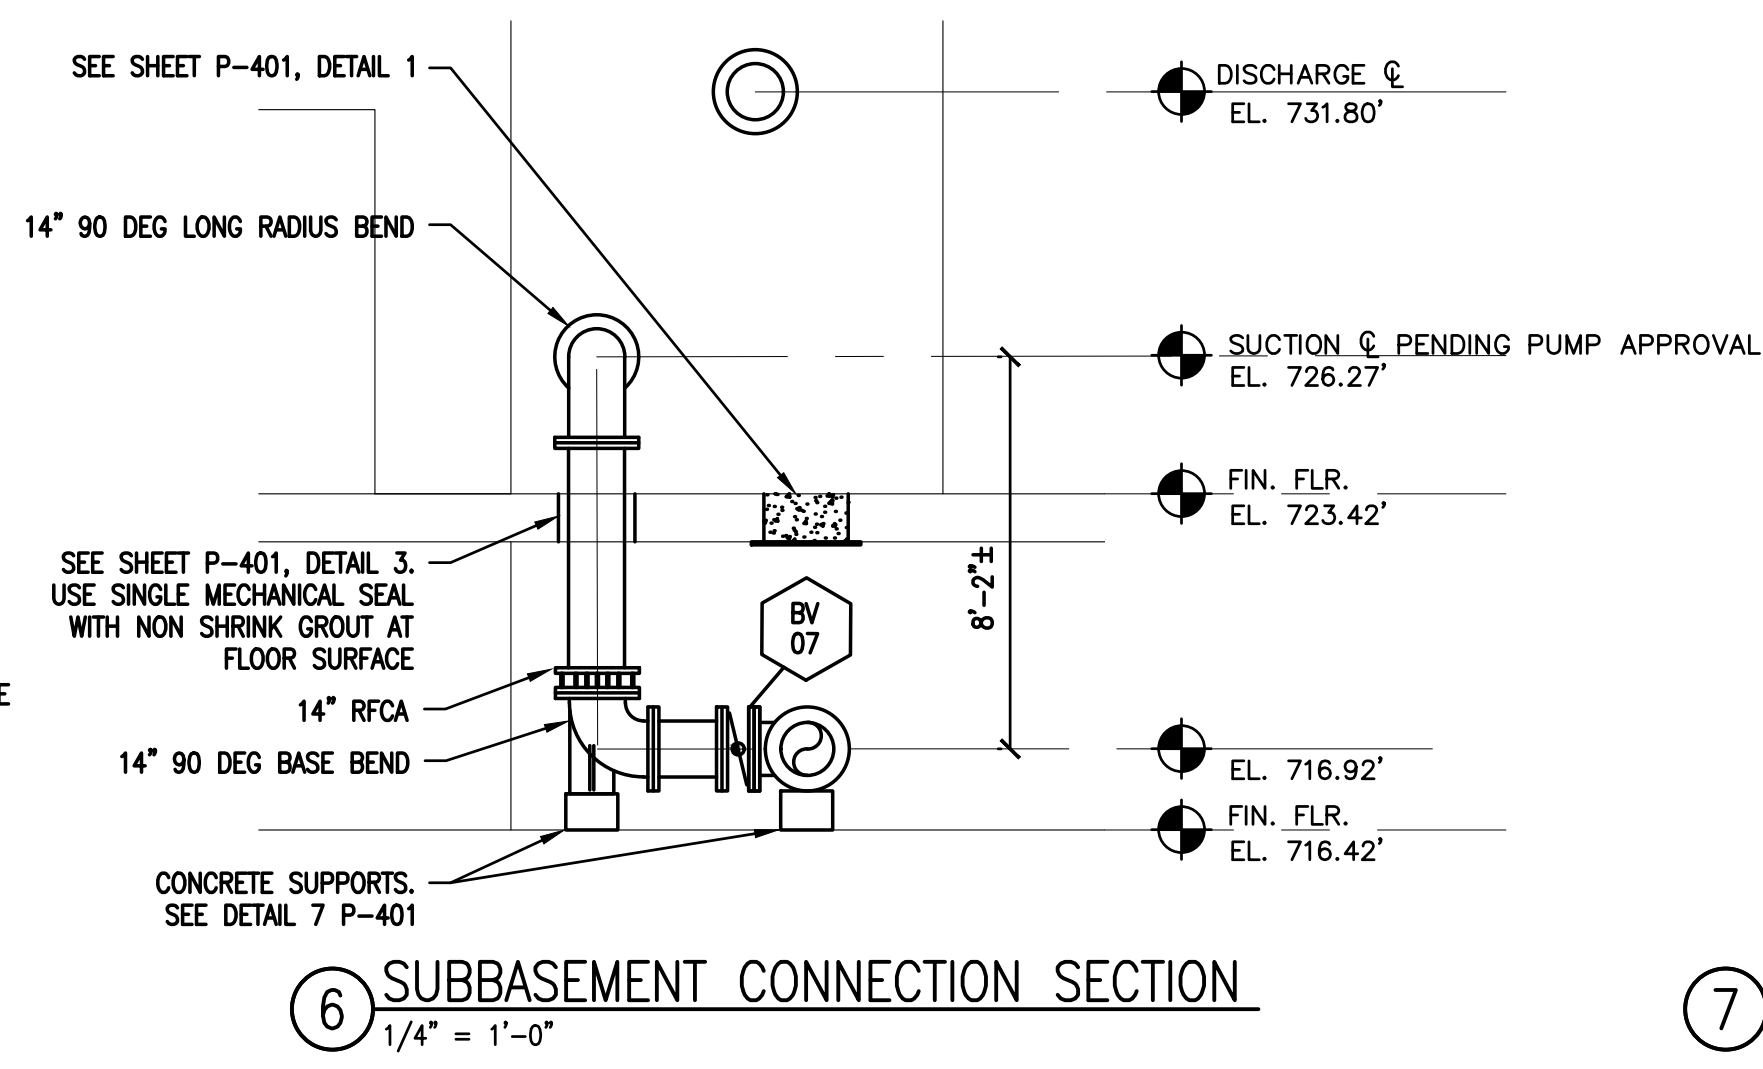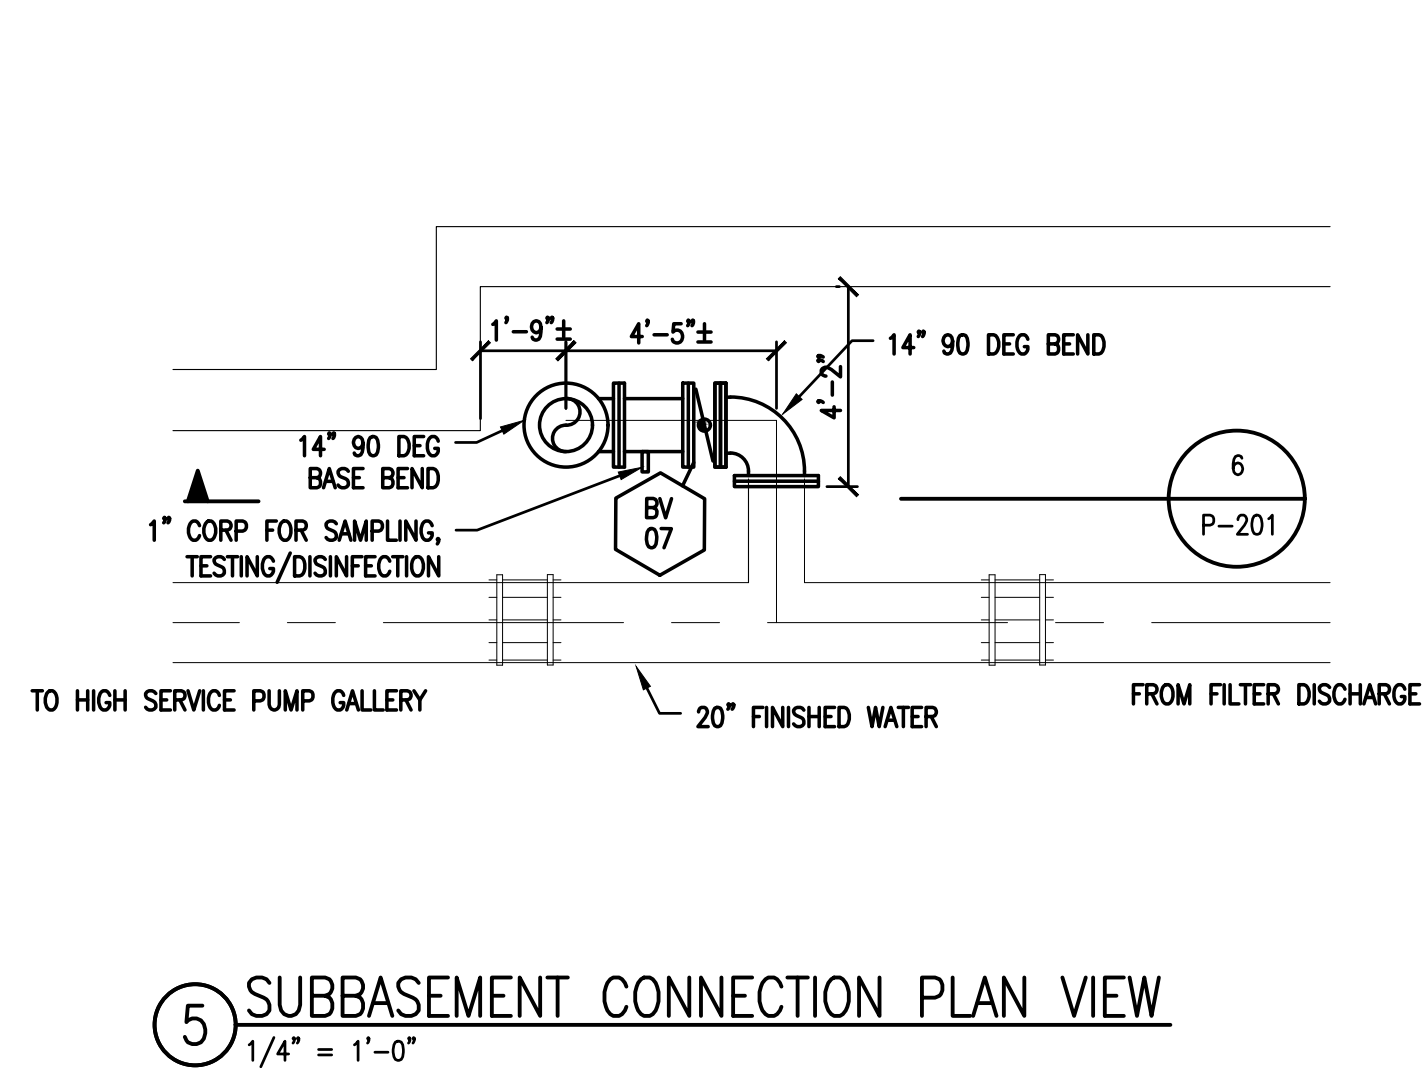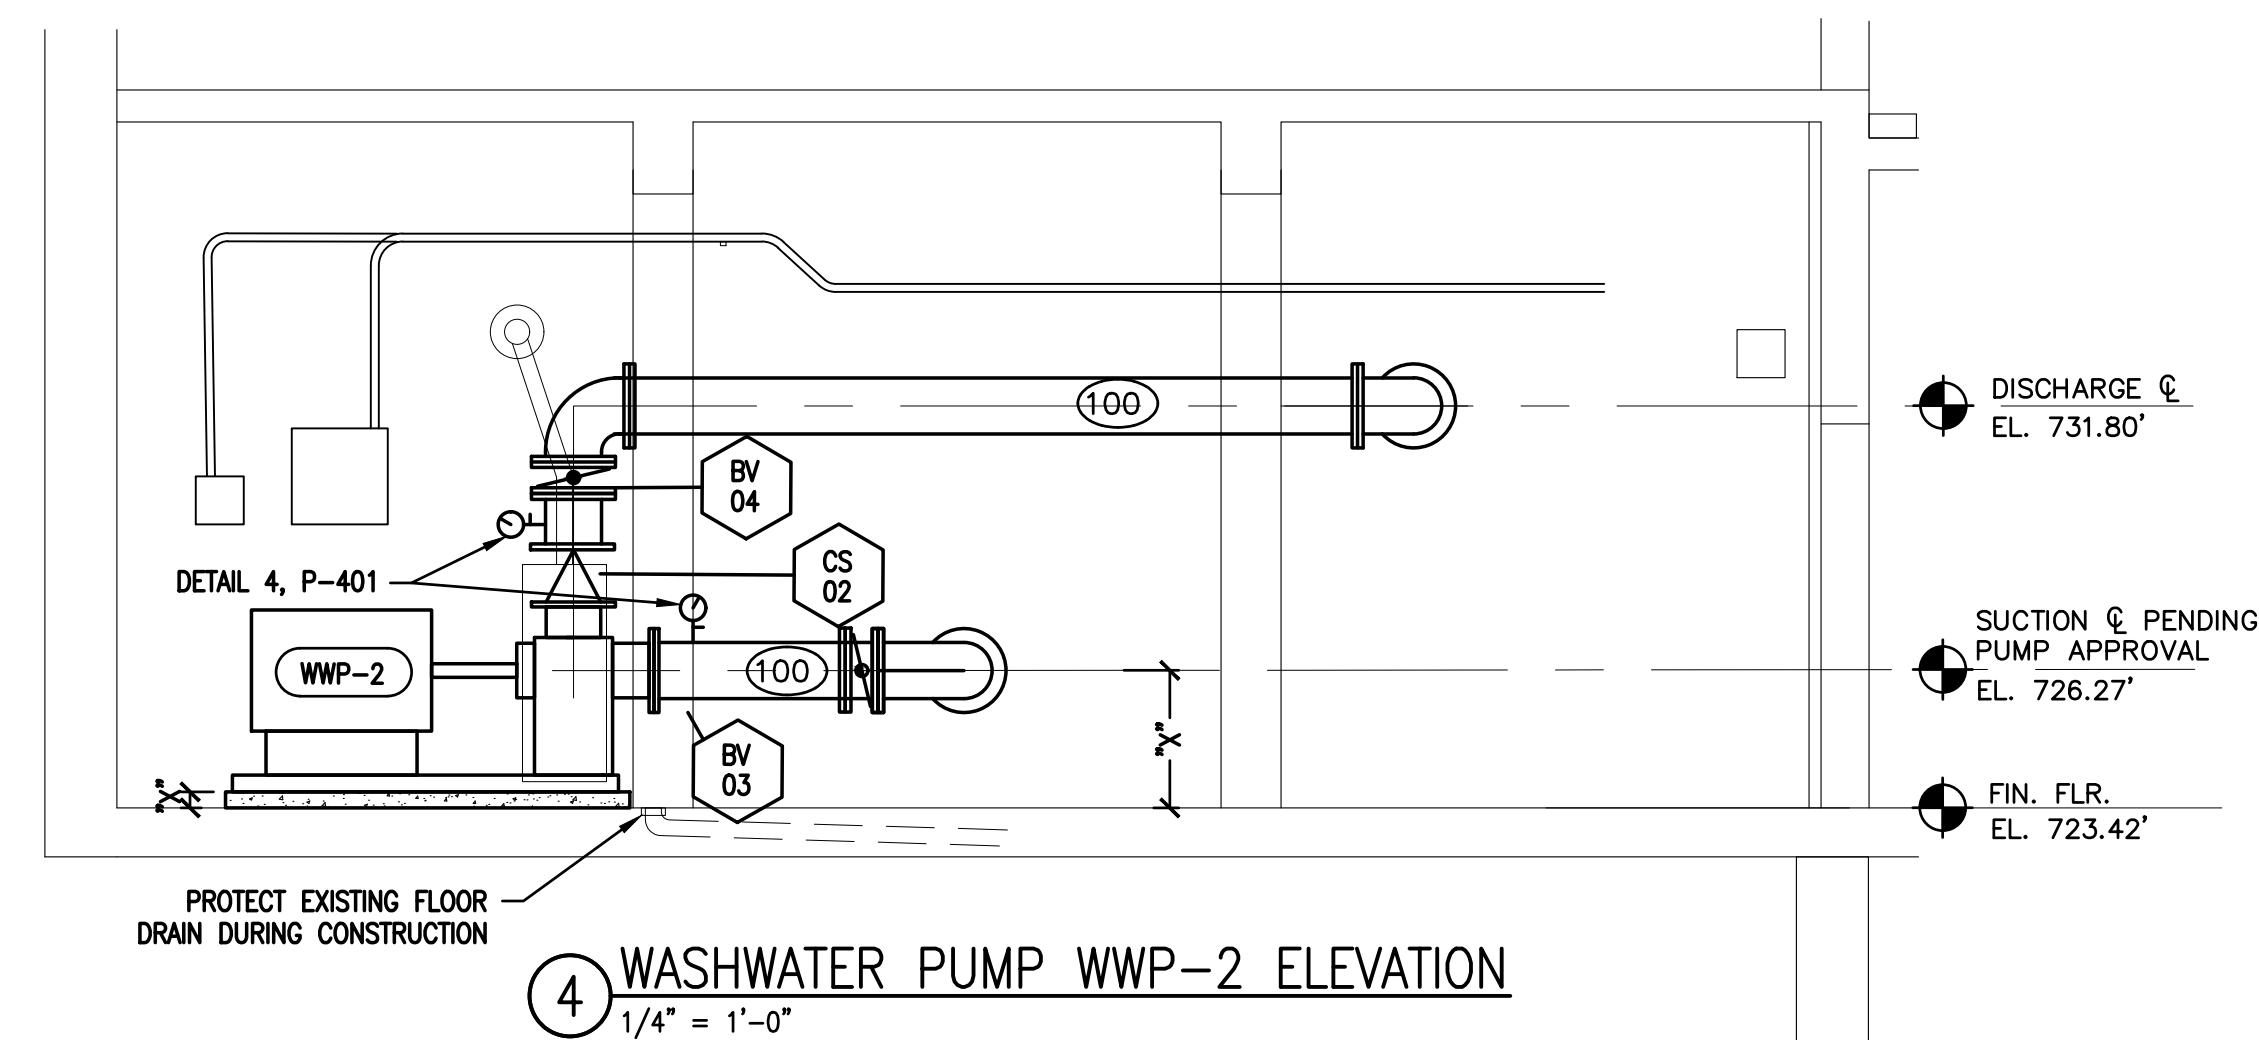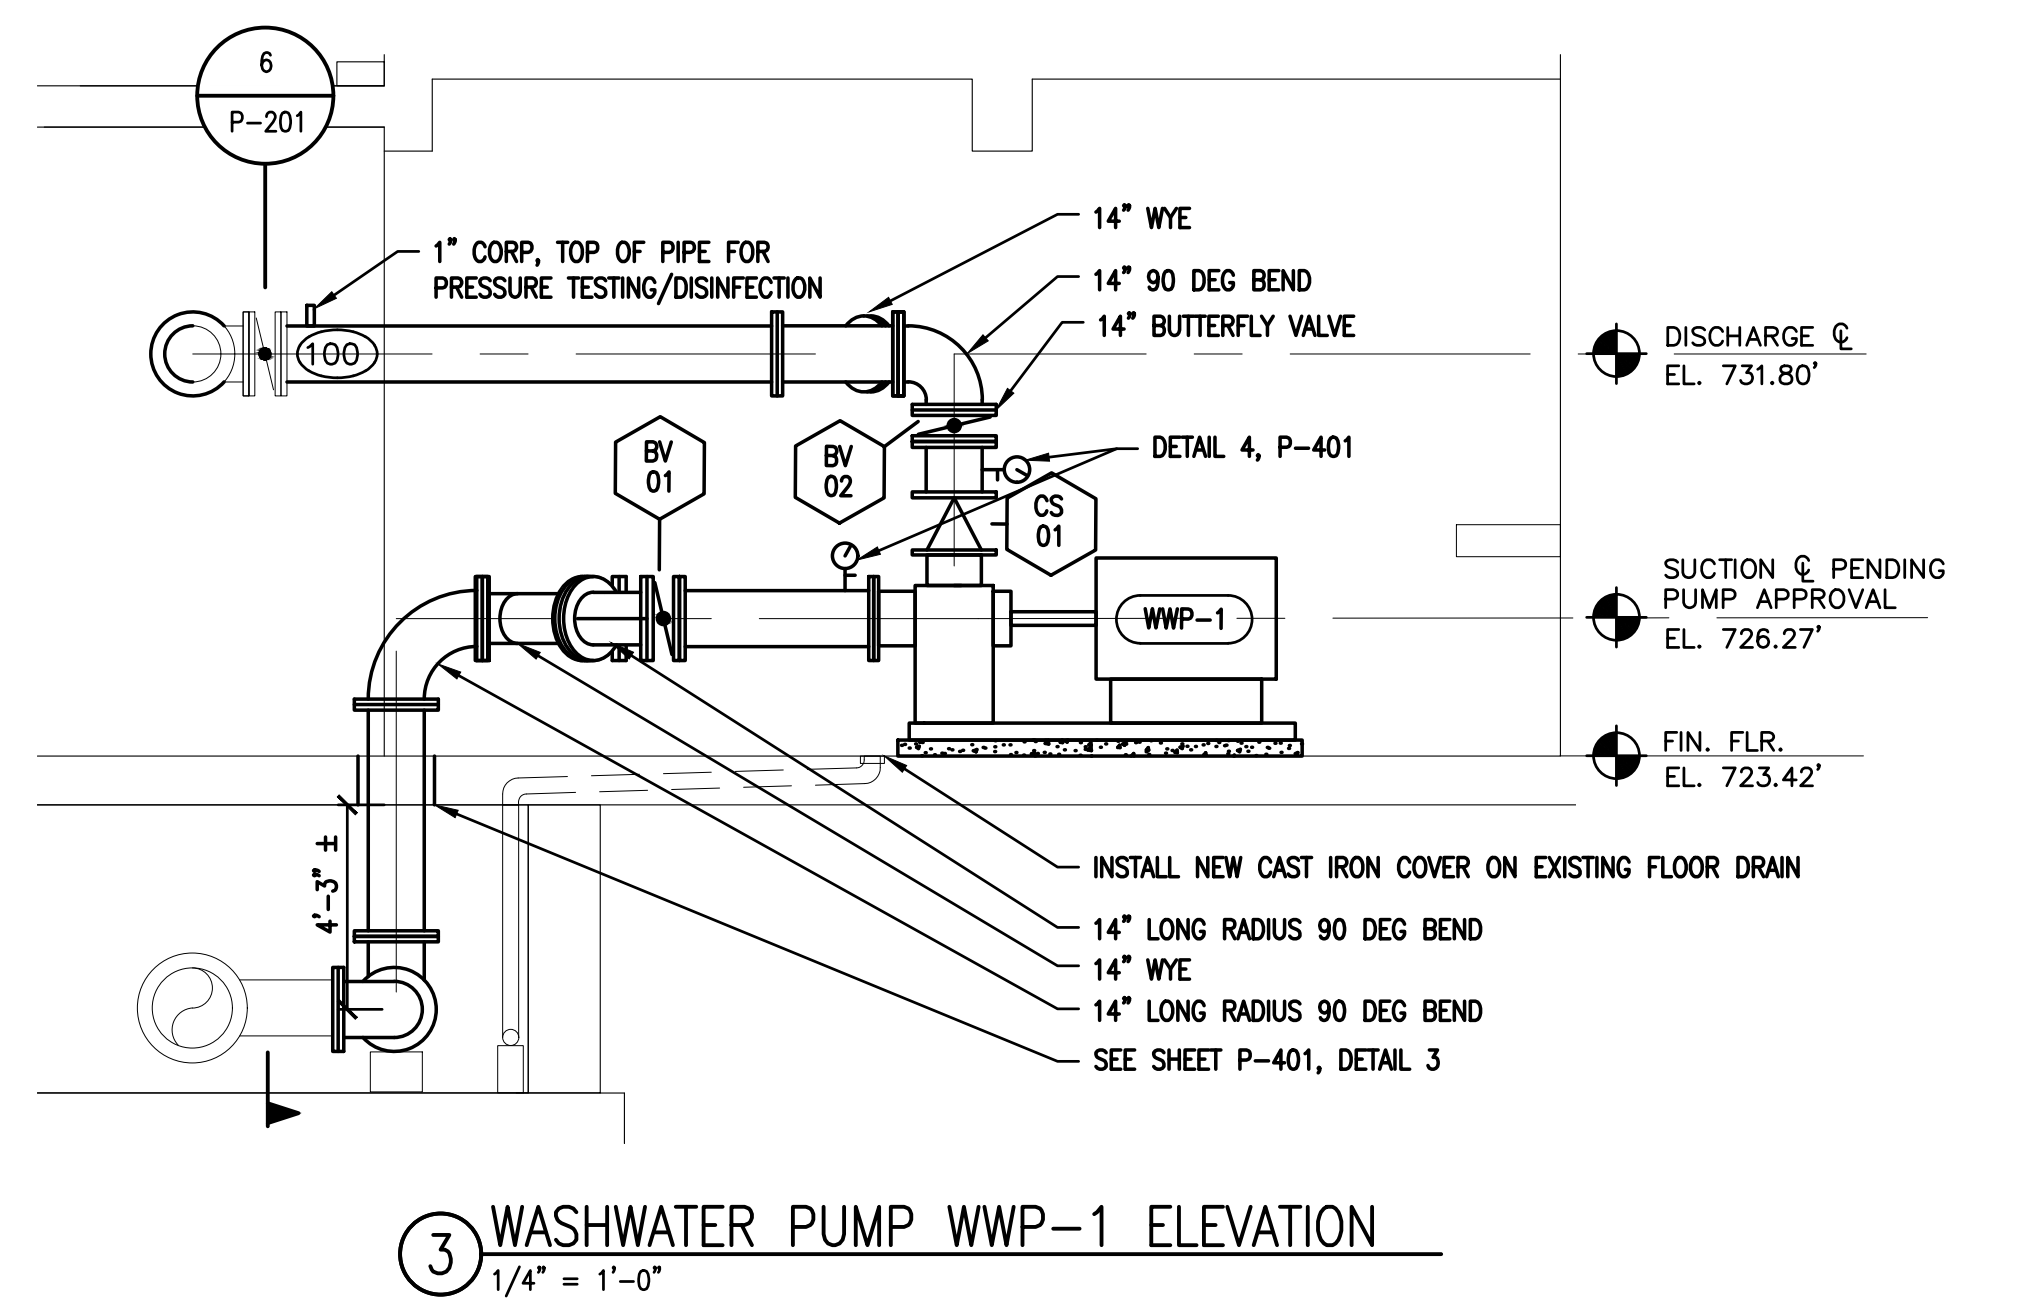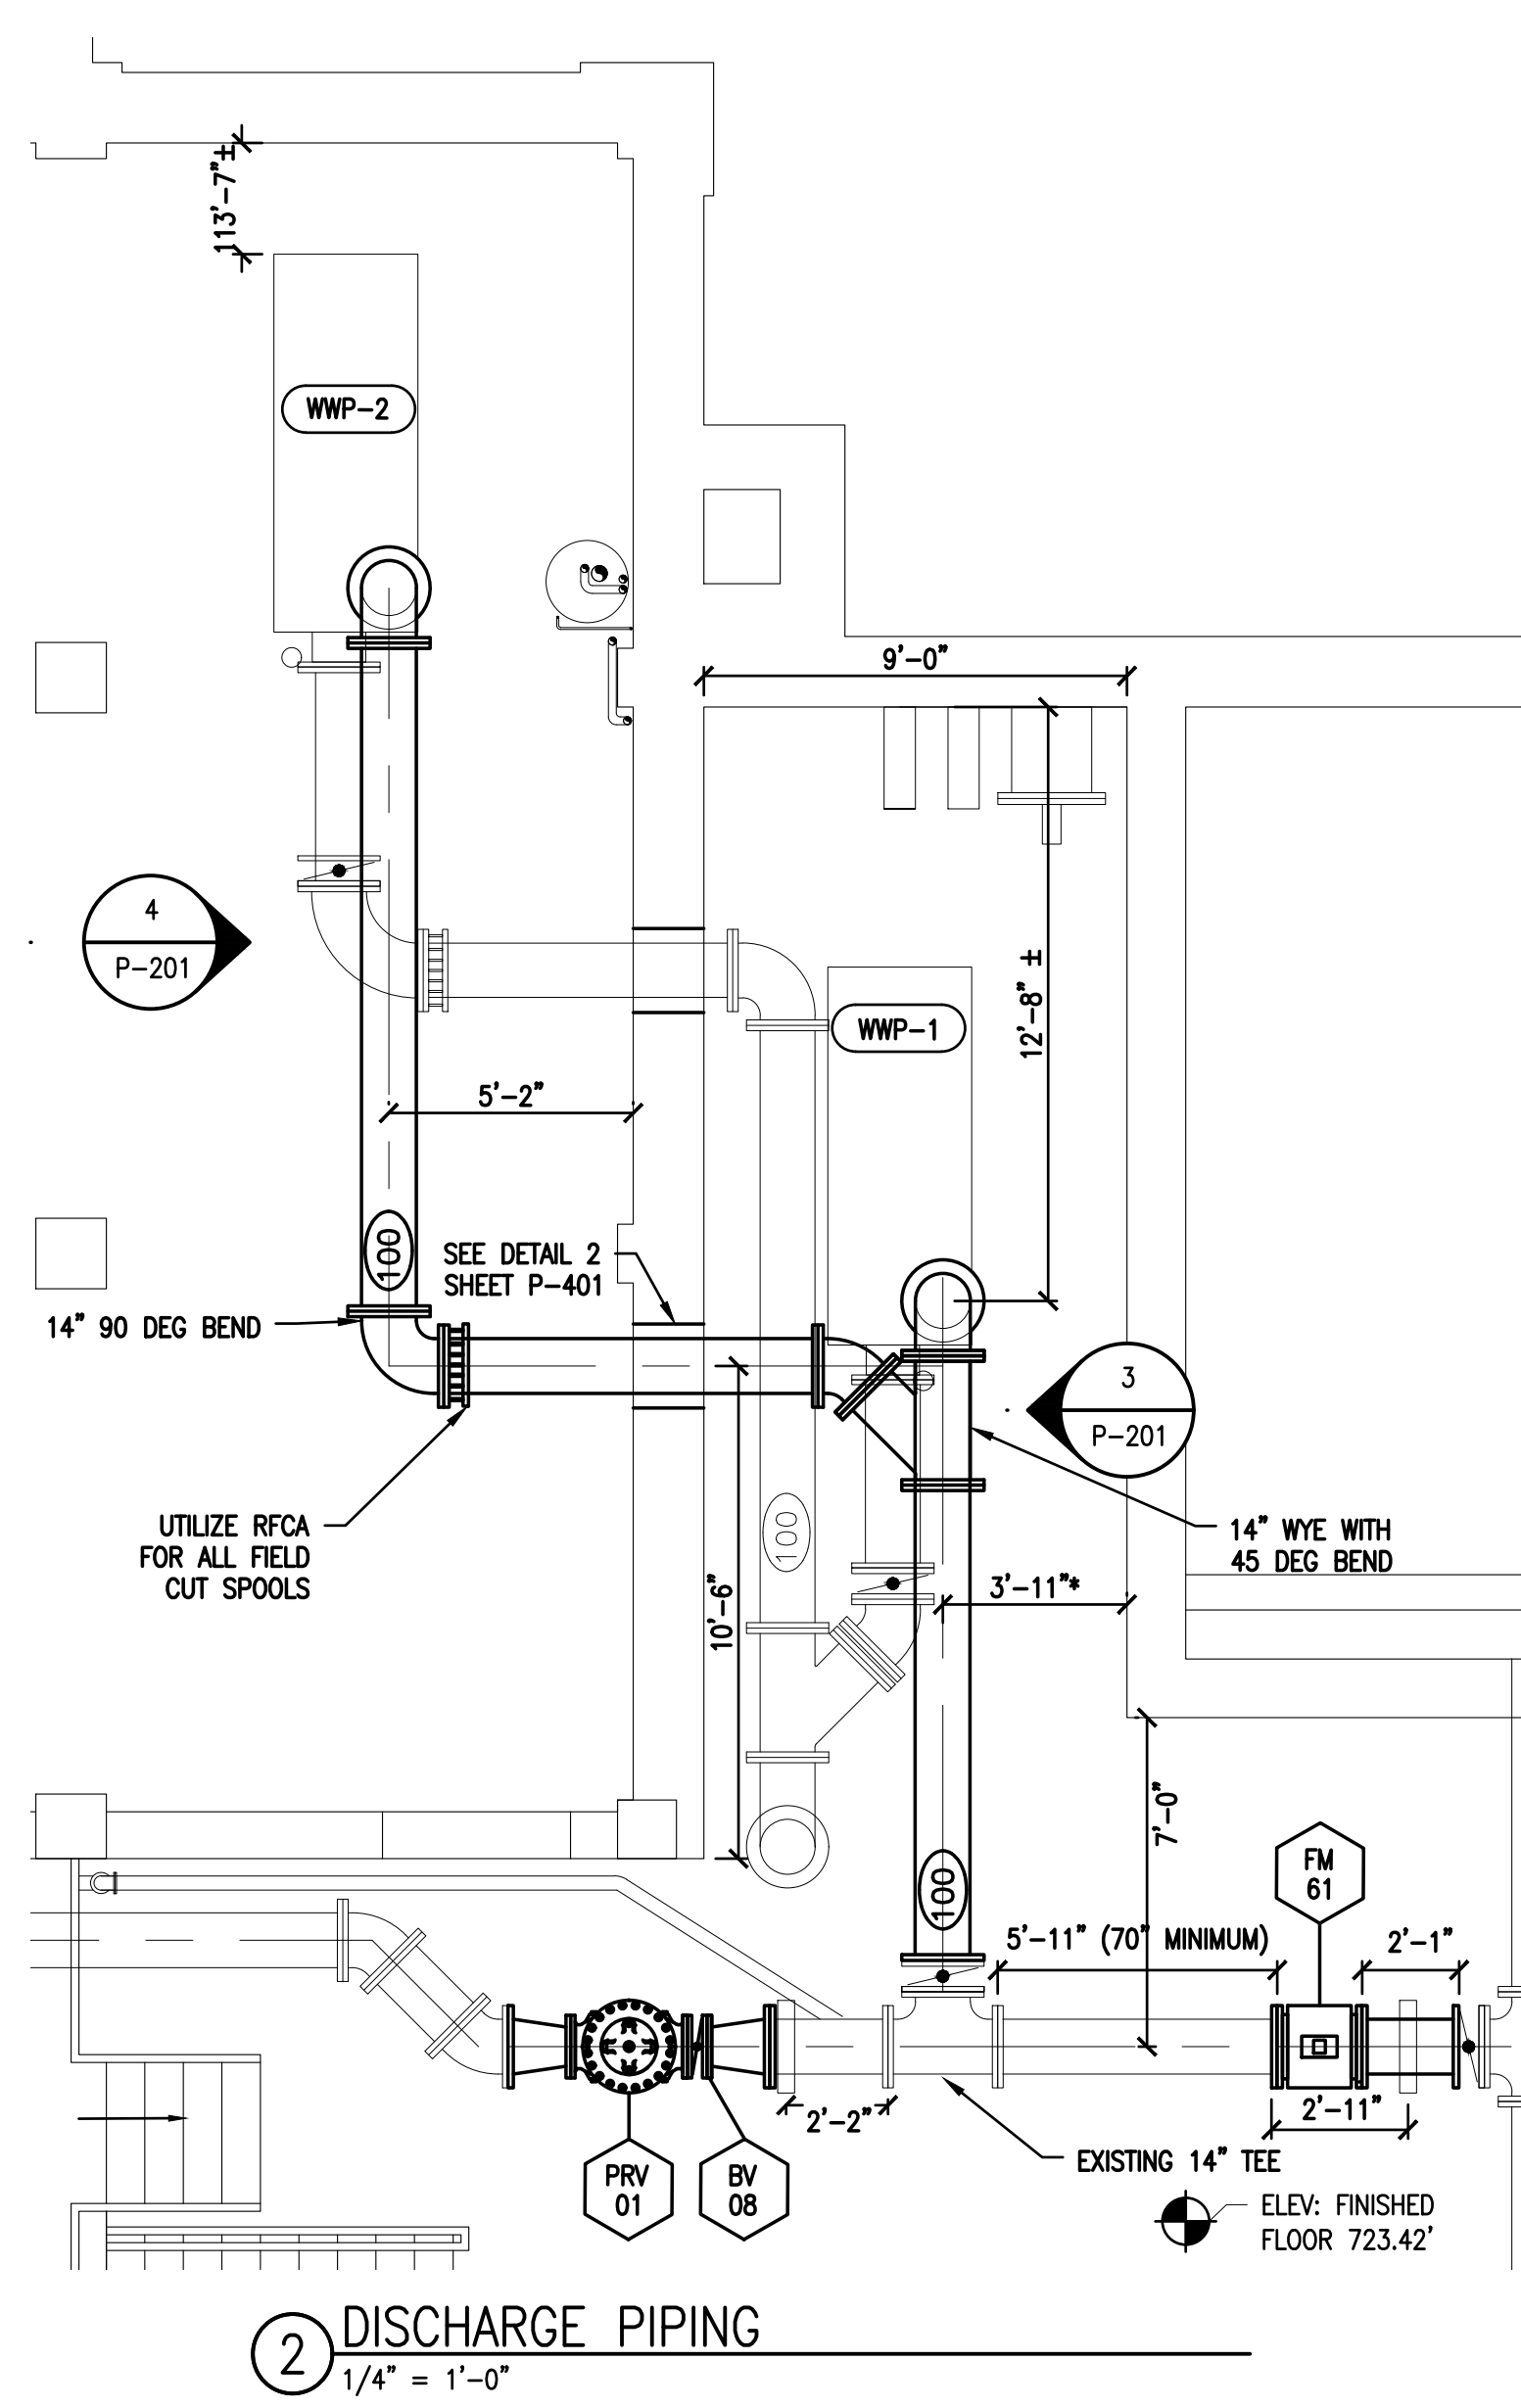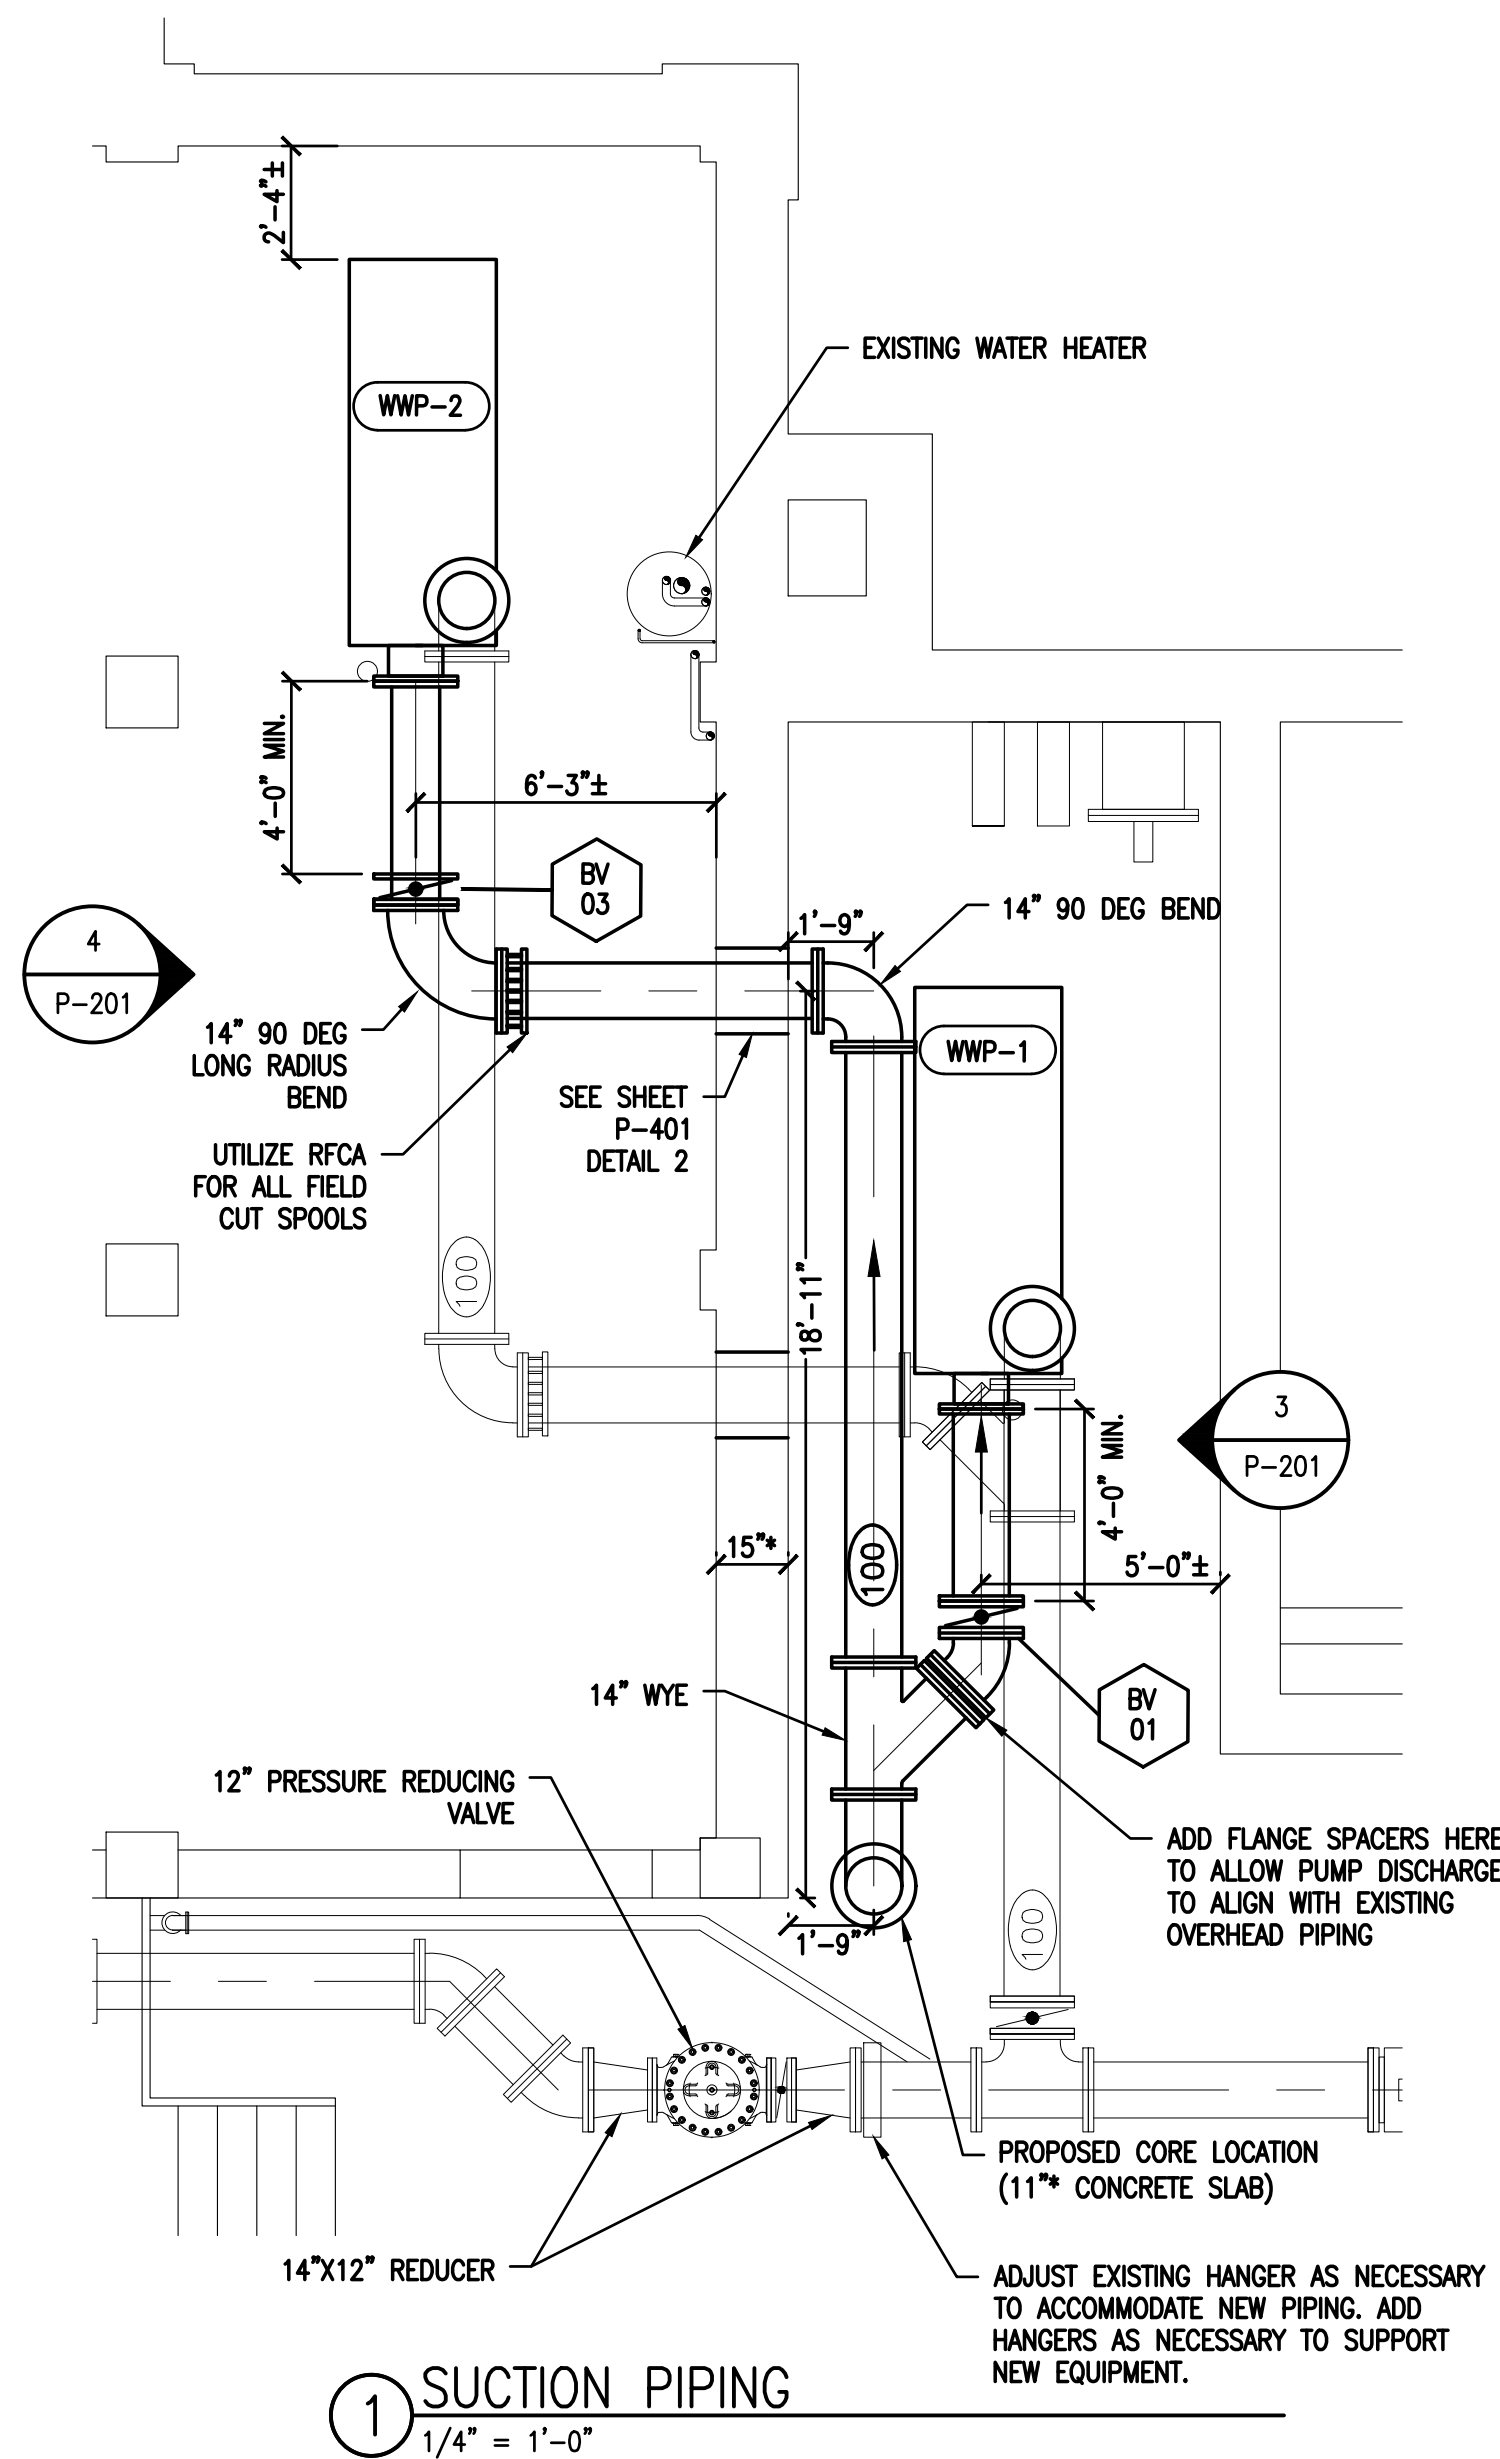


- NOTES:

1. AN ASTERISK (*) AT NEW CONSTRUCTION DENOTES LOCATIONS, ELEVATIONS, DIMENSIONS AND OTHER INFORMATION DEPENDENT ON THE CONTRACTOR'S SUBMITTALS. THE CONTRACTOR SHALL DEVELOP AND SHOW THE INFORMATION MARKED WITH AN ASTERISK (*) ON HIS SUBMITTALS AND SHALL DEVELOP AND PROVIDE SUCH INFORMATION FOR ALL ASTERISKS (*) WITHIN OR INTERFACING WITH ANY SUBMITTALS AND BETWEEN SUBMITTALS. THIS REQUIREMENT ALSO EXTENDS TO CONDITIONS OR SITUATIONS WHERE A LOCATION, DIMENSION, ELEVATION OR OTHER ITEM IS INDICATED TO BE DETERMINED AFTER FINAL SELECTION OF EQUIPMENT AND/OR APPURTENANCES. ALL INFORMATION FOR ASTERISK (*) AND EQUIPMENT--APPURTENANCES SITUATIONS DESCRIBED HEREIN ARE THE RESPONSIBILITY OF THE CONTRACTOR TO DEVELOP AND ASSURE COMPATIBLE INTERFACING FOR A COMPLETE, COORDINATED AND TROUBLE-FREE OPERATING INSTALLATION. ALL REQUIREMENTS HEREIN SHALL BE BASED ON FINAL PROCESSING AND/OR REVIEW OF THE CONTRACTOR'S SUBMITTALS OR SELECTIONS.
2. DIMENSIONS "X" OR WITH $\pm$ WILL BE DEPENDENT UPON THE PUMP SELECTED. PIPING & EQUIPMENT PAD SHALL BE ADJUSTED ACCORDINGLY.
3. CONTRACTOR TO ADD FLANGE SPACERS BETWEEN BUTTERFLY VALVES AND ADJACENT FITTING IF NECESSARY TO PROVIDE OPENING CLEARANCE.
4. PIPE SUPPORTS NOT SHOWN FOR NEW PUMP EQUIPMENT. CONTRACTOR TO PROVIDE ALL SUPPORTS NECESSARY TO ENSURE PIPES ARE ADEQUATELY SUPPORTED AND WEIGHT IS NOT SUPPORTED FROM PUMP FLANGES. PIPING ON SECTION SIDE OF PUMPS TO BE SUPPORTED FROM THE FLOOR. PIPING ON DISCHARGE SIDE OF PUMPS TO BE SUPPORTED FROM CEILING. CONTRACTOR TO ACCOMMODATE EXISTING PIPING WITH PIPE SUPPORT DESIGN.

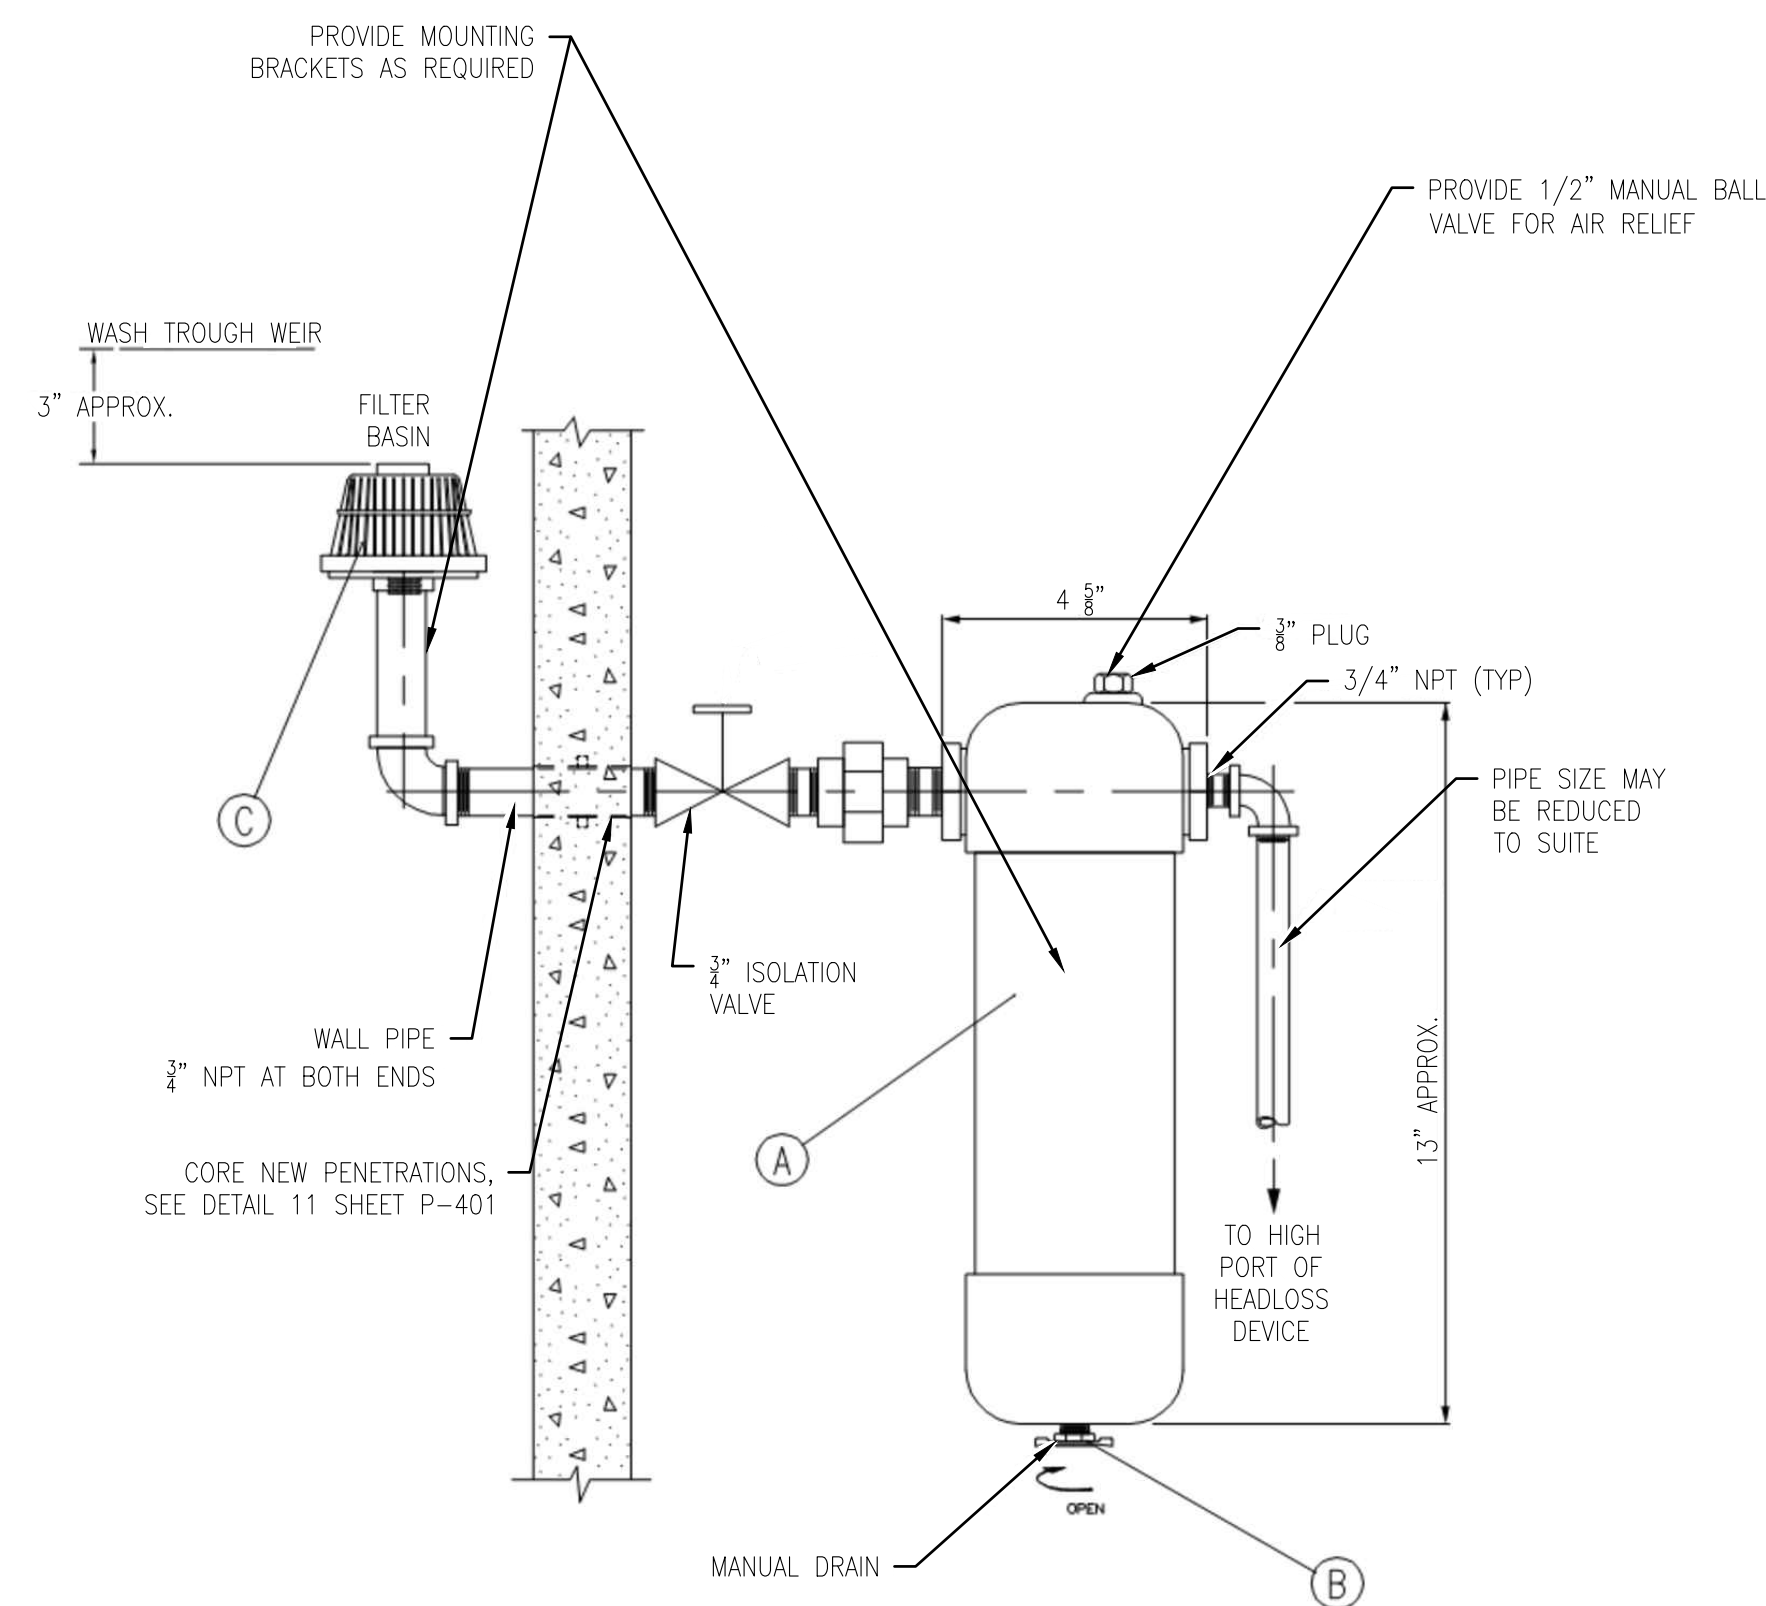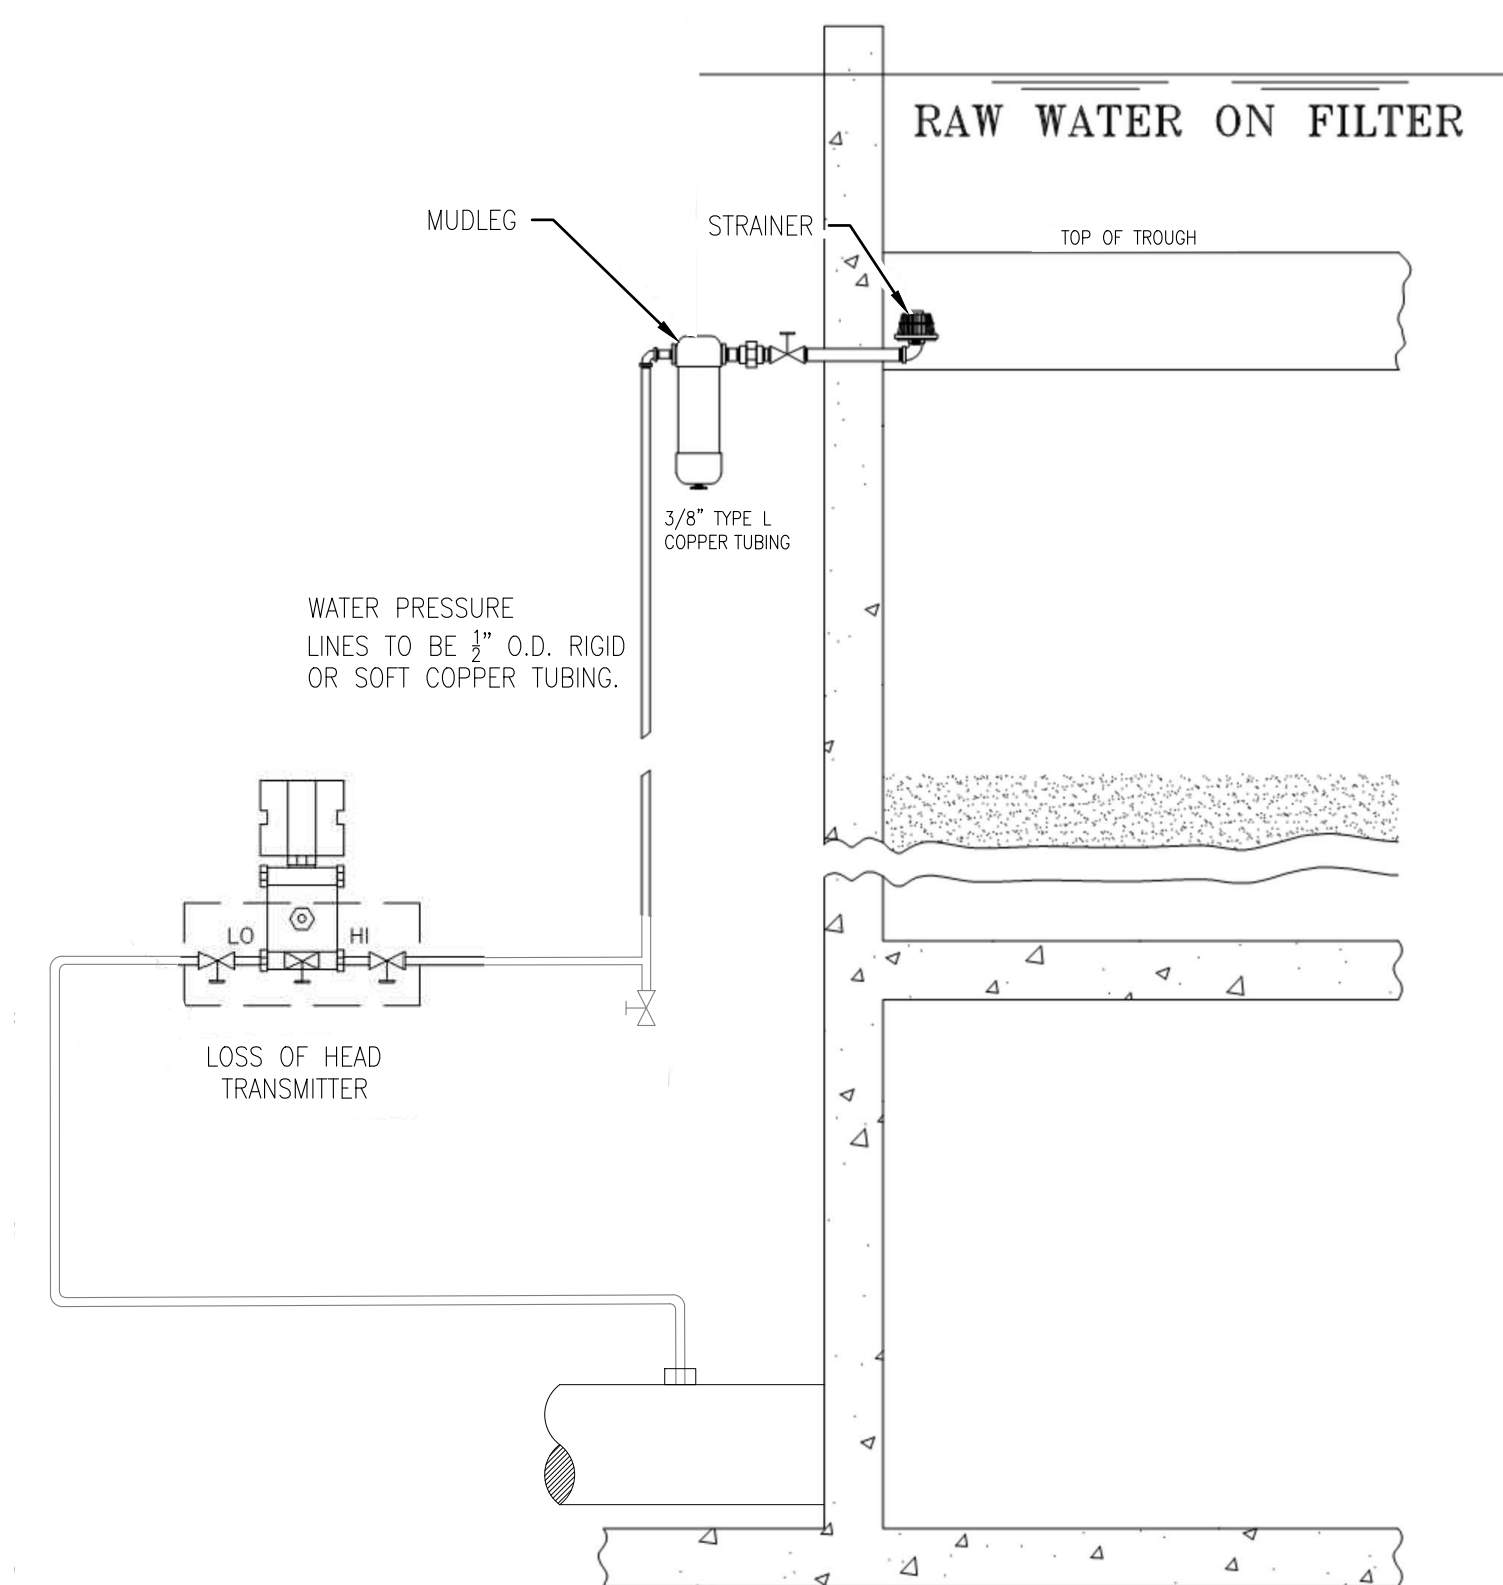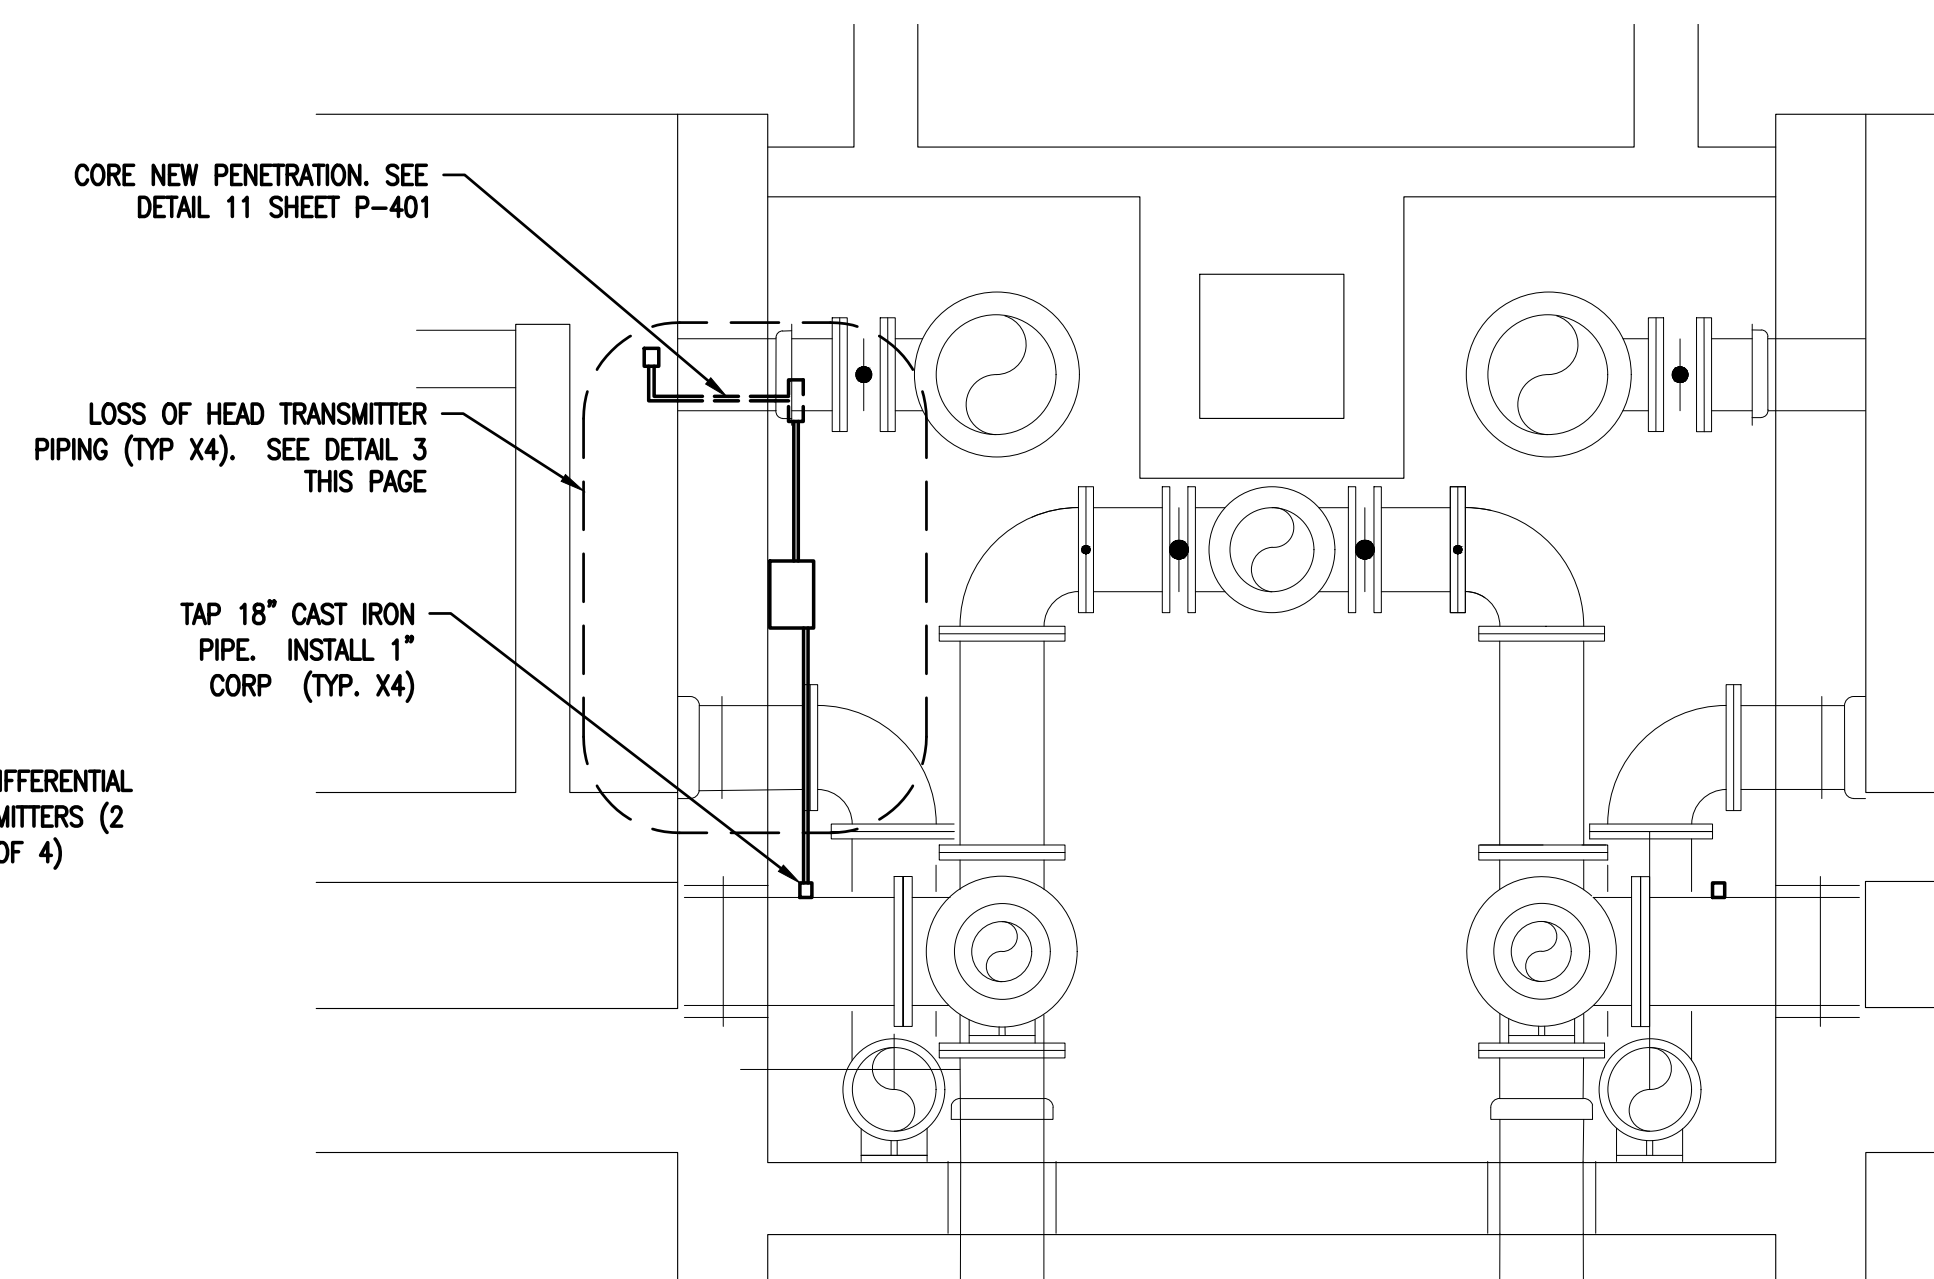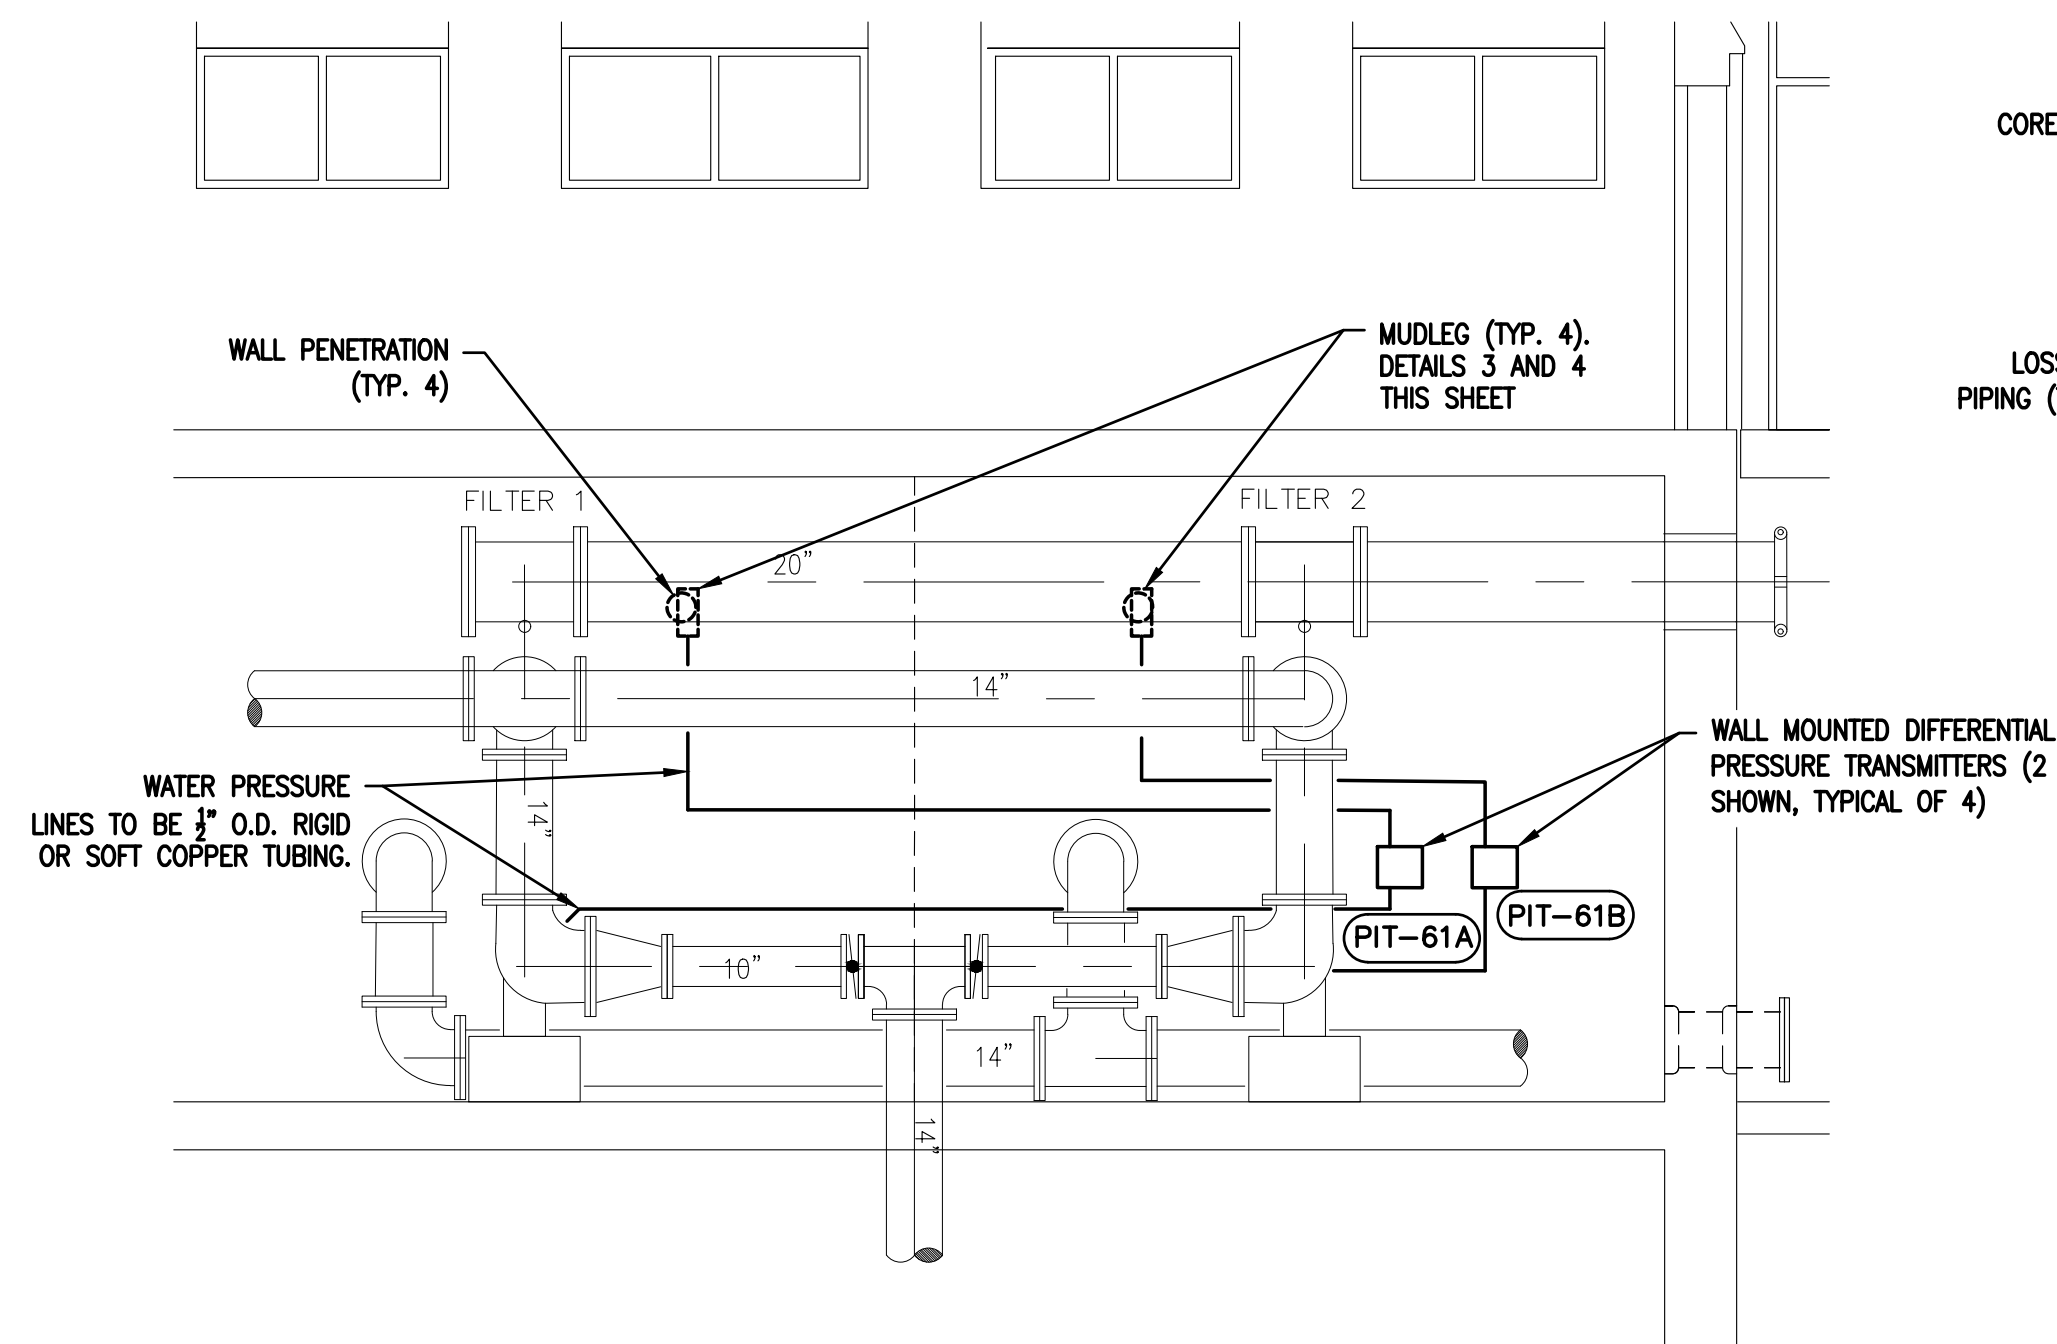

PARTS LIST (PER UNIT)			
TAG	DESCRIPTION	MATERIAL	LEOPOLD PART #
	MUDLEG & STRAINER ASSEMBLY CONSISTING OF THE FOLLOWING PARTS		
A	MUDLEG	PVC	
	3" CAP, SCHEDULE 40	PVC	102-207-110
	BUSHING, 1" X 3/4"	PVC	102-208-020
	3" PIPE, SCHEDULE 40	PVC	106-070-053
	FLAT, 1/4" X 3"	PVC	120-020-030
	PIPE PLUG, 3/8" NPT	BRASS	102-107-011
B	MANUAL DRAIN	BRASS	107-040-050
C	STRAINER, 3/4" NPT	POLYPRO PYLENE	107-001-060

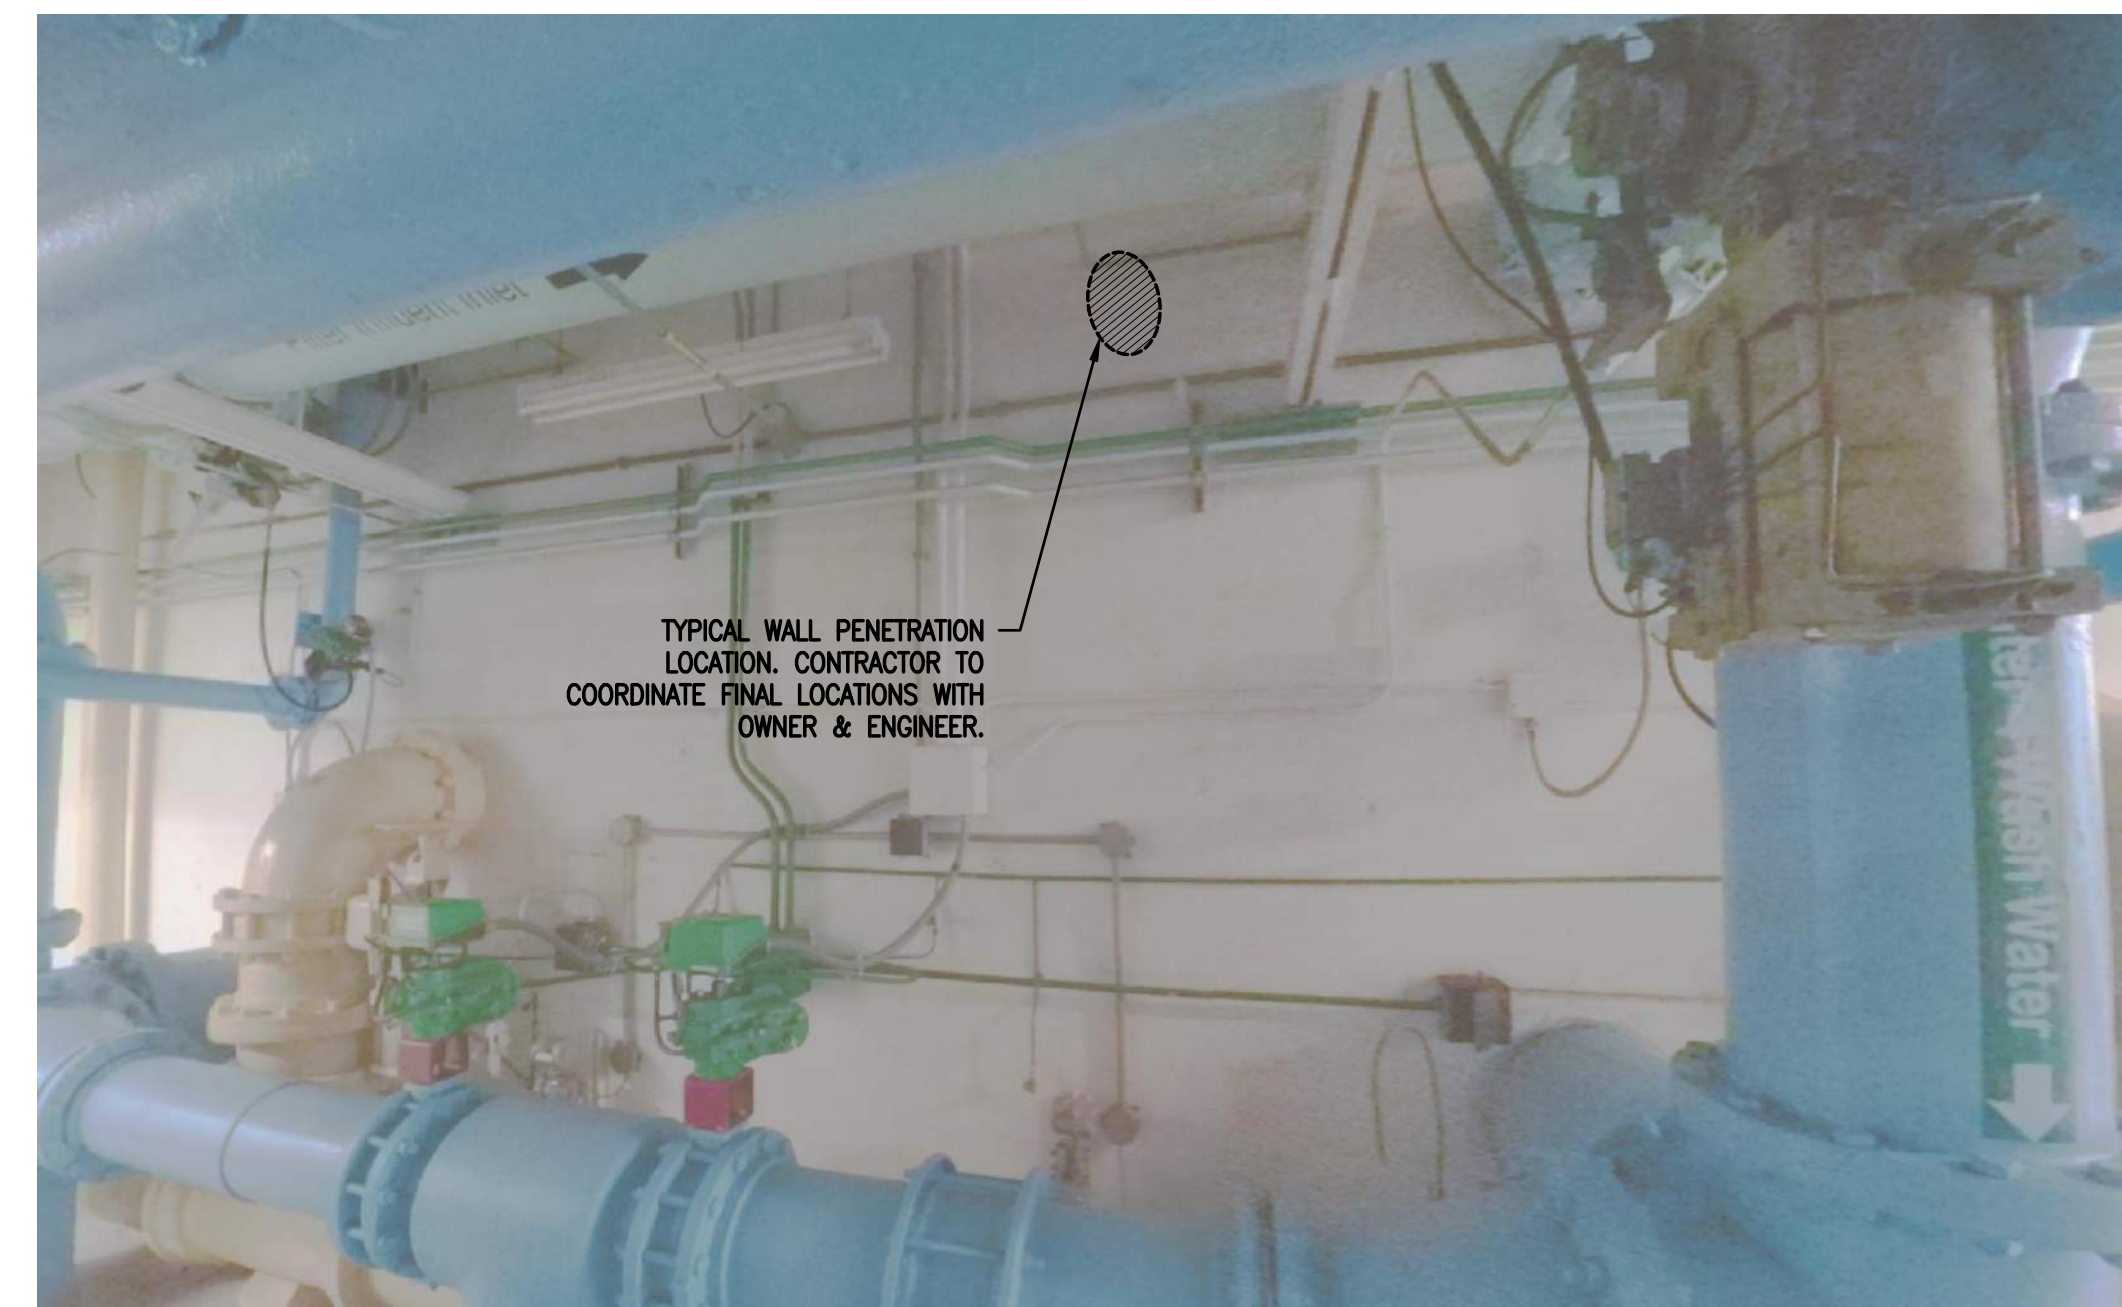


DRAWING PATH: \\lamdis\corporate\Projects\0000_01\00100201\00040_wfp_design_services\Drawings\Facilities\00040P-202.DWG Dec 16, 2019 - 12:21pm

NOTES:

1. CONTRACTOR MAY COORDINATE WITH WTP SUPERINTENDENT TO SHUTDOWN AND REMOVE PROPELLER METER TO FACILITATE ACCESS TO SUBBASEMENT THROUGH HATCH. PROPELLER METER MAY ONLY BE TAKEN OUT OF SERVICE WHILE ALL OTHER SUBBASEMENT PIPING IS IN SERVICE
2. CONTRACTOR MAY ELECT TO USE SHORTER PIPE SEGMENTS THAN WHAT IS SHOWN HERE SUBJECT TO APPROVAL BY ENGINEER. ALL CONNECTIONS SHALL BE FLANGED OR UTILIZE A RFCA. ADDITIONAL PIPE FLANGES OR RFCAS SHALL NOT INTERFERE WITH EXISTING CONCRETE PIPE SUPPORTS.
3. PROTECT EXISTING CONCRETE SUPPORTS FOR REUSE WITH PROPOSED PIPING UNLESS OTHERWISE INDICATED
4. REFER TO SUMMARY SPECIFICATION FOR SEQUENCE OF CONSTRUCTION
5. DETAIL 3 WAS ORIGINALLY PRODUCED BY CAPITAL CONSULTANTS FOR OWOSSO UNDER CONTRACT 93-147 EXISTING INFORMATION (LIGHT LINE WORK) HAS NOT BEEN VERIFIED.
6. CONTRACTOR TO MOUNT EXISTING PRESSURE SENSING TUBING TO CEILING OR WALLS. CONTRACTOR TO FIELD ROUTE.

ADD PIPE SUPPORT ON 12" PIPE.
SEE DETAIL 5, P-401. APPROX
FLOOR TO FLANGE HEIGHT 2'-3"

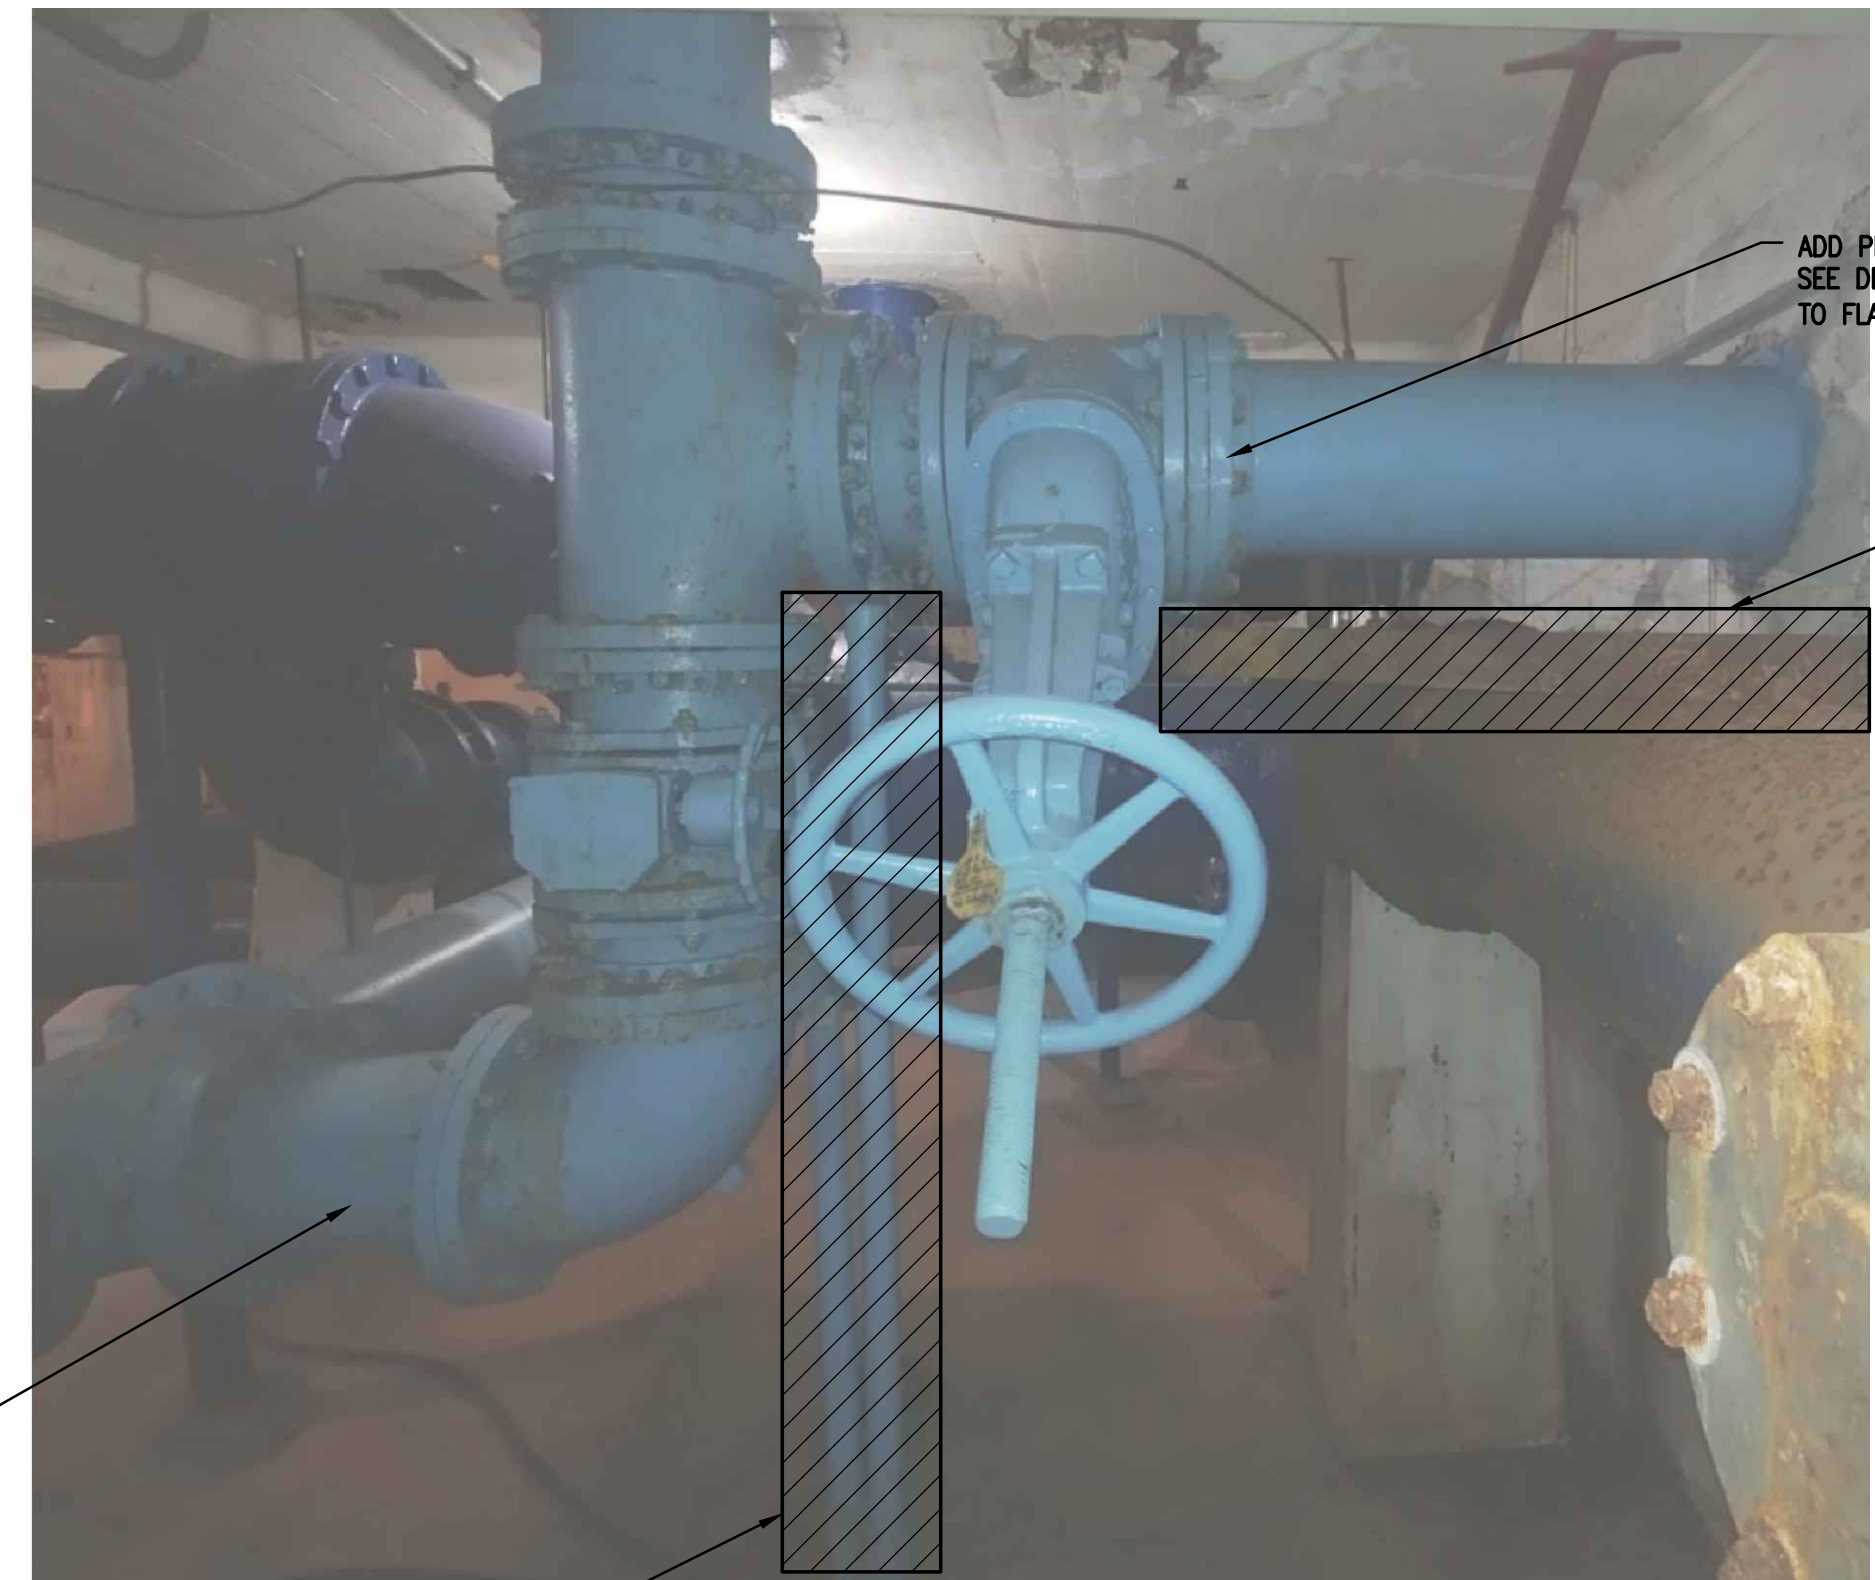

ADD PIPE SUPPORT ON 12" PIPE.
SEE DETAIL 5, P-401. APPROX FLOOR
TO FLANGE HEIGHT 6'-1"

REMOVE I-BEAM AFTER NEW
SUPPORTS ARE INSTALLED

REMOVE EXISTING PIPE SUPPORTS AFTER
NEW SUPPORTS ARE INSTALLED

① HIGH SERVICE SUCTION – PIPE SUPPORT REPLACEMENT
NO SCALE

CONTRACTOR TO PROVIDE ALL NECESSARY
PARTS AND TYPE L COPPER PIPING TO
RECONNECT EXISTING PIPING TO PROPOSED
1" CORP. CONTRACTOR TO BLEED AIR FROM
ALL PIPING AFTER RECONNECTION

REMOVE, PAINT, AND REINSTALL
EXISTING INVERTED PIPE SADDLES
(TYPICAL X2)

TAP SIDE OF PIPE WITH 1"
MUELLER CORP OR EQUAL

EXISTING FLOOR LOWER LEVEL
EL. 726'-5"

16" HIGH SERVICE DISCHARGE
EL. 721'-3"

EXISTING FLOOR
EL. 716'-5"

PERMANENTLY MOUNT EXISTING
PRESSURE SENSING TUBING TO WALLS
AND/OR CEILING; CONTRACTOR TO
FIELD ROUTE

INSTALL 12" EXPANSION PLUG IN BELL OF CAST IRON
FITTING. PENTAIR HAND TITE HT12D OR EQUIVALENT

CONCRETE PIPE SUPPORT; SEE DETAIL
9 SHEET P-401. COORDINATE LOCATION
WITH ENGINEER

RESERVOIR LEVEL GAUGE PIPING TO BE REROUTED TO WALL BEHIND
16" PIPING. CONTRACTOR TO PROVIDE ALL NECESSARY PARTS AND
TYPE L COPPER PIPING TO RECONNECT TO EXISTING VALVE

② HIGH SERVICE PIPE ELEVATION
1/4" = 1'-0"

REDUCER/ADAPTER
TO CONNECT TO
EXISTING TUBING


1" NPT BRASS BALL VALVES

PROVIDE ADAPTERS TO
RECONNECT EXISTING PIPING

TAP TOP OF PIPE WITH 1"
MUELLER CORP OR EQUAL

16" DUCTILE IRON PIPE

NOT TO SCALE

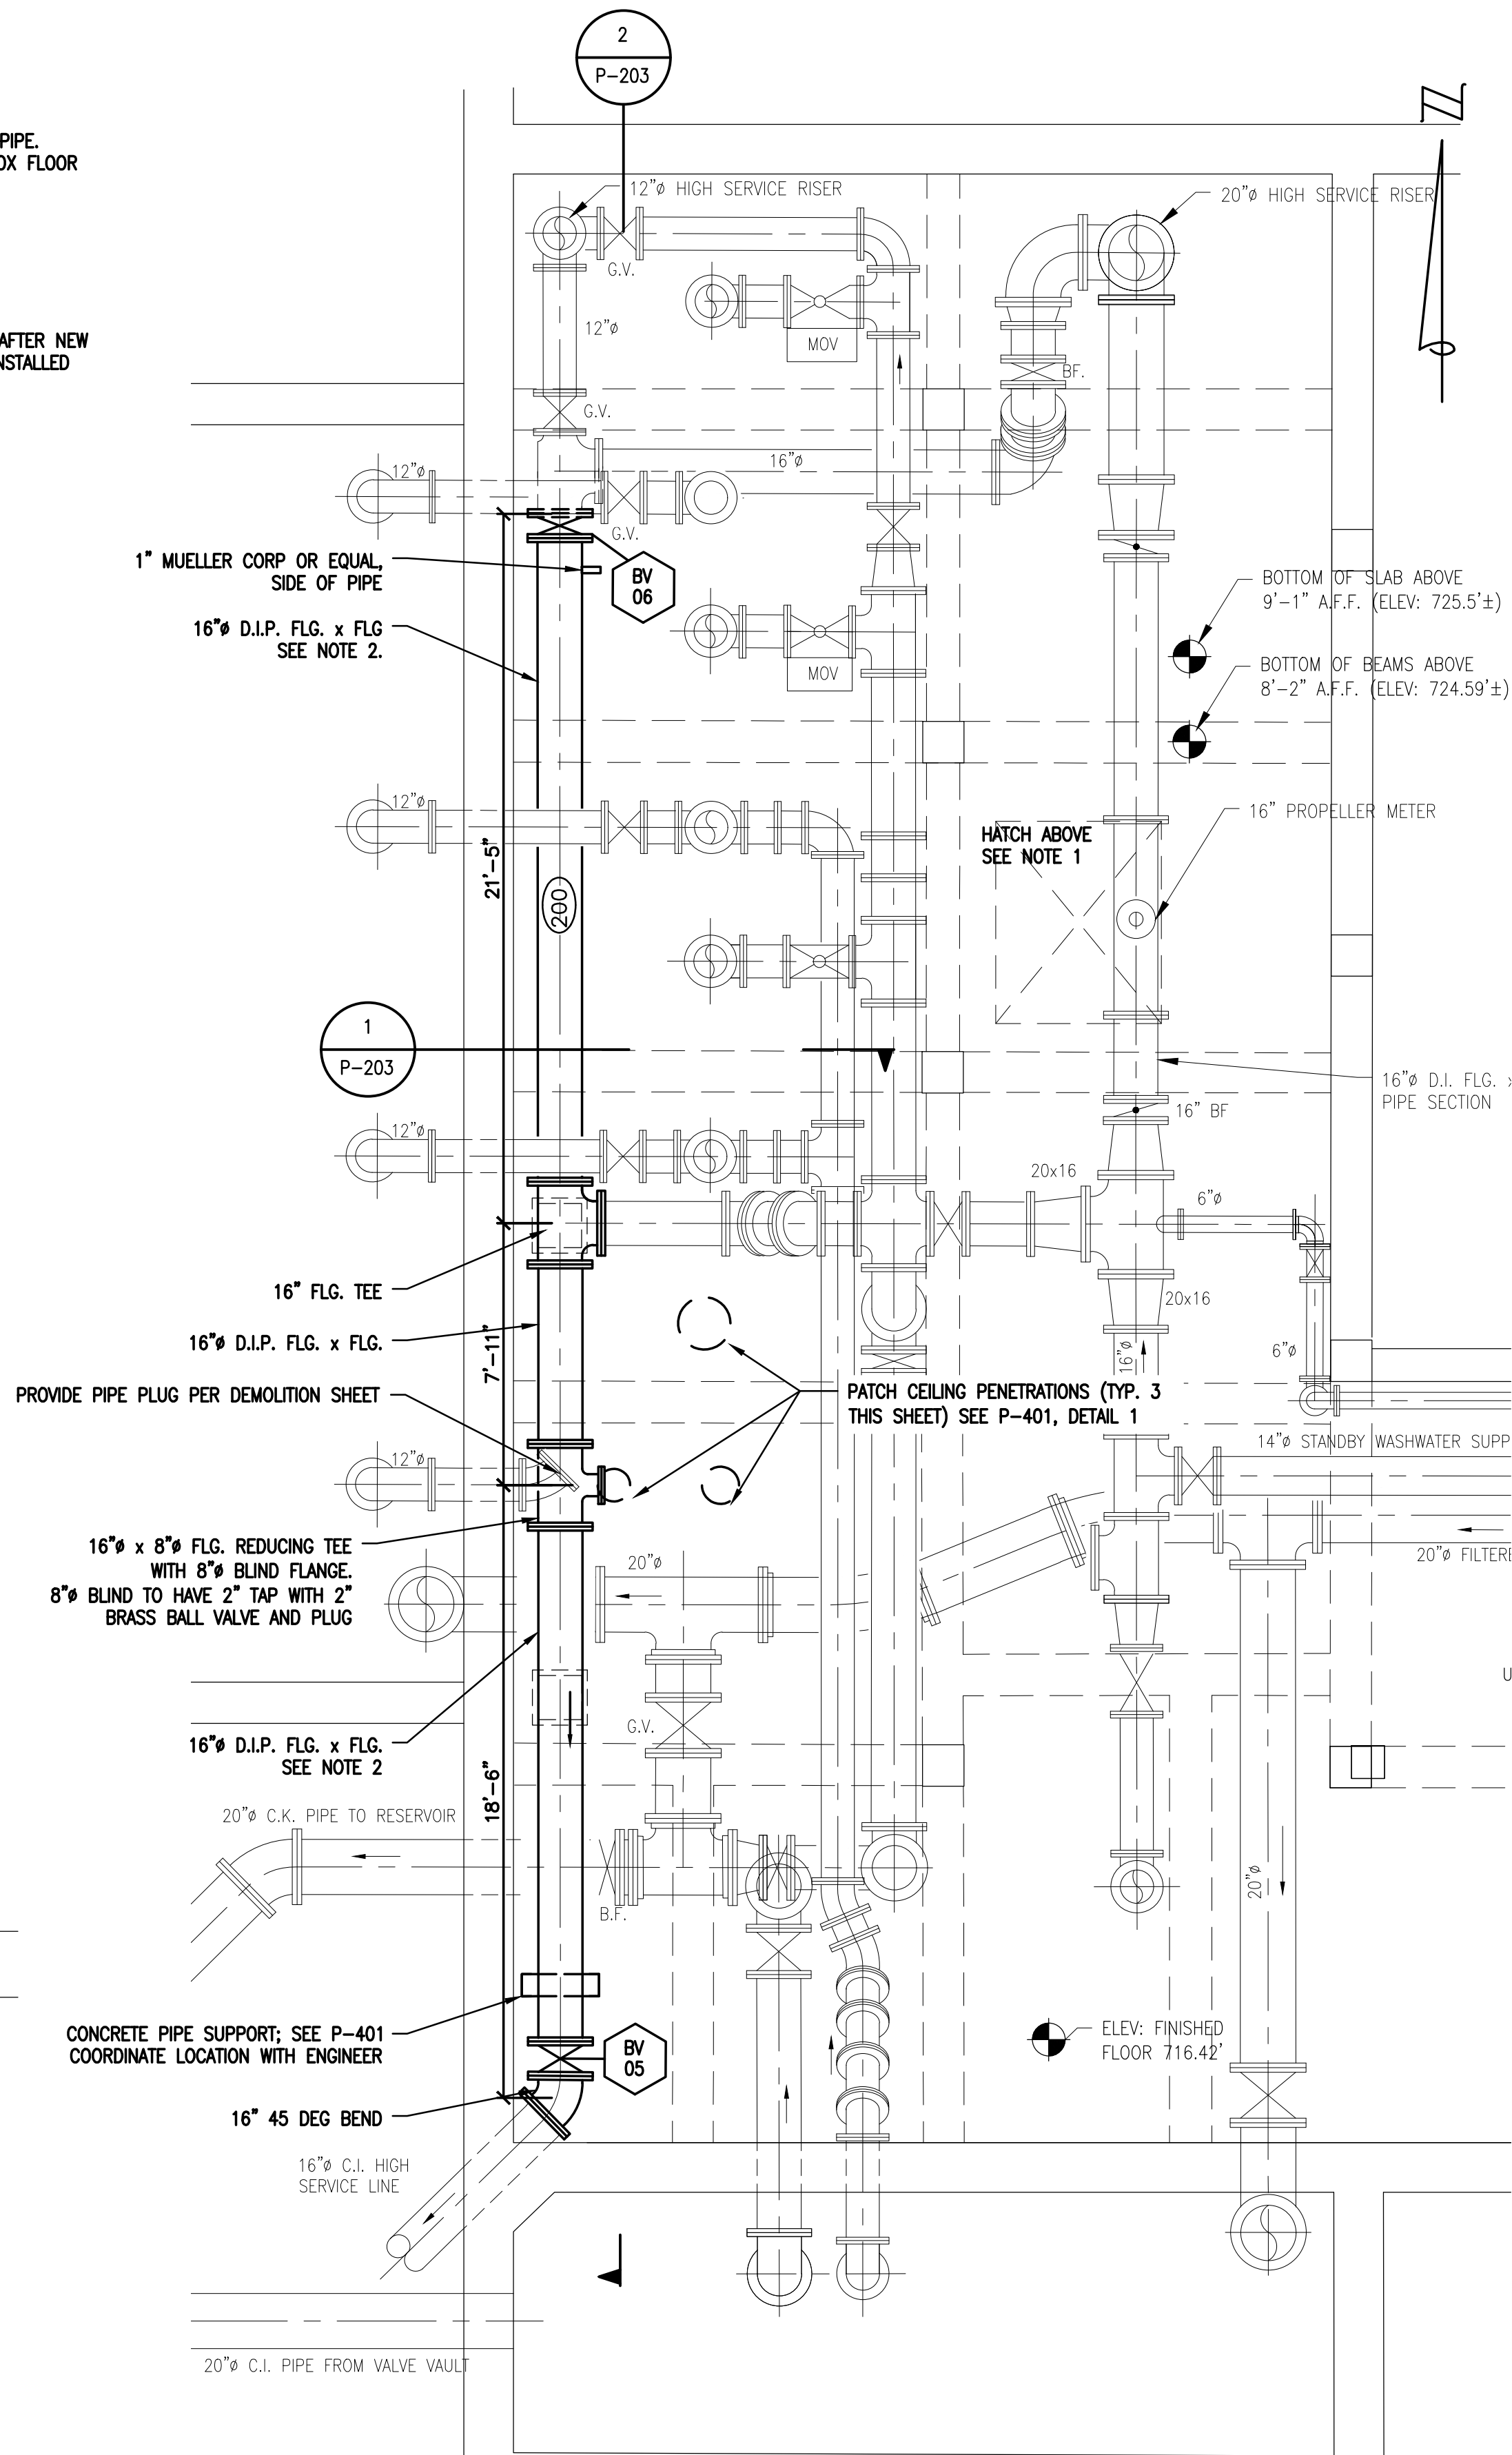

③ HIGH SERVICE PIPE PLAN
1/4" = 1'-0"

REVISIONS:
ISSUED FOR BIDS
12/16/2019

HORIZ DATUM
VERT DATUM
N/A

SCALE
V

CITY/VILLAGETOWNSHIP
OWOSSO

COUNTY
SHAWANEE

CADD
LM

PROJ MGR
JD

ENG
MK

DATE
02/23/2020

SHEET

CITY OF OWOSSO
WASH WATER PUMP & PIPING REPLACEMENT
HIGH SERVICE PIPE PLAN

P-203

COPYRIGHT 2016 OHM ALL DRAWINGS AND WRITTEN MATERIALS APPEARING HEREIN CONSTITUTE THE ORIGINAL AND UNPUBLISHED WORK OF OHM AND THE SAME MAY NOT BE DUPLICATED, DISTRIBUTED, OR DISCLOSED WITHOUT PRIOR WRITTEN CONSENT OF OHM

DRAWING PATH: \\ohm\dfs\corporate\Projects\0000_01\001\002\0150040_wtp_design_services\Drawings\Facilities\BOD\BODP-301 & 401.dwg Dec 16, 2019 - 12:22pm

VALVE SCHEDULE								
MARK	LOCATION	SERVICE	SIZE (INCHES)	TYPE	JOINTS	OPERATOR	ACCESSORIES	REMARKS
CS-01	WASH WATER PUMP WWP-1 DISCHARGE	WASH WATER	14	DOUBLE DOOR CHECK	W	L		
CS-02	WASH WATER PUMP WWP-2 SUCTION DISCHARGE	WASH WATER	14	DOUBLE DOOR CHECK	W	L		
BV-01	WASH WATER PUMP WWP-1 SUCTION	WASH WATER	14	BUTTERFLY	FJ	H		
BV-02	WASH WATER PUMP WWP-1 DISCHARGE	WASH WATER	14	BUTTERFLY	FJ	H		
BV-03	WASH WATER PUMP WWP-2 SUCTION	WASH WATER	14	BUTTERFLY	FJ	H		
BV-04	WASH WATER PUMP WWP-2 DISCHARGE	WASH WATER	14	BUTTERFLY	FJ	H		
BV-05	16" HIGH SERVICE DISCHARGE	HIGH SERVICE	16	BUTTERFLY	FJ	H		REPLACE (DISPOSE OF EXISTING)
BV-06	16" HIGH SERVICE DISCHARGE	HIGH SERVICE	16	BUTTERFLY	FJ	H		
BV-07	WASH WATER SUCTION	WASH WATER	14	BUTTERFLY	FJ	H		
BV-08	HIGH SERVICE WASH WATER CONNECTION	HIGH SERVICE WASH WATER	12	BUTTERFLY	FJ	CW		
PRV-01	HIGH SERVICE CONNECTION TO WASH WATER DISCHARGE	HIGH SERVICE WASH WATER	12	GLOBE	FJ	-	POSITION INDICATOR, ANTI-CAVITATION TRIM	PRESSURE REDUCING AND CHECK VALVE FUNCTIONS

INSTRUMENTATION SCHEDULE								
MARK	LOCATION	SERVICE	SIZE (INCHES)	TYPE	JOINTS	SCALE	ACCESSORIES	REMARKS
FM-0 [EXISTING]	WASH WATER PUMP DISCHARGE PIPING	WASH WATER	14	ORIFICE FLOW METER	W	0-5000 GPM		REMOVE AND DISPOSE OF EXISTING
FM-61	WASH WATER PUMP DISCHARGE PIPING	WASH WATER	14	MAGNETIC FLOW	FJ	0-6000 GPM	REMOTE TRANSMITTER W/MIN 60 FT CABLE	
PIT-61A	FILTER 1 DISCHARGE	FILTERED WATER	½" X 2	DIFFERENTIAL PRESSURE	SJ	0-14 FEET	LOOP POWERED REMOTE DISPLAY	
PIT-61B	FILTER 2 DISCHARGE	FILTERED WATER	½" X 2	DIFFERENTIAL PRESSURE	SJ	0-14 FEET	LOOP POWERED REMOTE DISPLAY	
PIT-61C	FILTER 3 DISCHARGE	FILTERED WATER	½" X 2	DIFFERENTIAL PRESSURE	SJ	0-14 FEET	LOOP POWERED REMOTE DISPLAY	
PIT-61D	FILTER 4 DISCHARGE	FILTERED WATER	½" X 2	DIFFERENTIAL PRESSURE	SJ	0-14 FEET	LOOP POWERED REMOTE DISPLAY	

PUMP SCHEDULE							
MARK	LOCATION	DUTY POINT	MOTOR SIZE	INLET PIPING	OUTLET PIPING	STYLE	REMARKS
WWP-1	FILTER PIPE GALLERY	4700 GPM @ 38' TDH	60 HP	14"	14"	HORIZONTAL END SUCTION	SEE SHEET P-201 FOR ALTERNATE FLANGE SIZE OPTION
WWP-2	COMPRESSOR ROOM	4700 GPM @ 38' TDH	60 HP	14"	14"	HORIZONTAL END SUCTION	SEE SHEET P-201 FOR ALTERNATE FLANGE SIZE OPTION

EXPOSED PIPING SCHEDULE						
MARK	LOCATION	SERVICE	SIZE (INCHES)	MATERIALS	JOINTS	TEST PRESSURE (PSIG)
100	WATER TREATMENT PLANT LOWER LEVEL	WASH WATER	14	DIP	FJ	60
200	WATER TREATMENT PLANT SUBBASEMENT	HIGH SERVICE DISCHARGE	16	DIP	FJ	150

VALVE JOINT

BSL BELL AND SPIGOT LEAD
FJ FLANGED JOINT
GC GROOVED COUPLING
MJ MECHANICAL JOINT
POJ PUSH-ON JOINT
SJ SCREWED JOINT
W WAFER
RFCA RESTRAINED FLANGED COUPLING ADAPTER

OPERATOR

BG BEVEL GEAR
C CRANK/HANDLES
CL CHAIN LEVER (LENGTH)
CW CHAIN WHEEL (LENGTH)
H HANDWHEEL
HO HYDRAULIC OIL
HW HYDRAULIC WATER
IL INFINITE LEVER
L LEVER
M MOTOR
P POSITIONER
PL POSITION LEVEL
POC PNEUMATIC CYLINDER
POD PNEUMATIC DIAPHRAGM
W WRENCH HEAD
WN WRENCH NUT

SLUICE GATE

TYPE
C CONVENTIONAL
SC SELF CONTAINED

BOTTOM

FB FLUSH BOTTOM
SB STANDARD BOTTOM

FRAME

FF FLAT FRAME
FLF FLANGE FRAME

ACCESSORIES

BS BENCH STANDS
CP CONTROL PACKAGE
EB EXTENSION BONNET (LENGTH)
ES EXTENSION STEM SHAFT (LENGTH)
FB FLOOR BOX (LENGTH)
FS FLOOR STAND
LS LIMIT SWITCH
MS MANUAL SCREW
OAS OIL ACCUMULATOR SYSTEM
PA PILOT ASSEMBLY
PI POSITION INDICATOR
PO PORTABLE OPERATOR
RPI REMOTE POSITION INDICATOR
SC STEM COVER
SG STEM GUIDE
THW "T" HANDLE WRENCH
VB VALVE BOX (LENGTH)
WB WALL BRACKET
WG WORM GEAR

REMARKS

CL CLASS
FC FAIL CLOSE
FO FAIL OPEN
GB GROUND BURIED
NRS NONRISING STEM
OS OPEN SHUT
RS RISING STEM
TH THROTTLING TYPE

SLIDE GATE TYPE

A ALUMINUM
FG FIBERGLASS
SS STAINLESS STEEL FRAME

PIPEWORK SCHEDULE KEY

GENERAL

THE FOLLOWING PIPE SCHEDULE GIVES THE DESIGNATION FOR EACH PIPE LINE, PIPE SIZE, JOINT, MATERIAL, SERVICE AND OTHER PERTINENT DATA. THE KEY OF SYMBOLS FOR THE SCHEDULE IS AS FOLLOWS: PIPE MATERIAL

PROCESS PIPING

BSP BLACK STEEL PIPE
CSIP CHROME SILICON IRON PIPE
DIP DUCTILE IRON PIPE
FRP FIBERGLASS REINFORCED PIPE
GSP GALVANIZED STEEL PIPE
HDP HIGH DENSITY POLYETHYLENE
PVC PLASTIC PIPE
PCCP PRESTRESSED CONCRETE CYLINDER PIPE
RCPP REINFORCED CONCRETE PRESSURE PIPE
SSP STAINLESS STEEL PIPE
SPP STEEL PLATE PIPE
HSP HIGH PRESSURE STEEL PIPE

REMARKS

CL CLASS

PIPE JOINTS

AFC ADAPTER FLANGE COUPLING
BFC BOLTED FLEXIBLE COUPLING
BSC BELL AND SPIGOT CONCRETE
BSL BELL AND SPIGOT LEAD
BSS BELL AND SPIGOT STEEL
FJ FLANGED JOINT
GC GROOVED COUPLING
MJ MECHANICAL JOINT
POJ PUSH-ON JOINT
SJ SCREWED JOINT
STJ SOCKET TYPE JOINT
WJ WELDED JOINT
FWJ FIELD WELDED JOINT



ARCHITECTS ENGINEERS PLANNERS

34000 Plymouth Road
Livonia, MI 48150
P (734) 522-6711 | F (734) 522-6427

OHM-ADVISORS.COM

ISSUED FOR BIDS

12/16/2019

REVISIONS:

DATE

PROJ NUMBER

ENG

020319-0490

MK

PROJ MGR

JD

CADD

LM

COUNTY

SHAWASSEE

CITY/VILLAGE/TOWNSHIP

OWOSSO

HORIZ DATUM

N/A

VERT DATUM

N/A

SCALE

V

H

CITY OF OWOSSO

 
WASH WATER PUMP & PIPING REPLACEMENT

PUMP, VALVE & PIPE SCHEDULES

SHEET

P-301

COPYRIGHT 2016 OHM. ALL DRAWINGS AND WRITTEN MATERIALS APPEARING HEREIN CONSTITUTE THE ORIGINAL AND UNPUBLISHED WORK OF OHM AND THE SAME MAY NOT BE DUPLICATED, DISTRIBUTED, OR DISCLOSED WITHOUT PRIOR WRITTEN CONSENT OF OHM.




- ## 2 WALL PENETRATION DETAIL
- NOT TO SCALE



- ### 3 WALL PENETRATION – MECHANICAL SEAL



 - 5 ADJUSTABLE SUPPORT
NOT TO SCALE



- 7 PIPE SUPPORT BASE ELBOW DETAIL
NOT TO SCALE



- #### 4 PRESSURE GAUGE TAP DETAIL



- 10 EQUIPMENT PAD DETAIL
NOT TO SCALE





ELEC. ABBREVIATIONS

SPECIAL Ø	PHASE
A	AMPERE
AFF	ABOVE FINISHED FLOOR
C	CONDUIT
CAT	CATALOGUE
CB	CIRCUIT BREAKER
CMU	CONCRETE MASONRY UNIT
CO.	COMPANY
CUH	CABIN UNIT HEATER
E	
EC	ELECTRICAL CONTRACTOR
EF	EXHAUST FAN
EWC	ELECTRIC WATER COOLER
F	
FA	FIRE ALARM
G	
GFCI	GROUND FAULT CIRCUIT INTERRUPTER
GND	EQUIPMENT GROUND
H	
HID	HIGH INTENSITY DISCHARGE
HPS	HIGH PRESSURE SODIUM
HVAC	HEATING VENTILATION & AIR CONDITIONING
K	
K	KEY OPERATED DEVICE
KVA	KILOVOLT-AMPERES
KW	KILO-WATTS
L	
LED	LIGHT EMITTING DIODE
M	
MCB	MAIN CIRCUIT BREAKER
MDP	MAIN DISTRIBUTION PANEL
MH	METAL HALIDE
MISC	MISCELLANEOUS
MLO	MAIN LUG ONLY
MTD	MOUNTED
N	
NEU	NEUTRAL
NO	NUMBER
P	
PL	PILOT
R	
RECP	RECEPTACLE
T	
TEL	TELEPHONE
TRANS	TRANSFORMER
TV	TELEVISION
TYP	TYPICAL
U	
UGE	UNDERGROUND ELECTRIC
UH	UNIT HEATER
UNO	UNLESS NOTED OTHERWISE
V	
V	VOLT
VA	VOLT-AMPERES
W	
W	WIRE
WNC	WIRELESS NETWORK CONTROLLER
WP	WEATHERPROOF

GENERAL NOTES - ELECTRICAL

1. ALL ELECTRICAL INSTALLATIONS SHALL BE IN ACCORDANCE WITH THE CURRENT NATIONAL ELECTRICAL CODE AND ANY STATE/LOCAL AMENDMENTS.
2. THE ELECTRICAL CONTRACTOR SHALL BE RESPONSIBLE FOR THE ACQUISITION OF AN ELECTRICAL PERMIT AND SCHEDULING OF THE NECESSARY INSPECTIONS. UPON COMPLETION OF THE WORK THE ELECTRICAL CONTRACTOR SHALL PROVIDE THE OWNER EVIDENCE OF INSPECTION APPROVAL.
3. THE ELECTRICAL CONTRACTOR SHALL BE RESPONSIBLE FOR ALL COORDINATION REQUIRED WITH THE ELECTRIC UTILITY SERVING THE FACILITY. UTILITY COSTS SHALL BE PAID SEPARATELY BY THE OWNER.

ELECTRICAL LEGEND

LIGHT FIXTURES
--



OHM ®

ARCHITECTS ENGINEERS PLANNERS

34000 Plymouth Road
Livonia, MI 48150
P (734) 522-6711 | F (734) 522-6427

OHM-ADVISORS.COM

[illegible]


DATE	PROJ NUMBER	ENG	PROJ MR	CADD	COUNTY	CITY/VILLAGE/TOWNSHIP	H.	NTS	V.	NTS	HORIZ DATUM	VERT DATUM
	020219-0400	WK	JD	LM	SHAWANSEE	OWOSSO					NA	NA

CITY OF OWOSSO

WASH WATER PUMP & PIPING REPLACEMENT

GENERAL ELECTRICAL INFORMATION

DRAWING PATH: \\ohm\dfs\Corporate\Projects\0000_0100\020190040_wfp_desig_services\Drawings\Facilities\Sheets\190040E-202.DWG Des: 16, 2019 - 11:52am

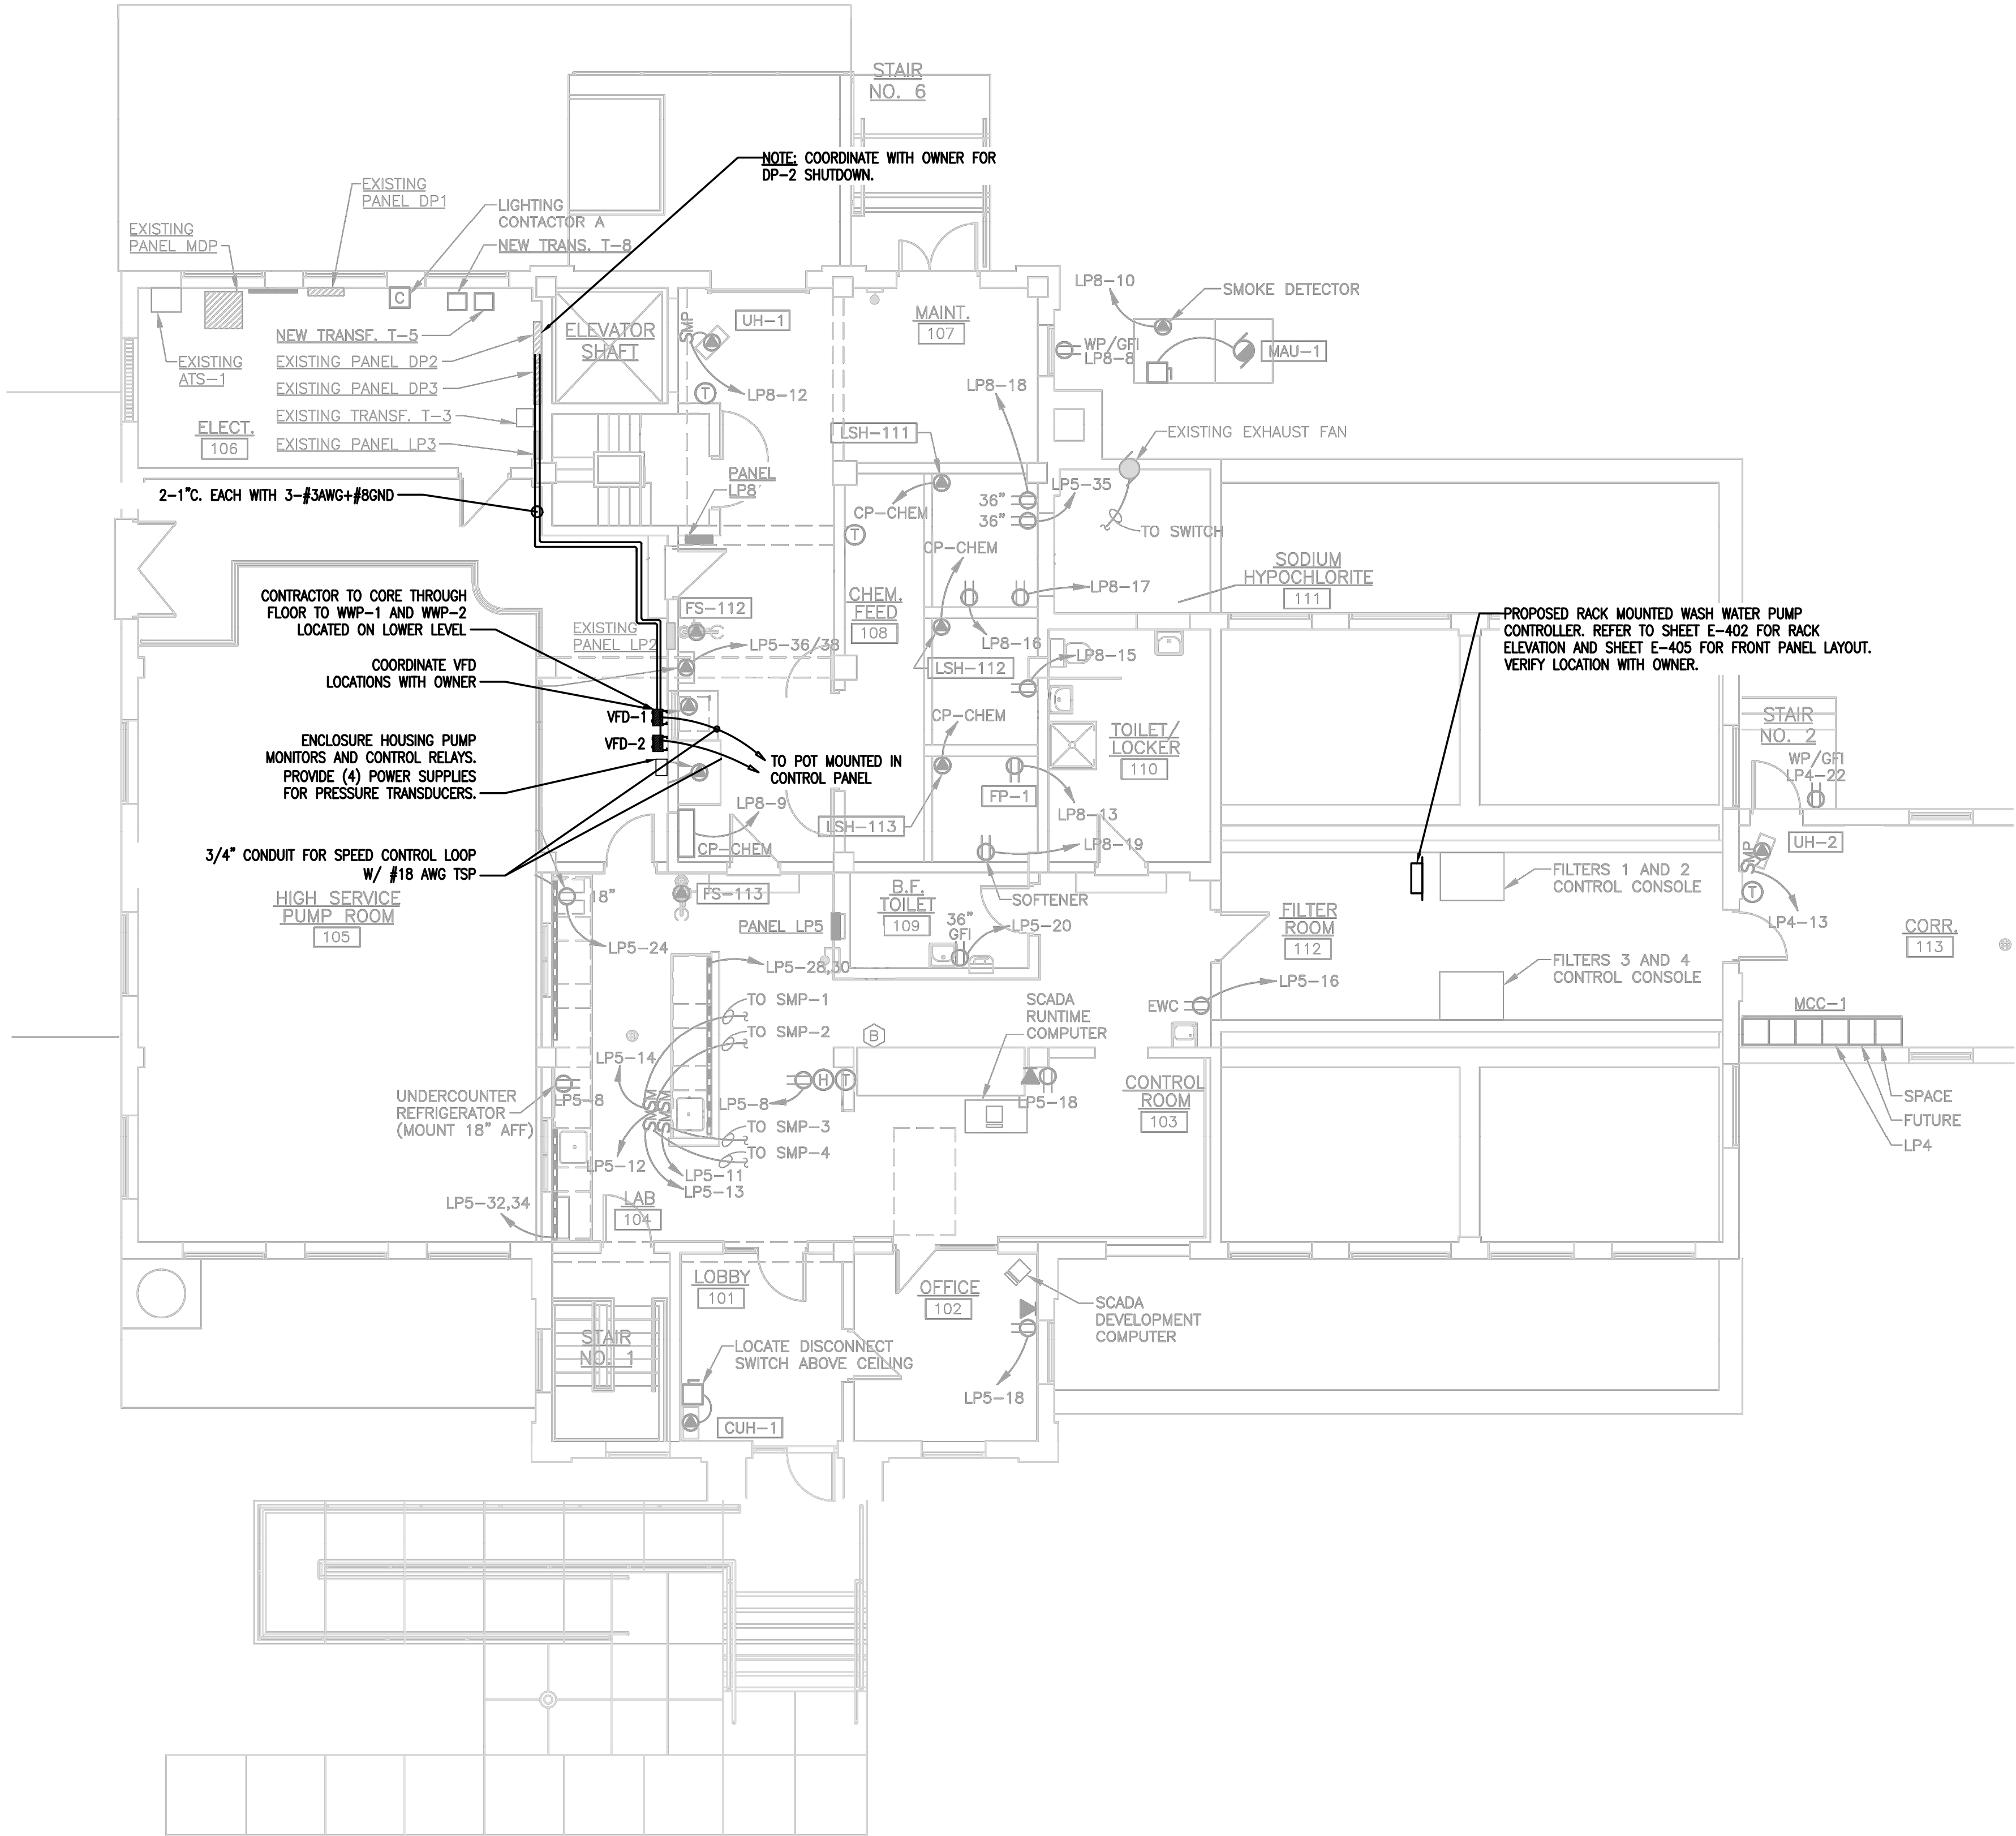

1 UPPER LEVEL POWER PLAN
1/8" = 1'-0"


REVISIONS:	12/16/2019
ISSUED FOR BIDS	12/16/2019

DATE	PROJ NUMBER	ENG	PROJ MGR	CADD	COUNTY	CITY/VILAGE/TOWNSHIP	SCALE	H	V	NTS	HORIZ DATUM	VERT DATUM
	0003-19-040	MK	JD	LM	SHAWANSEE	OWOSSO						
CITY OF OWOSSO WASH WATER PUMP & PIPING REPLACEMENT UPPER LEVEL POWER PLAN												

SHEET	E-202
-------	-------

COPYRIGHT 2016 OHM ALL DRAWINGS AND WRITTEN MATERIALS APPEARING HEREIN CONSTITUTE THE ORIGINAL AND UNPUBLISHED WORK OF OHM AND THE SAME MAY NOT BE DUPLICATED, DISTRIBUTED, OR DISCLOSED WITHOUT PRIOR WRITTEN CONSENT OF OHM

DRAWING PATH: \\camdia\Corporate\Projects\0000_0100\0020190040_wip_desig_services\Drawings\Facilities\Sheets\190040E-401A.DWG Dec 16, 2019 - 11:52am

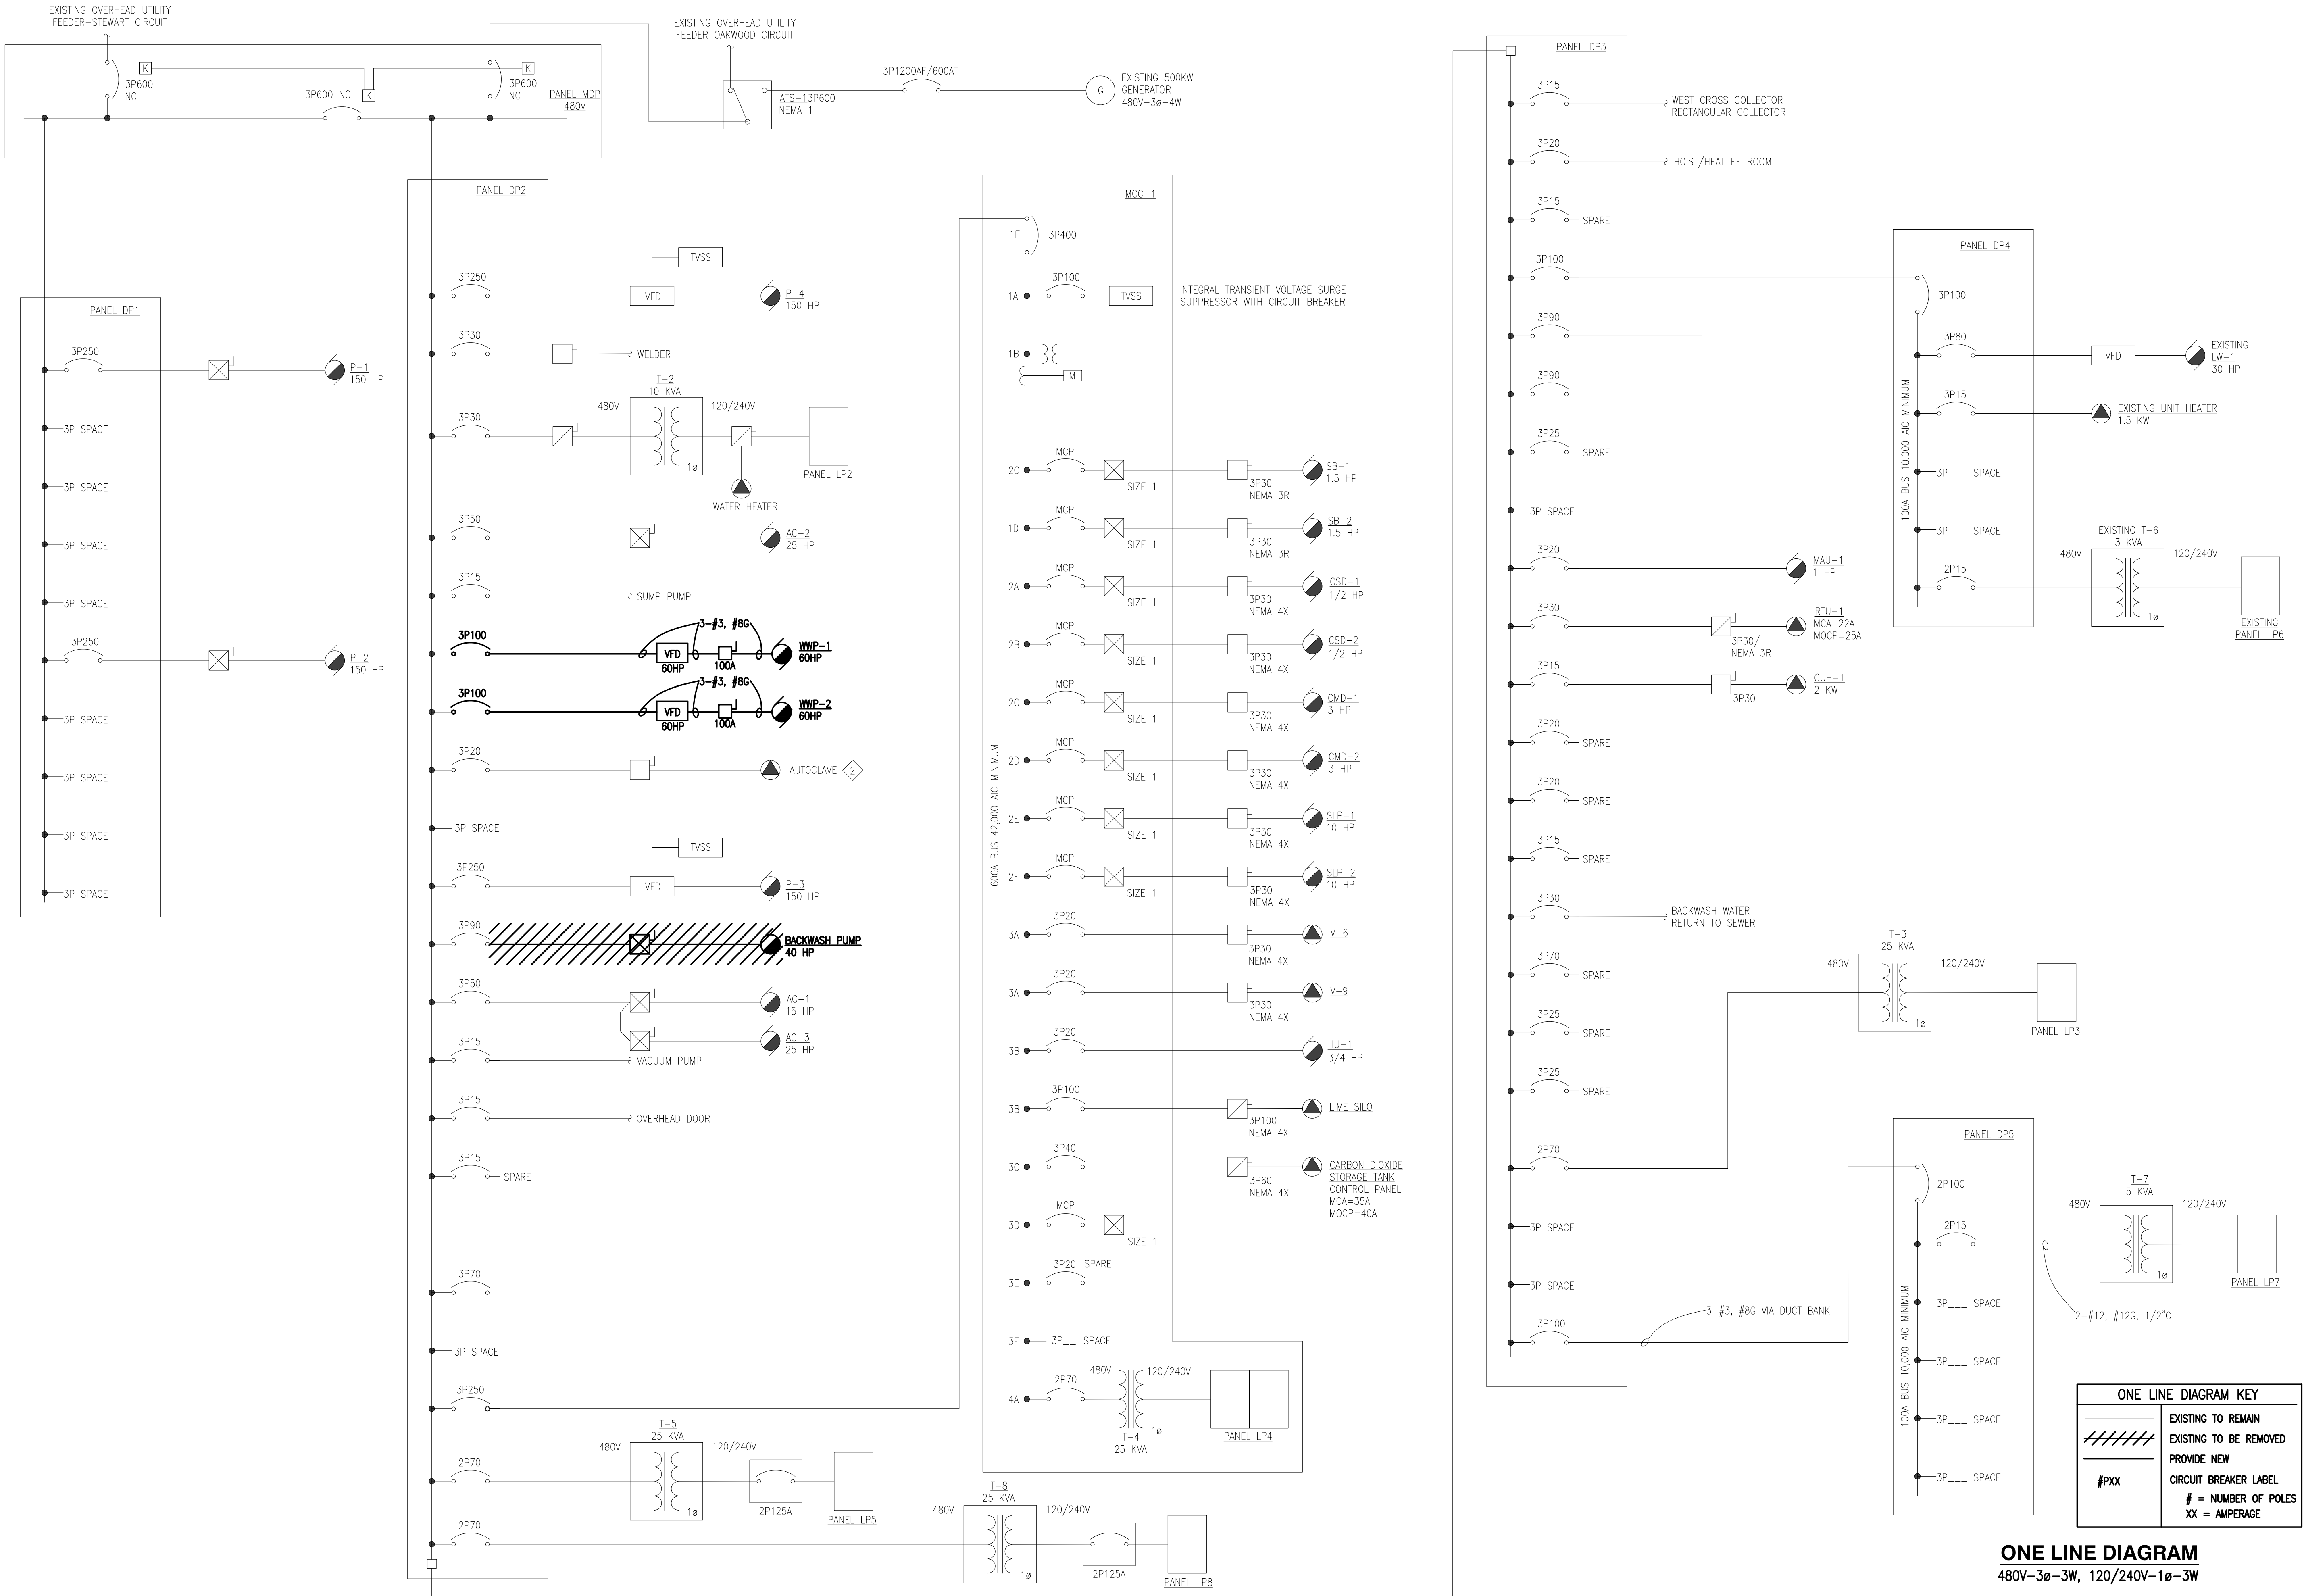

REVISIONS:
12/16/2019
ISSUED FOR BIDS


CITY OF OWOSSO
WASH WATER PUMP & PIPING REPLACEMENT
PROPOSED ONE-LINE DIAGRAM

SHEET
E-401


COPYRIGHT 2016 OHM ALL DRAWINGS AND WRITTEN MATERIALS APPEARING HEREIN CONSTITUTE THE ORIGINAL AND UNPUBLISHED WORK OF OHM AND THE SAME MAY NOT BE DUPLICATED, DISTRIBUTED, OR DISCLOSED WITHOUT PRIOR WRITTEN CONSENT OF OHM

DRAWING PATH: \\camudio\Corporate\Projects\0000_0100\0020190040_wfp_desig_services\Drawings\Facilities\00040E-402.DWG Des:16, 2019 - 11:52am

4 E-STOP WIRING DIAGRAM (TYP FOR 2)
NO SCALE

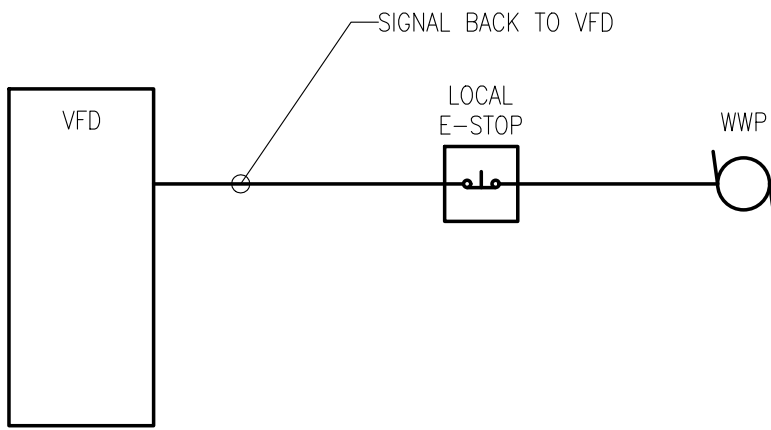


2 WASH WATER PUMP CONTROLLER RACK DETAIL
NOT TO SCALE

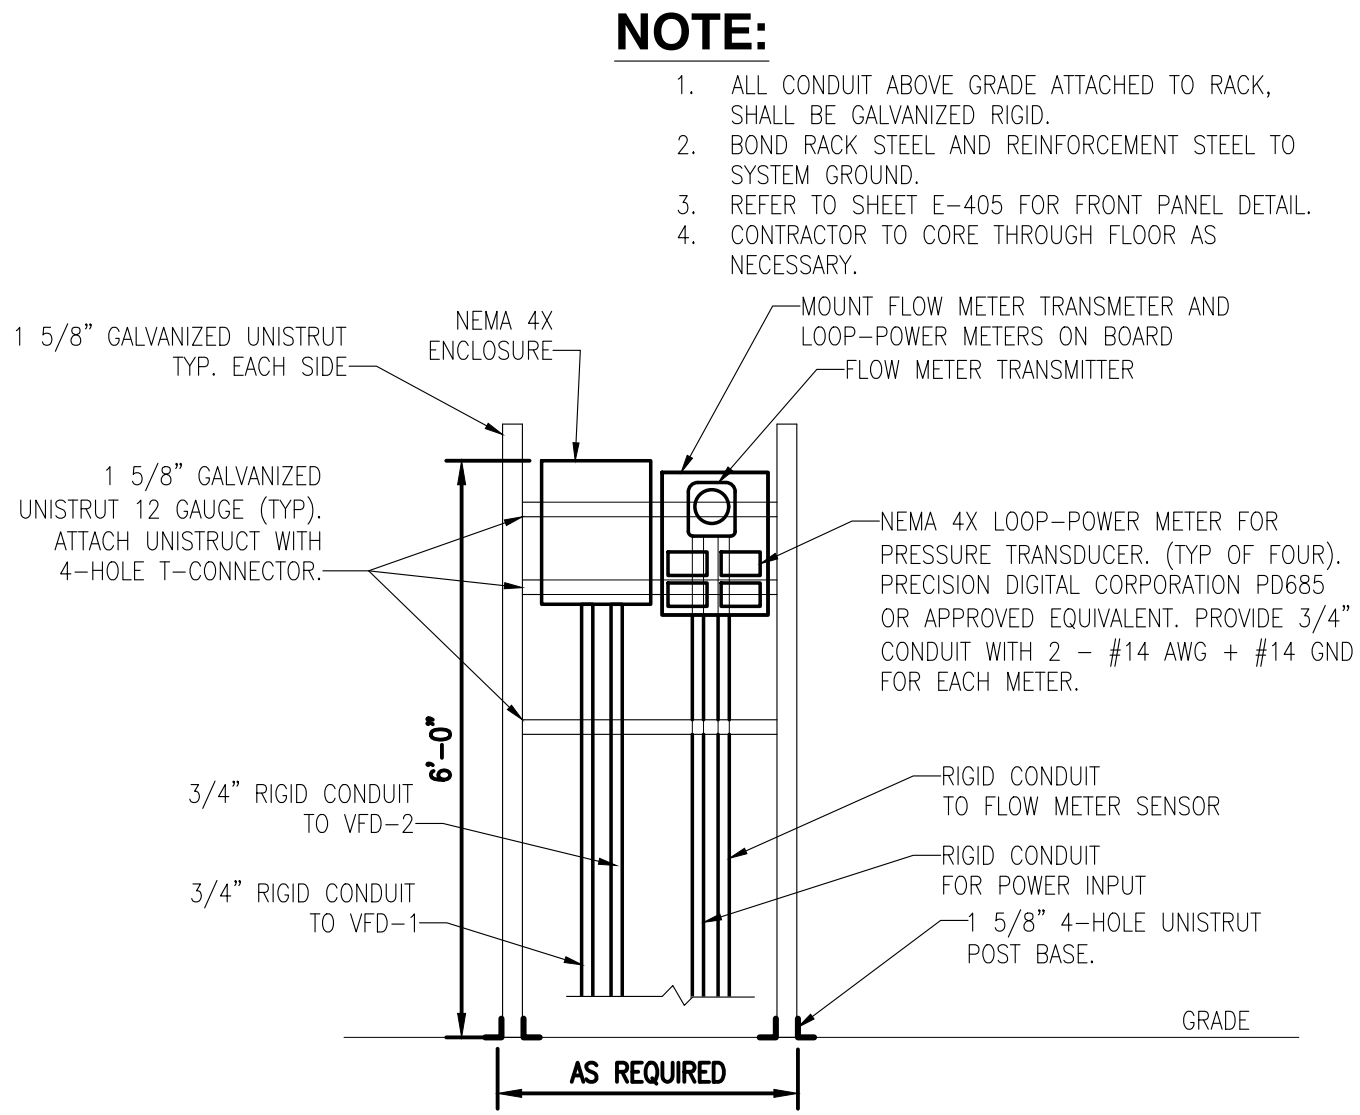


NOTE:

1. ALL CONDUIT ABOVE GRADE ATTACHED TO RACK, SHALL BE GALVANIZED RIGID.
2. BOND RACK STEEL AND REINFORCEMENT STEEL TO SYSTEM GROUND.
3. REFER TO SHEET E-405 FOR FRONT PANEL DETAIL.
4. CONTRACTOR TO CORE THROUGH FLOOR AS NECESSARY.

3 CONTROL INTERCONNECTION DIAGRAM
NO SCALE

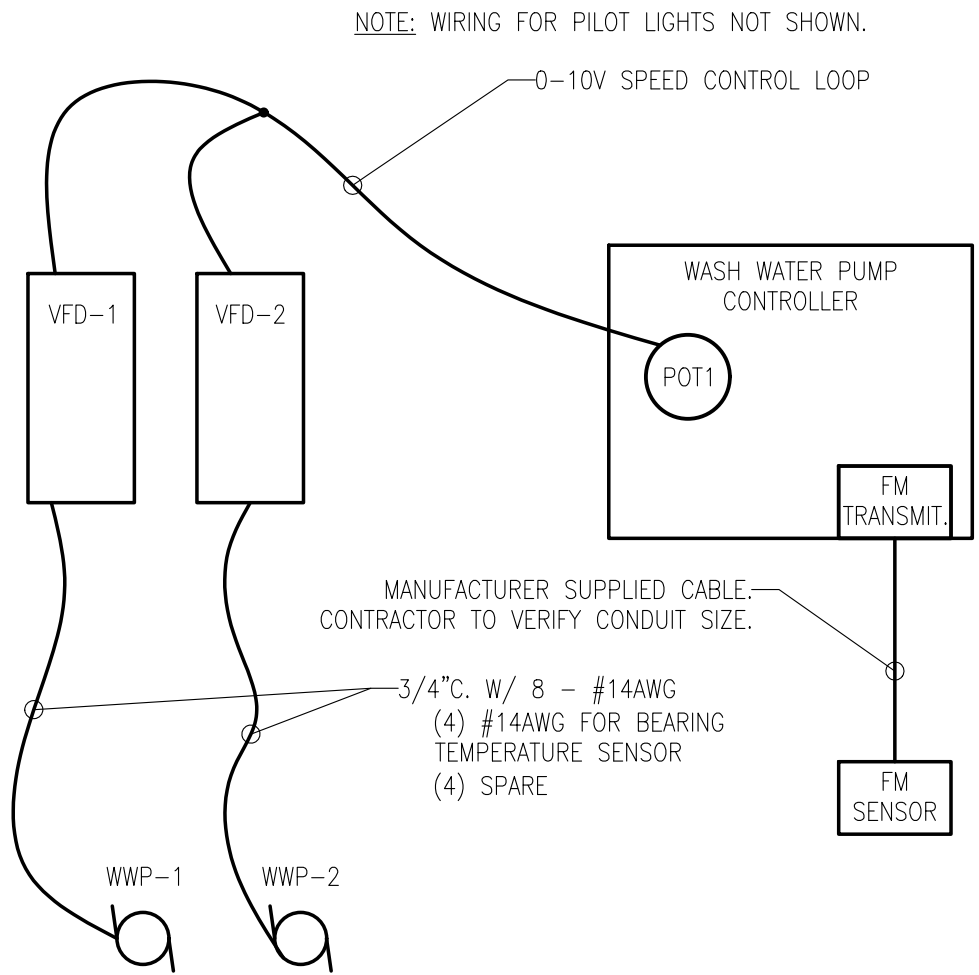

1 MAG METER WIRING DIAGRAM
NO SCALE

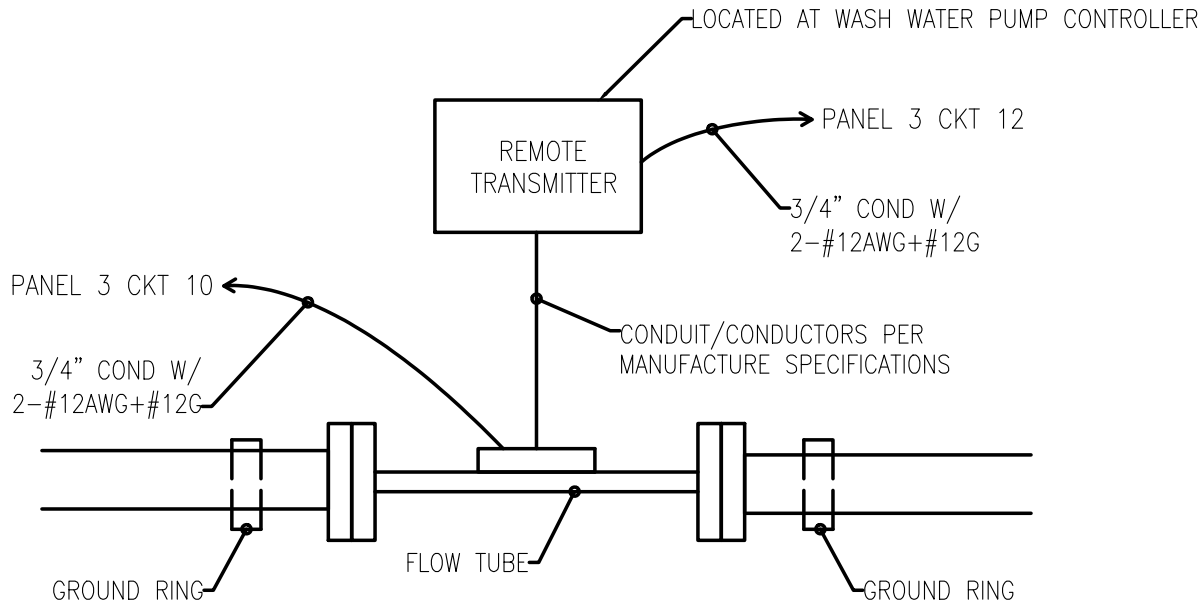

PANEL 3							DESCRIPTION: EXISTING PANEL SURFACE MOUNT, 120/240V, 1φ, 100A, MCB, 24 CIRCUIT									
IDENTIFICATION	KVA LOAD		WIRE	POLE	AMP	CIRCUIT	CIRCUIT	AMP	POLE	WIRE	KVA LOAD		IDENTIFICATION			
	A	B									B	A				
CHLORINE RM	1.92		EX.	1	20	1	2	20	1	EX.	1.92		LIGHTS			
SUMP PUMP		1.92	EX.	1	20	3	4	20	1	EX.		1.92	ELECTRICAL ROOM RECEPTS			
BLOCK HEATER	1.44		EX.	2	15	5	6	20	1	EX.	1.92		LIGHTS			
		1.44				7	8	20	1	EX.		1.92	CHARGER			
CONTROL POWER	—		#12	1	20	9	10	20	1	#12	—		FLOW METER SENSOR			
DISCONNECT RELAY POWER — DR1		—	#14	1	15	11	12	20	1	#12		—	FLOW METER TRANSMITTER			
DISCONNECT RELAY POWER — DR2	—		#14	1	15	13	14	20	1	#12	—		PRESSURE TRANSDUCER #1			
SPACE		—	—	—	—	15	16	20	1	#12		—	PRESSURE TRANSMITTER #2			
SPACE	—		—	—	—	17	18	20	1	#12	—		PRESSURE TRANSDUCER #3			
SPACE		—	—	—	—	19	20	20	1	#12	—		PRESSURE TRANSDUCER #4			
SPACE	—		—	—	—	21	22	—	—	—			SPACE			
SPACE		—	—	—	—	23	24	—	—	—			SPACE			
CONNECTED LOAD	3	3									4	4	CONNECTED LOAD			

DP2				DESCRIPTION: EXISTING PANEL SURFACE MOUNT, 480V, 3φ, 3W, 800A, MLO, 63 CIRCUIT											
IDENTIFICATION	KVA LOAD			WIRE	POLE	AMP	CIRCUIT	CIRCUIT	AMP	POLE	WIRE	KVA LOAD			IDENTIFICATION
	A	B	C									C	B	A	
PUMP 3	96			EX.	3	250	1	2				-			MAIN LUGS
		96					3								
			96				5	4	800	3	EX.		-		
BACKWASH PUMP	0.00			EX.	3	40	7	6						-	
		0.00					9								
			0.				11								
AIR COMP. 1 AND 3	19.2			EX.	3	50	13	8				96			PUMP 4
		19.2					15	10	250	3	EX.		96		
			19.2				17	12					96		
VACUUM PUMP	5.8			EX.	3	15	19	14				11.5			WELDER
		5.8					21	16	30	3	EX.		11.5		
			5.8				23	18					11.5		
WWP-1	36.96						25	20				15			PANEL 2 XFMR
		36.96		#3	3	100	27	22	30	2	EX.		15		
			36.96				29	24					19.2		
WWP-2	36.96						31	26	50	3	EX.	19.2			AIR COMP. 2
		36.96		#3	3	100	33	28				19.2			
			36.96				35	30					5.8		
INACTIVE	-			-	2	70	37	32	15	3	EX.	5.8			SUMP PUMP
		-					39	34					5.8		
			26.9	EX.	2	70	41	36						-	
LP-5	26.9						43	38	15	3	EX.	-			INACTIVE
		7.7					45	40					-		
			7.7	EX.	3	20	47	42					-		
AUTO CLAVE	7.7						49	44	15	3	EX.	-			INACTIVE
		96					51	46					-		
			96	EX.	3	250	53	48					-		
MCC	96						55	50	-	-	-	-			SPACE
		26.9		EX.	3	70	57	52					-		
			26.9				59	54					-		
SPACE	-			-	-	-	61	56	-	-	-	-			SPACE
		-					63	58					-		
CONNECTED LOAD	326	326	352									148	148	133	CONNECTED LOAD

REVISIONS:
ISSUED FOR BIDS
12/16/2019

DATE
PROJ NUMBER
PROJ INGR
ENG
MK
0020190040

CITY/VILLAGE/TOWNSHIP
OWOSSO

COUNTY
SHAWANSEE

CADD
LM

SCALE
V

NTS

SCALE
H

NTS

SCALE
V

NTS

SCALE
H

NTS

SCALE
V

NTS

SCALE
H

NTS

SCALE
V

NTS

SCALE
H

NTS

SCALE
V

NTS

SCALE
H

NTS

SCALE
V

NTS

SCALE
H

NTS

SCALE
V

NTS

SCALE
H

NTS

SCALE
V

NTS

SCALE
H

NTS

SCALE
V

NTS

SCALE
H

NTS

SCALE
V

NTS

SCALE
H

NTS

SCALE
V

NTS

SCALE
H

NTS

SCALE
V

NTS

SCALE
H

NTS

SCALE
V

NTS

SCALE
H

NTS

SCALE
V

NTS

SCALE
H

NTS

SCALE
V

NTS

SCALE
H

NTS

SCALE
V

NTS

SCALE
H

NTS

SCALE
V

NTS

SCALE
H

NTS

SCALE
V

NTS

SCALE
H

NTS

SCALE
V

NTS

SCALE
H

NTS

SCALE
V

NTS

SCALE
H

NTS

SCALE
V

NTS

SCALE
H

NTS

SCALE
V

NTS

SCALE
H

NTS

SCALE
V

NTS

SCALE
H

NTS

SCALE
V

NTS

SCALE
H

NTS

SCALE
V

NTS

SCALE
H

NTS

SCALE
V

NTS

SCALE
H

NTS

SCALE
V

NTS

SCALE
H

NTS

SCALE
V

NTS

SCALE
H

NTS

SCALE
V

NTS

SCALE
H

NTS

SCALE
V

NTS

SCALE
H

NTS

SCALE
V

NTS

SCALE
H

NTS

SCALE
V

NTS

SCALE
H

NTS

SCALE
V

NTS

SCALE
H

NTS

SCALE
V

NTS

SCALE
H

NTS

SCALE
V

NTS

SCALE
H

NTS

SCALE
V

NTS

SCALE
H

NTS

SCALE
V

NTS

SCALE
H

NTS

SCALE
V

NTS

SCALE
H

NTS

SCALE
V

NTS

SCALE
H

NTS


SCALE
V

NTS

SCALE
H

NTS

DRAWING PATH: \\camudio\Corporate\Projects\0000_0100\020190040_wip_desig_services\Drawings\Facilities\Sheets\190040E-403.DWG Dec 16, 2019 - 11:53am

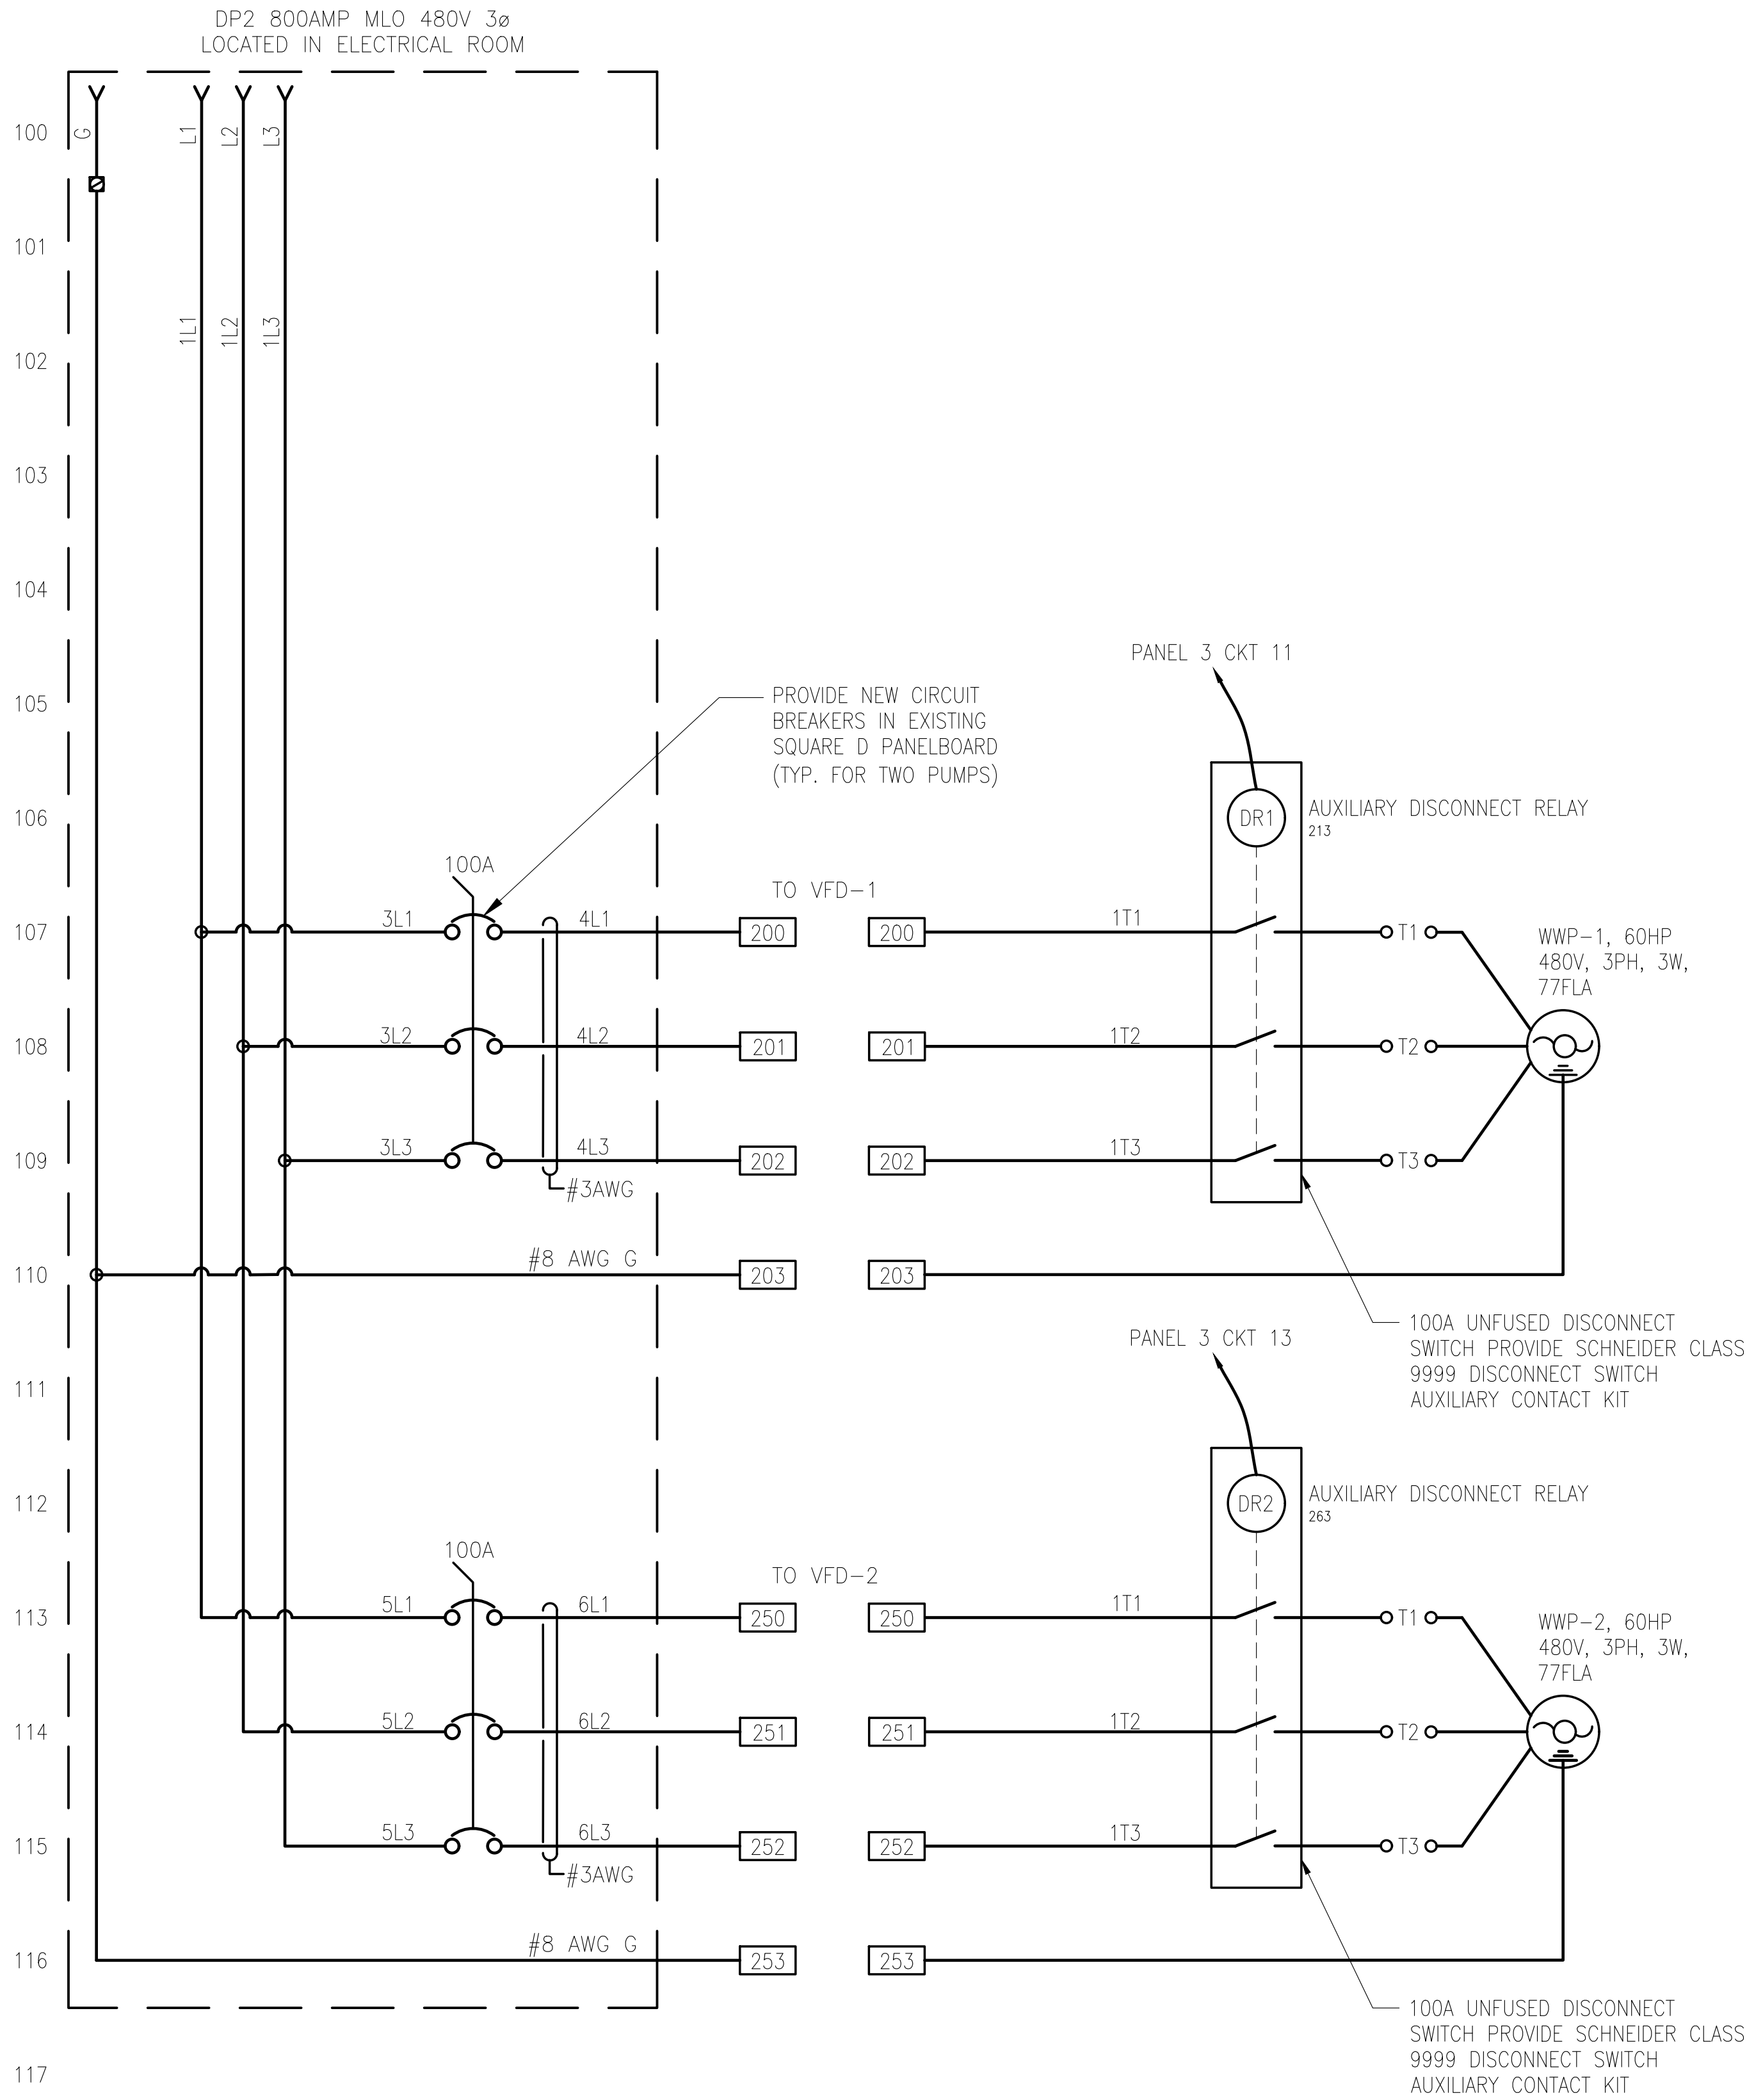

PARTS LIST

ITEM #	QTY.	DESCRIPTION	MANUFACTURER	CATALOG #	P&ID DESIGNATION
1	2	VARIABLE FREQUENCY DRIVES	SCHNEIDER	ATV630	VFD/61A & VFD/61B
2	2	MOTOR DISCONNECT WITH AUX CONTACT			
3	1	PUMP ALTERNATOR	ALLEN-BRADLEY	700-HTA1A1	YS/61
4	5	PILOT LIGHTS PTT	ALLEN-BRADLEY	800H-QTRH2	YL/61, YA/61A, YL/61A & YA/61B, YL/61B
5	1	POTENTIOMETER	SCHNEIDER ELECTRIC	XB4BD912R#K	SK/61
6	2	EMERGENCY STOP BUTTONS	ALLEN-BRADLEY	800H-TFRXJETA	HS/61A & HS/61B
7	1	FLOW METER	REFER TO SPECS		FIT/61
8	1	START PUSH BUTTON	ALLEN-BRADLEY	800H-B103W	HK/61
9	1	STOP PUSH BUTTON	ALLEN-BRADLEY	800H-B604W	HK/61
10	1	120V/24V TRANSFORMER	SQUARE D	9070E071D7	
11	2	PUMP MONITOR			
12	4	LOOP POWERED INDICATOR - PRESSURE TANSDUCERS	PRECISION DIGITAL	PD685	FOR REMOTE READ OUT OF PRESSURE TRANSDUCERS

NOTE: EQUIVALENT EQUIPMENT IS ACCEPTABLE, AS APPROVED BY ENGINEER

SEQUENCE OF OPERATION

1. USER INITIATES PUMP TO START BY WAY OF PUSH BUTTON (START) AT WASH WATER PUMP CONTROL STATION.
2. ONCE THE "CONTROL INITIATED PILOT LIGHT" IS ILLUMINATED, USER MAY CONTROL THE MOTOR SPEED VIA LOCAL POTENTIOMETER.
3. ONCE FILTER(S) ARE SATISFACTORILY WASHED. USER STOPS PUMP BY WAY OF PUSH BUTTON (STOP) AT CONTROL STATION.

RELAY ABBREVIATIONS

ADRR AUXILIARY DRIVE RUNNING RELAY
ADTR AUXILIARY DRIVE TRIP RELAY
CR CONTROL RELAY
DR DISCONNECT RELAY
RR RUN RELAY



OHM

ARCHITECTS ENGINEERS PLANNERS

34000 Plymouth Road
Livonia, MI 48150
P (734) 522-6711 | F (734) 522-6427

OHM-ADVISORS.COM

REVISIONS:

ISSUED FOR BIDS

12/16/2019

|||||

CITY OF OWOSSO

WASH WATER PUMP & PIPING REPLACEMENT


PUMP MOTOR AND VFD WIRING DIAGRAM

SHEET

E-403


COPYRIGHT 2016 OHM ALL DRAWINGS AND WRITTEN MATERIALS APPEARING HEREIN CONSTITUTE THE ORIGINAL AND UNPUBLISHED WORK OF OHM AND THE SAME MAY NOT BE DUPLICATED, DISTRIBUTED, OR DISCLOSED WITHOUT PRIOR WRITTEN CONSENT OF OHM

DRAWING PATH: \\admin\dfs\Corporate\Projects\0000_0100\02019040_vfp_design_services\Drawings\facilities\Sheet19040E-403.DWG Dec 16, 2019 - 11:53am

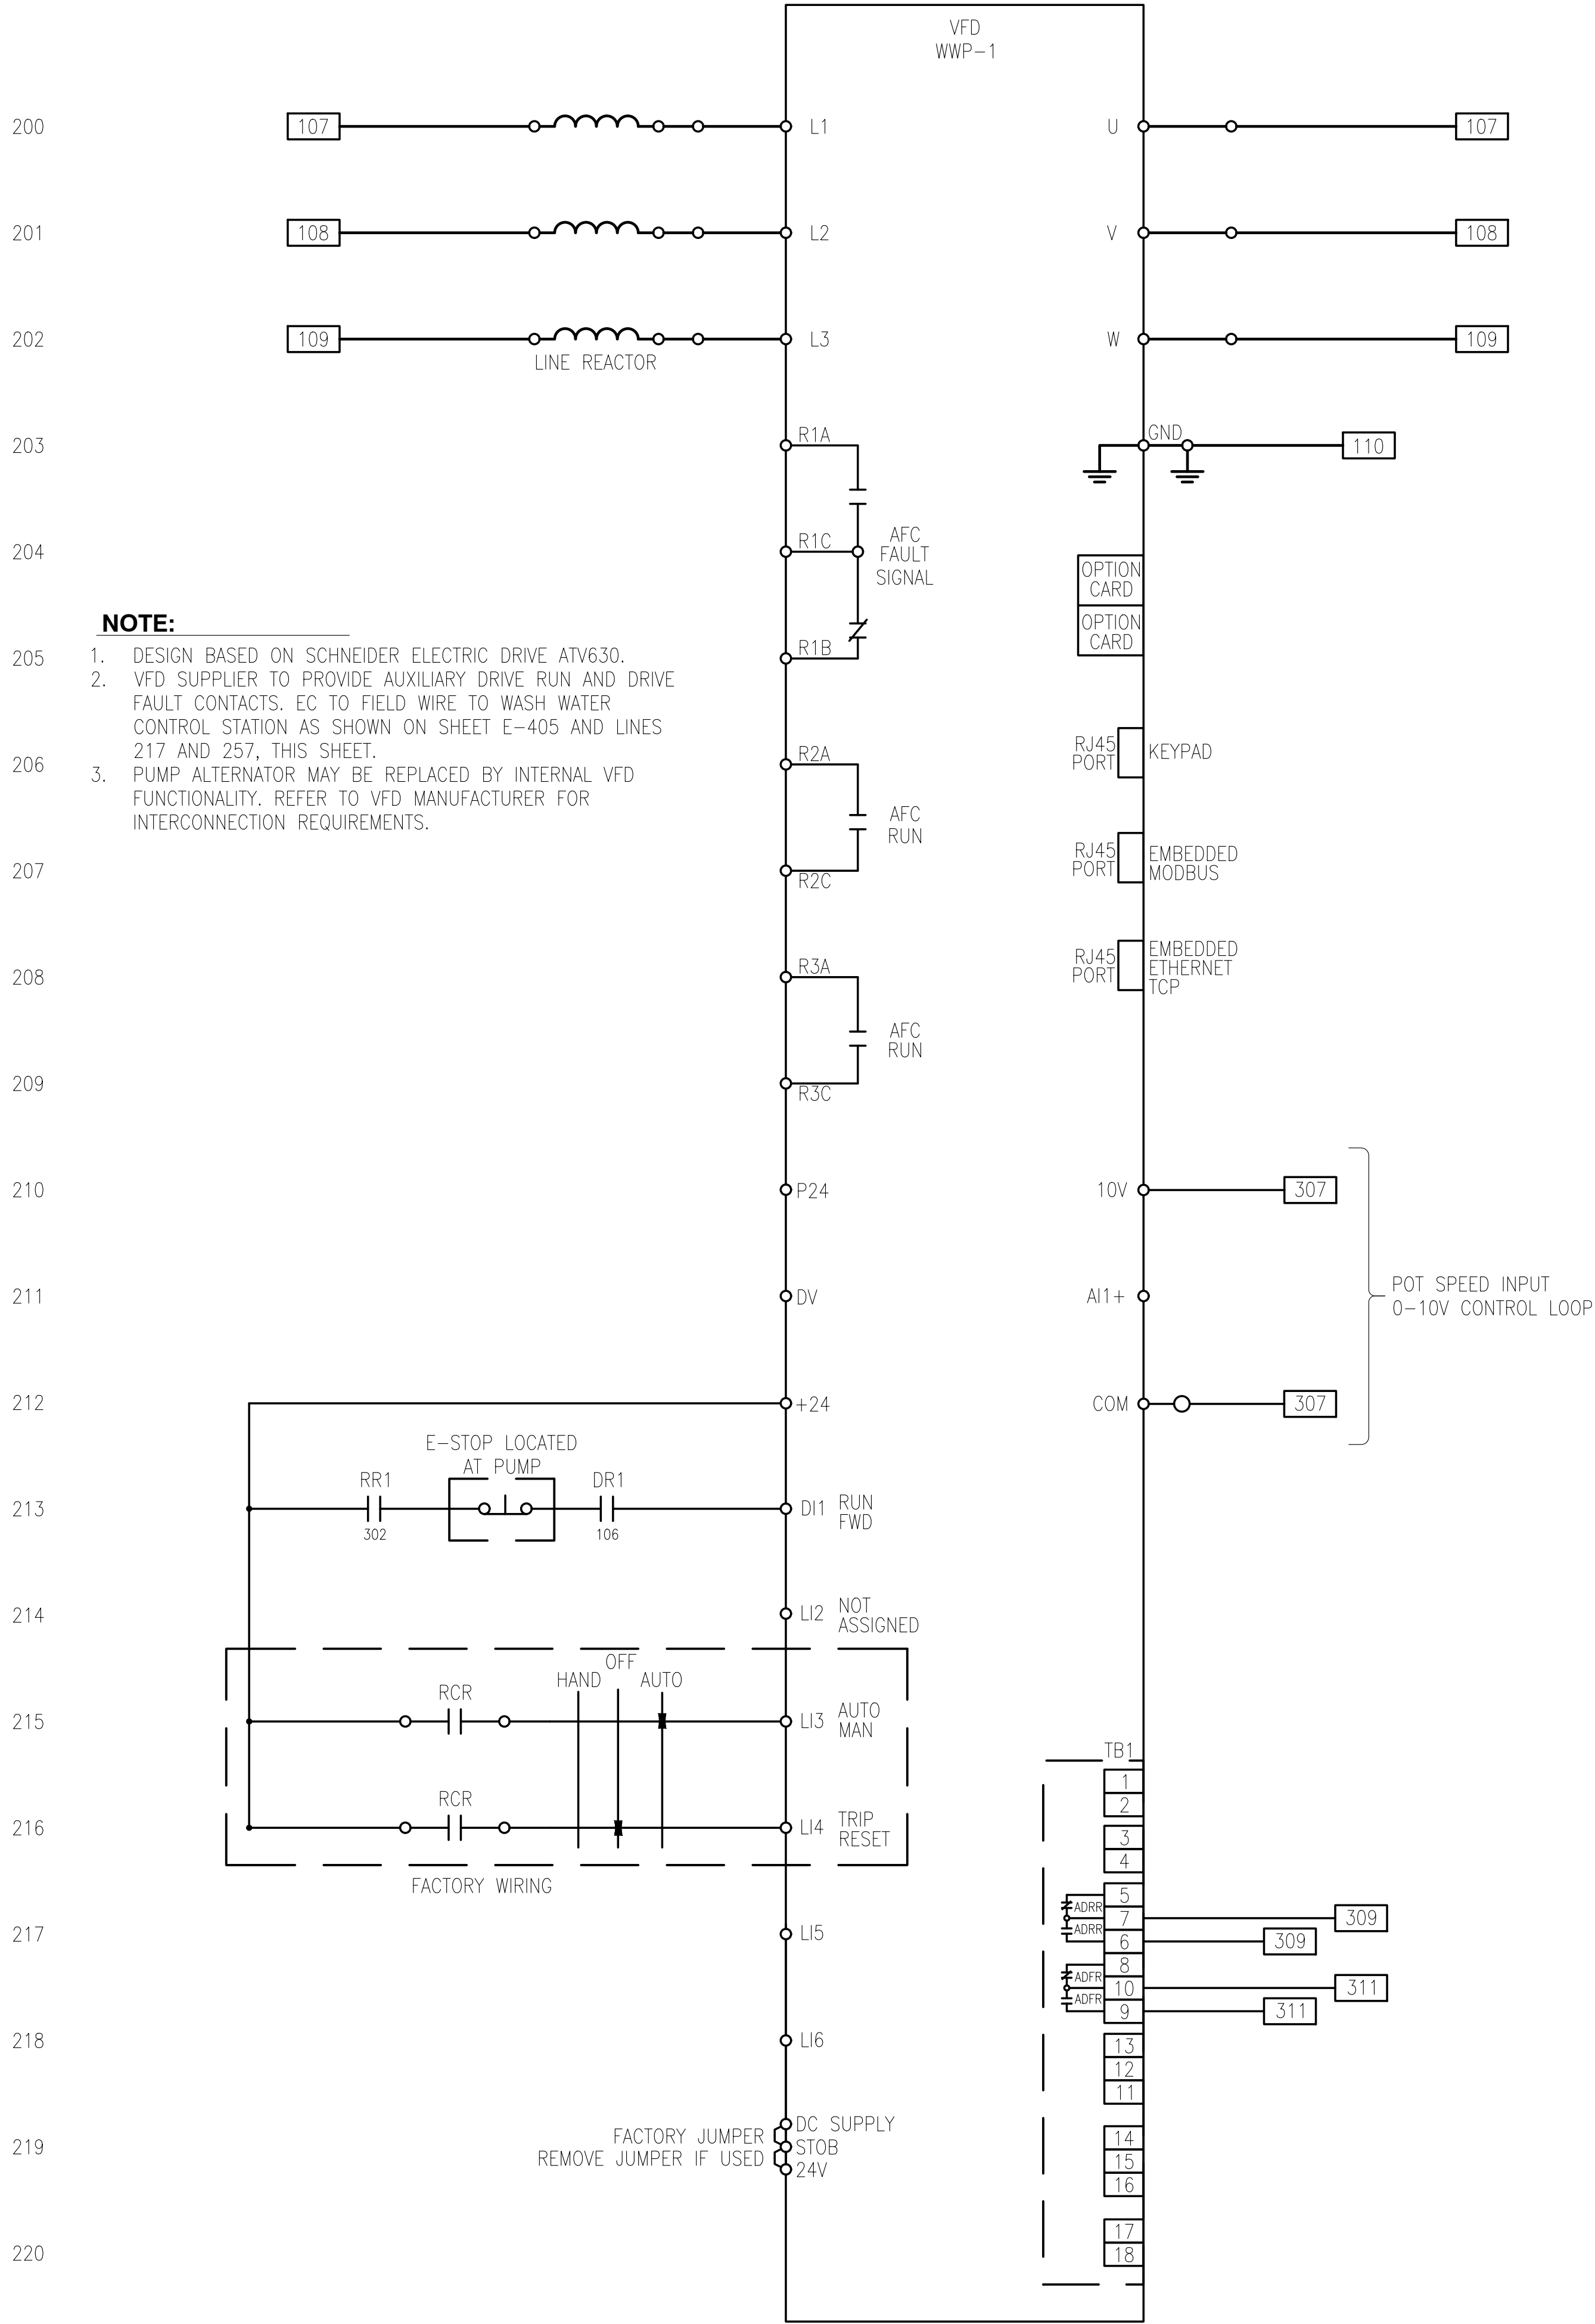

NOTE:

- DESIGN BASED ON SCHNEIDER ELECTRIC DRIVE ATV630.
- VFD SUPPLIER TO PROVIDE AUXILIARY DRIVE RUN AND DRIVE FAULT CONTACTS. EC TO FIELD WIRE TO WASH WATER CONTROL STATION AS SHOWN ON SHEET E-405 AND LINES 217 AND 257, THIS SHEET.
- PUMP ALTERNATOR MAY BE REPLACED BY INTERNAL VFD FUNCTIONALITY. REFER TO VFD MANUFACTURER FOR INTERCONNECTION REQUIREMENTS.

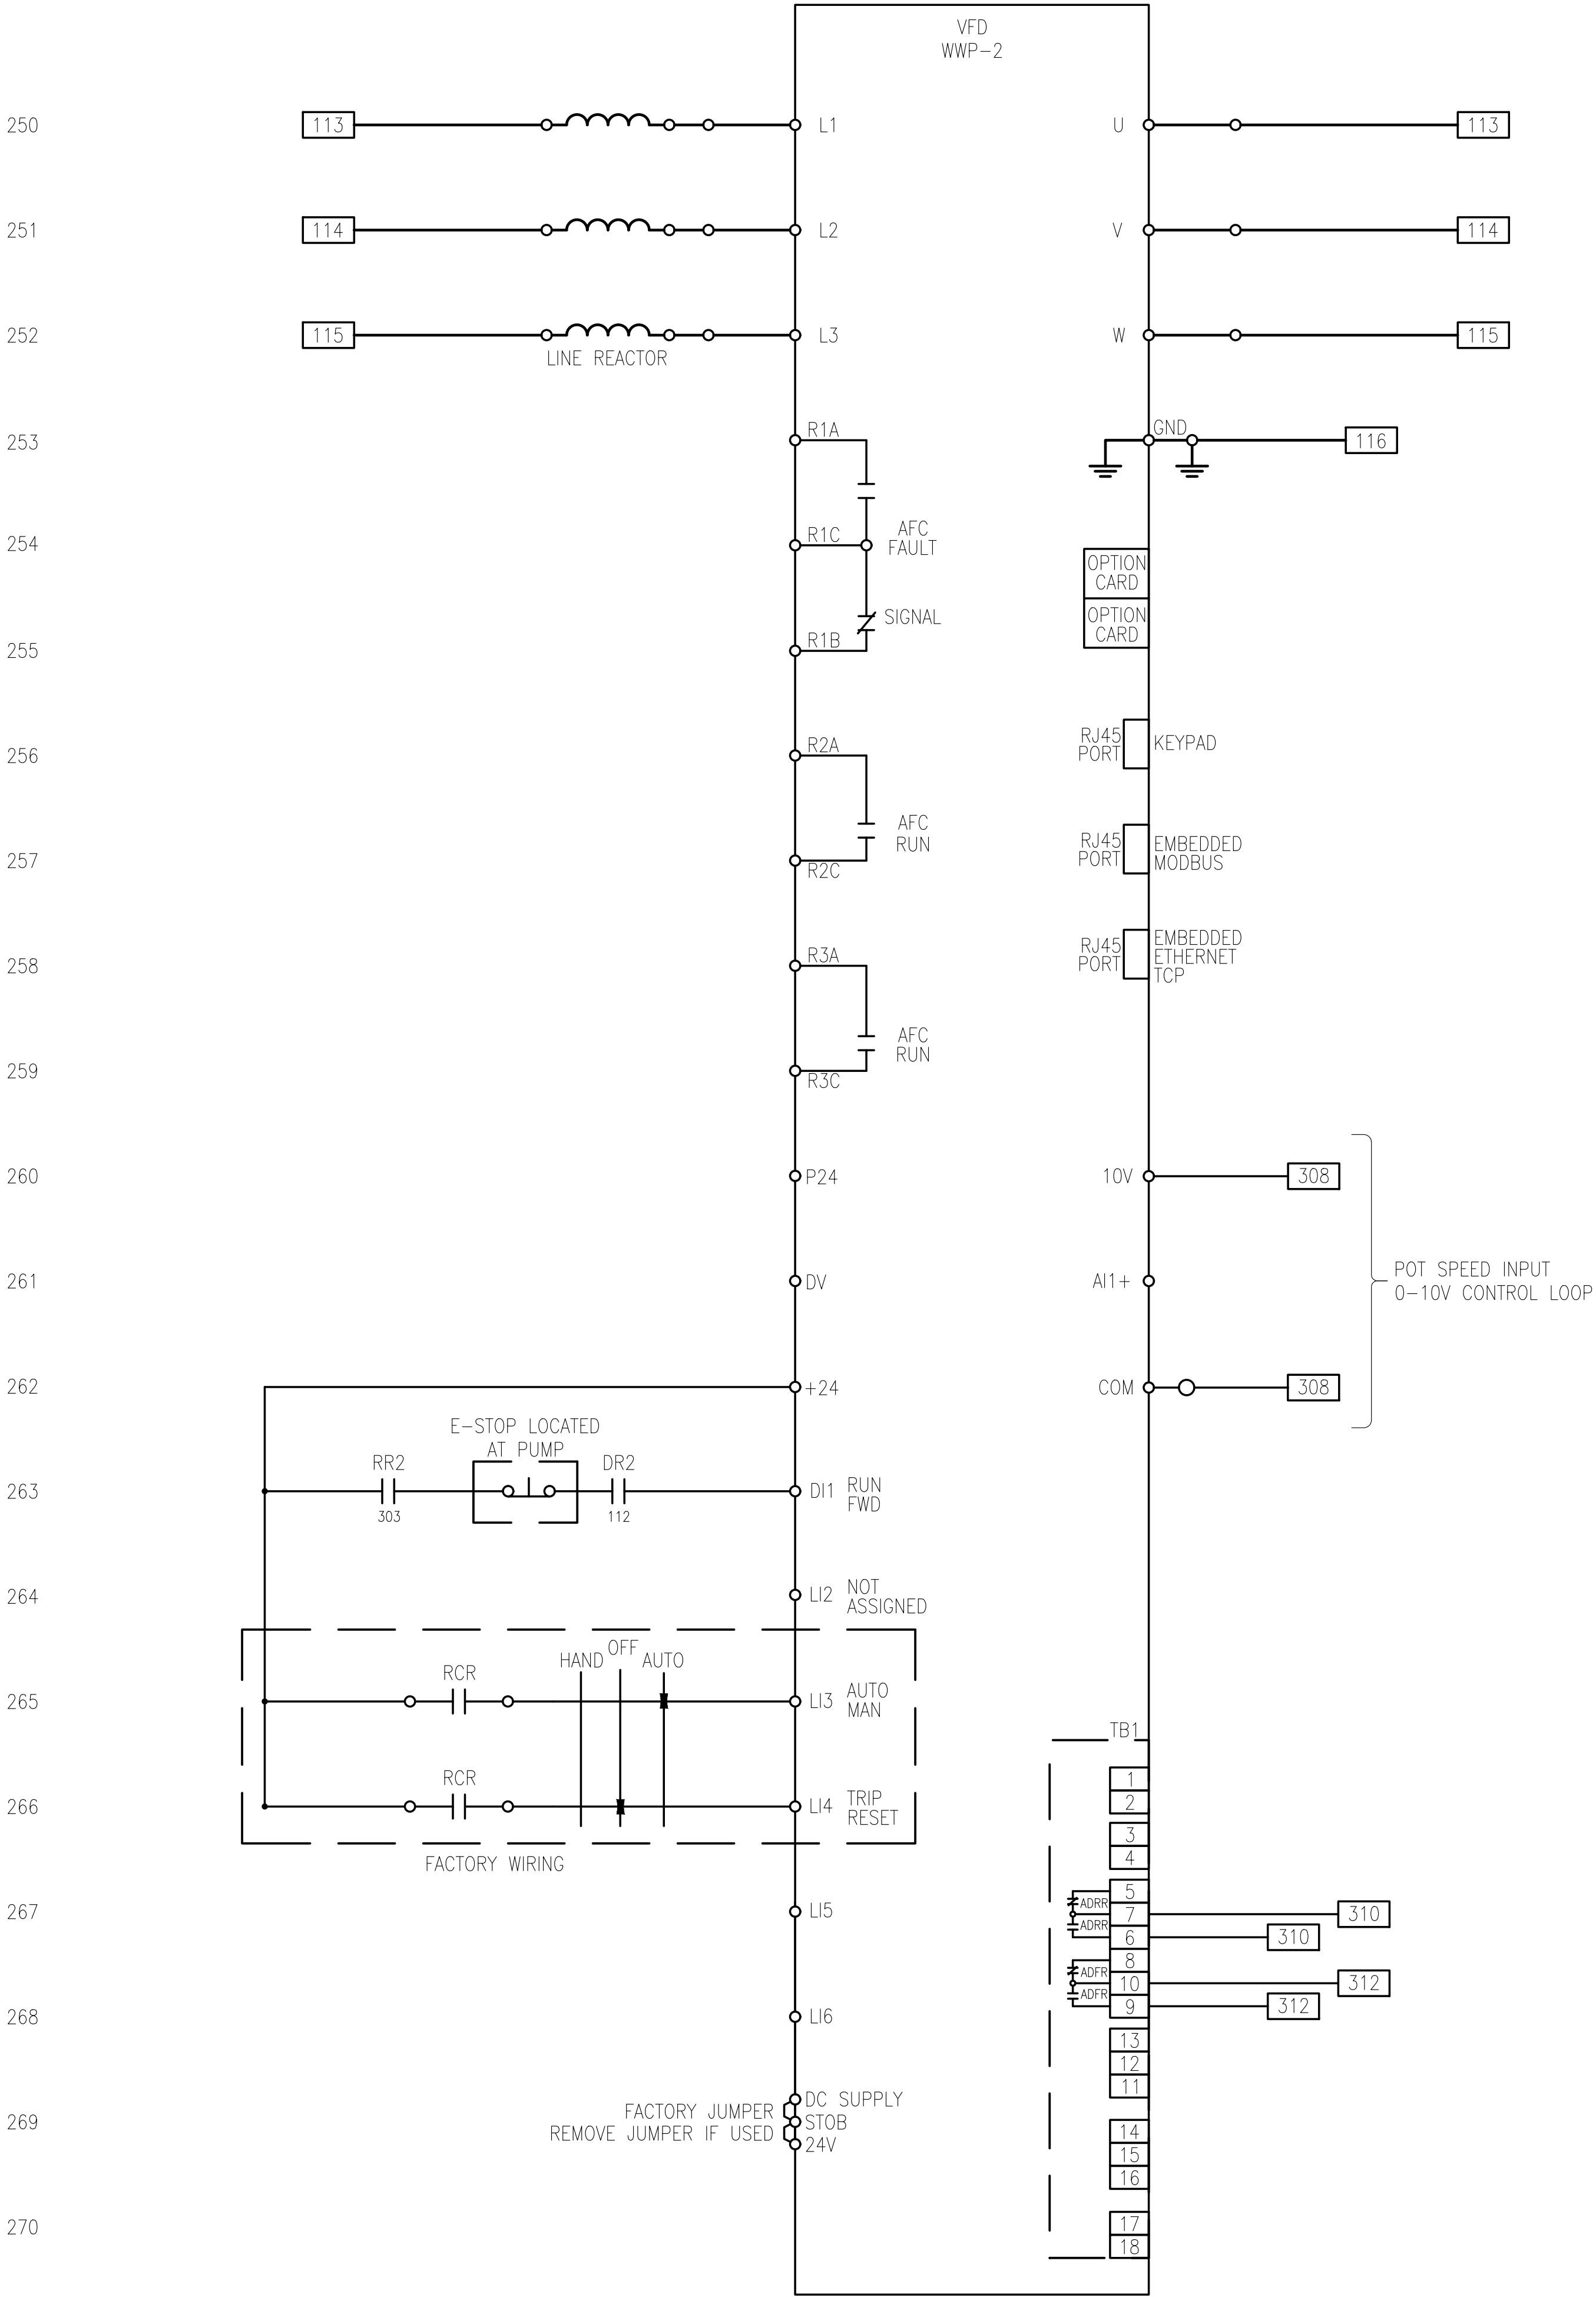



ARCHITECTS ENGINEERS PLANNERS

34000 Plymouth Road
Livonia, MI 48150
P (734) 522-6711 | F (734) 522-6427

OHM-ADVISORS.COM

ISSUED FOR BIDS

12/16/2019

DATE	PROJ NUMBER	ENG	PROJ MGR	CADD	COUNTY	CITY/VILLAGE/TOWNSHIP	SCALE	H	N	S	V	N	S	VERT DATUM	HORIZ DATUM	REVISIONS
	000514040	AK	JD	LAI	SHAWANSEE	OWOSSO								NA	NA	

CITY OF OWOSSO

WASH WATER PUMP & PIPING REPLACEMENT

VFD WIRING DIAGRAM

E-404

COPYRIGHT 2016 OHM ALL DRAWINGS AND WRITTEN MATERIALS APPEARING HEREIN CONSTITUTE THE ORIGINAL AND UNPUBLISHED WORK OF OHM AND THE SAME MAY NOT BE DUPLICATED, DISTRIBUTED OR DISCLOSED WITHOUT PRIOR WRITTEN CONSENT OF OHM

